
 
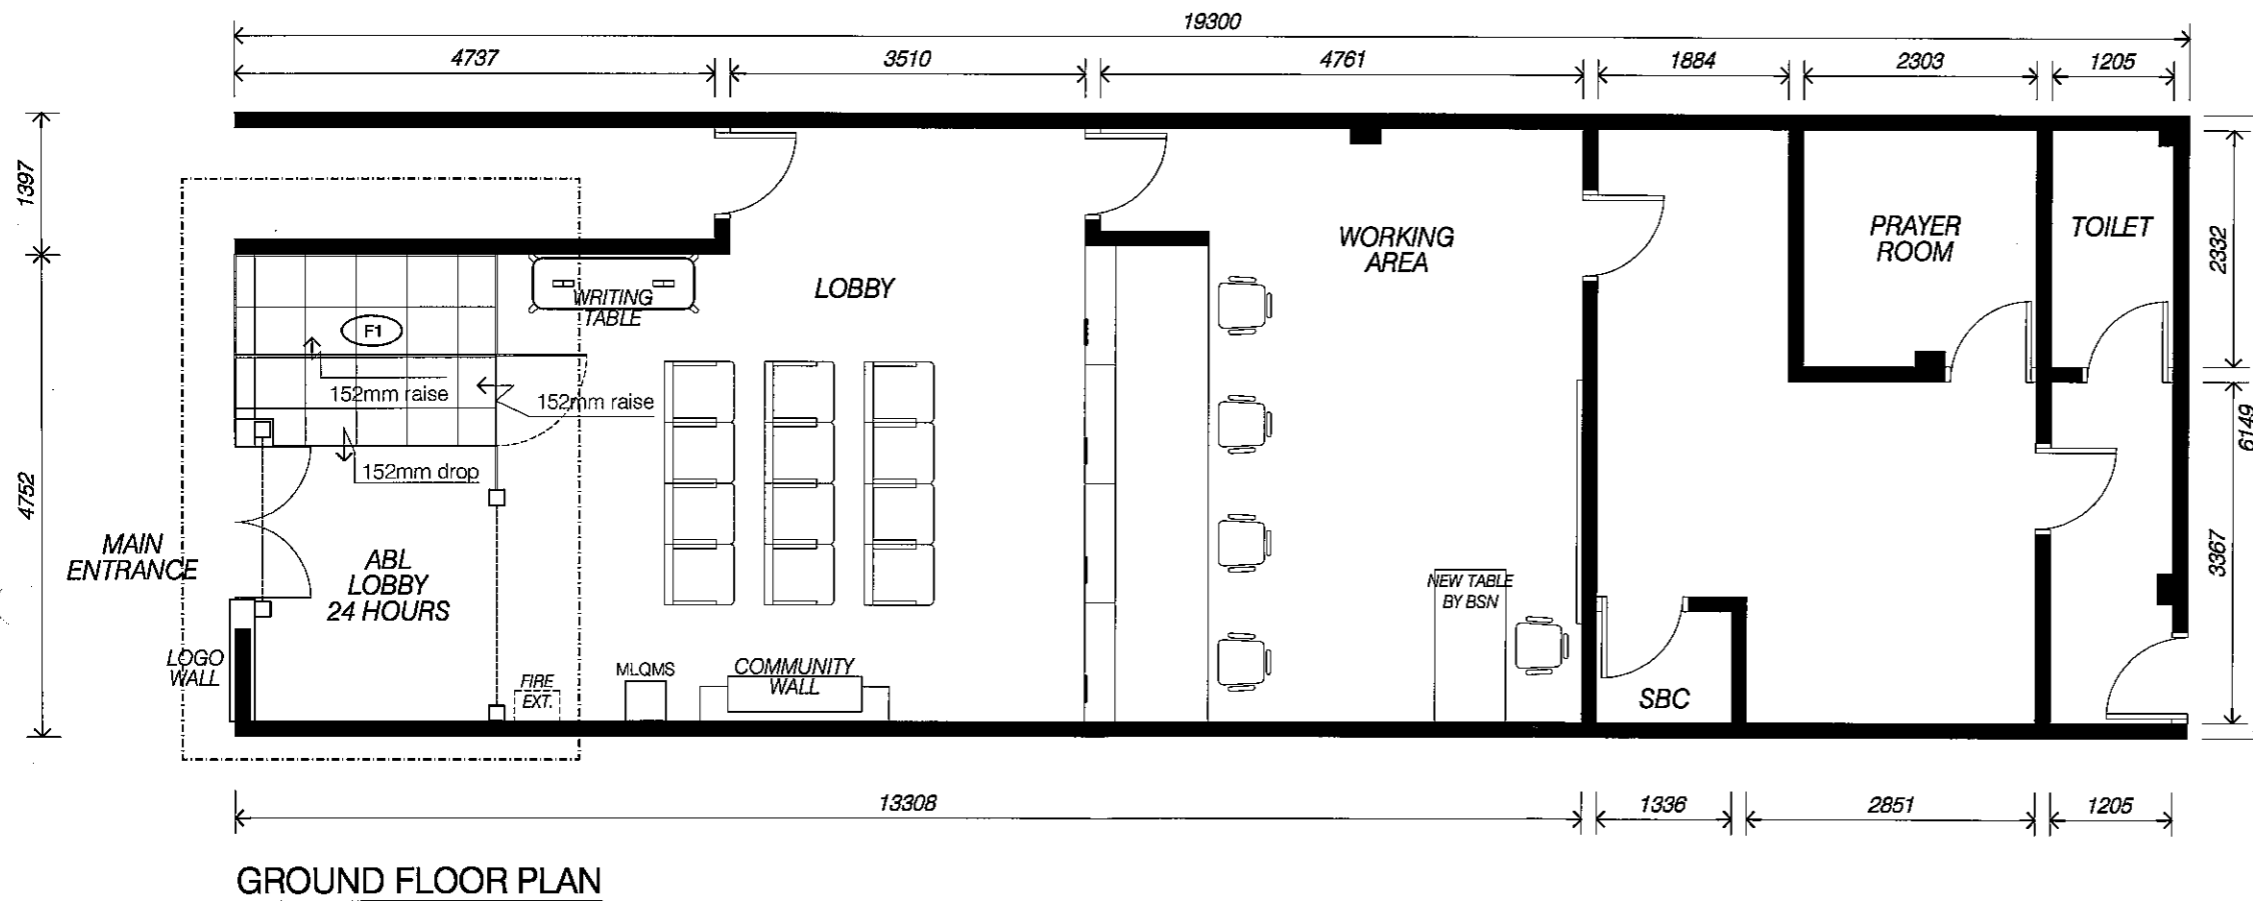


PROJECT TITLE:
**CADANGAN KERJA-KERJA RAISE UP FLOOR
 DI BAHAGIAN ABLCAWANGAN TANJUNG PIANDANG NO. 20,
 JALAN PIANDANG 1, TAMAN PIANDANG INDAH, 34200 TANJUNG PIANDANG, PERAK**

BSN-TANJUNGPiANDANG-01		DWG TITLE: GROUND FLOOR FLOOR FINISHES CODING PLAN	
BRNO: 31032012	DRAWN BY: SHAFIEZ	ISSUE: 1	BRANCH NAME: TANJUNG PIANDANG, PERAK
JOB NO: 21/01	SCALE: 1:75	DWG NO: S01-G-001	

GENERAL SYMBOLS	
BUILDING CORE AREA	
	DENOTES FLOOR FINISHES For detailed description of floor, refer floor section, details & finishes schedule


FLOOR FINISHES	
TYPE	DESCRIPTION
EX	EXISTING FLOOR -Finishes Specification by others
	SELECTED HOMOGENOUS TILE FLOORING GREY - COLOR (MATT FINISHES) -refer finishes schedule
NOTE : - All the above finishes specifications refer to 'I.D Floor Finishes Schedule' & floor termination details refer to 'Typical Floor Details' drawing.	



PROJECT TITLE:
**CADANGAN KERJA-KERJA RAISE UP FLOOR
 DI BAHAGIAN ABLCAWANGAN TANJUNG PIANDANG NO. 20,
 JALAN PIANDANG 1, TAMAN PIANDANG INDAH, 34200 TANJUNG PIANDANG, PERAK**

BSN-TANJUNGPiANDANG-01		DWG TITLE: GROUND FLOOR FLOOR FINISHES CODING PLAN	
BRN NO: 31032012	DRAWN BY: SHAFIEZ	ISSUE: 1	BRANCH NAME: TANJUNG PIANDANG, PERAK
JOB NO: 21/01	SCALE: 1 : 75	DWG NO: S04-G-001	


LEGEND	DESCRIPTION
⚡	2 NOS. 13A S/S/O
P	INDICATES 300mm HT

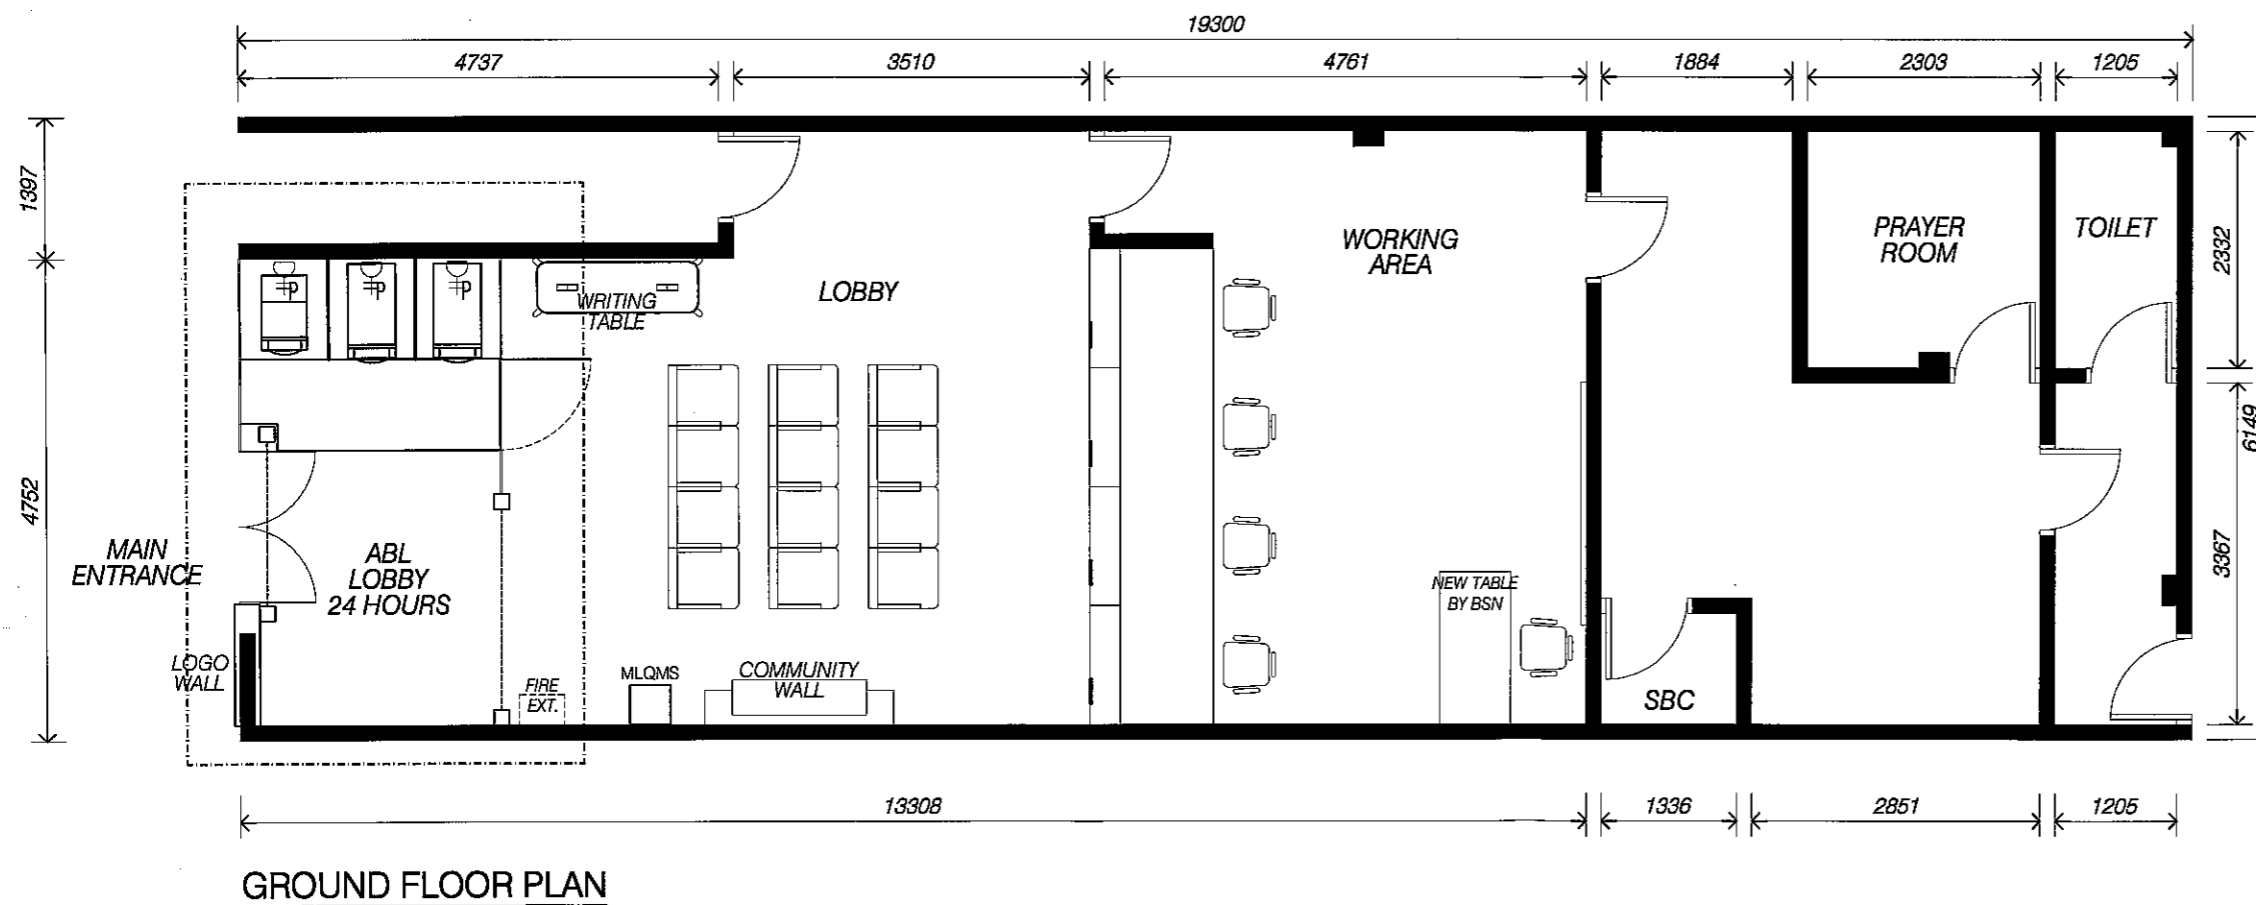

PROJECT TITLE:
**CADANGAN KERJA-KERJA RAISE UP FLOOR
 DI BAHAGIAN ABLCAWANGAN TANJUNG PIANDANG NO. 20,
 JALAN PIANDANG 1, TAMAN PIANDANG INDAH, 34200 TANJUNG PIANDANG, PERAK**

BSN-TANJUNGPIANDANG-01		DWG TITLE: GROUND FLOOR POWER LAYOUT PLAN	
BRN NO: 31032012	DRAWN BY: SHAFIEZ	ISSUE: 1	BRANCH NAME: TANJUNG PIANDANG, PERAK
JOB NO: 21/01	SCALE: 1 : 75	DWG NO: ELECTRICAL SERVICES - 02	


LEGEND	DESCRIPTION
3D	3 NOS. CAT6 DATA POINT
1Da	1 NOS. CAT6 DATA POINT (ATM Indicator point to point direct from each ATM to Relief Officer Area)
P	INDICATES 300mm HT
H4	INDICATES 2100mm HT

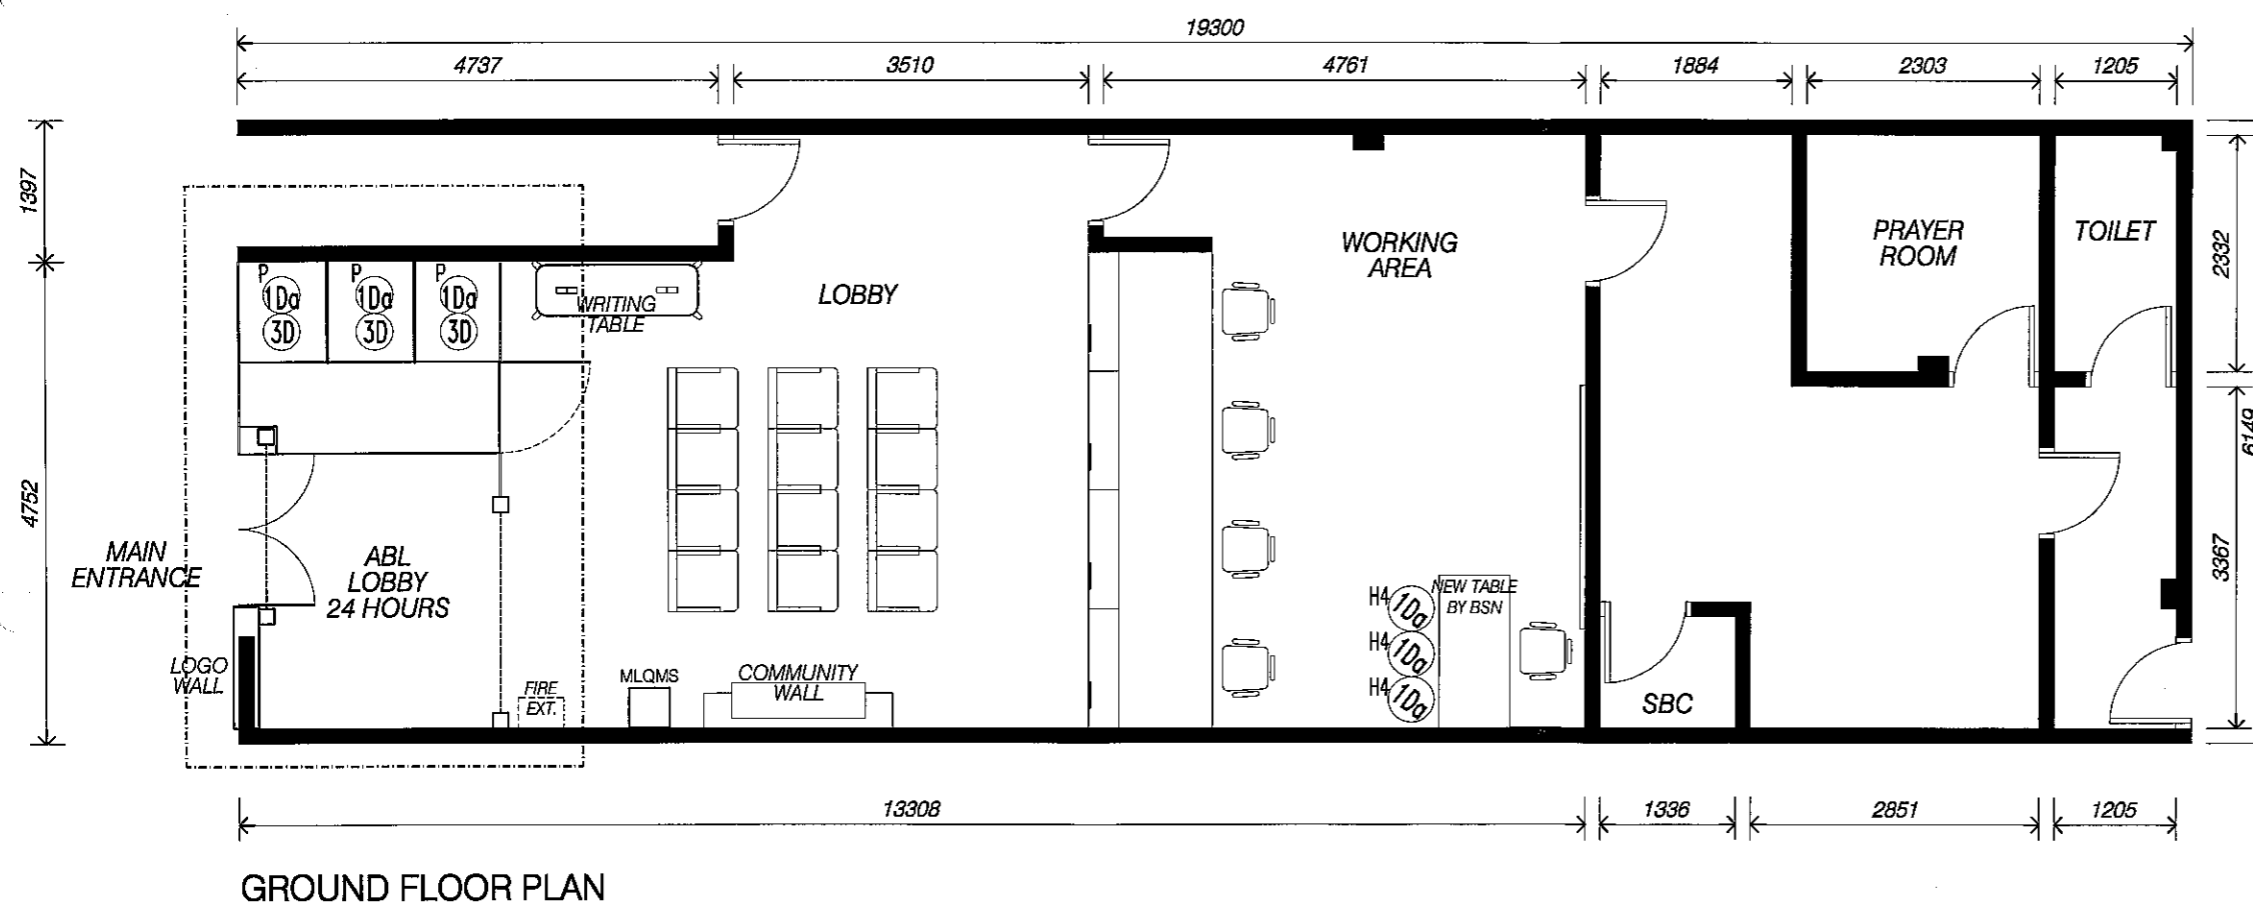

PROJECT TITLE:
**CADANGAN KERJA-KERJA RAISE UP FLOOR
 DI BAHAGIAN ABLCAWANGAN TANJUNG PIANDANG NO. 20,
 JALAN PIANDANG 1, TAMAN PIANDANG INDAH, 34200 TANJUNG PIANDANG, PERAK**

BSN-TANJUNGPiANDANG-01		DWG TITLE: GROUND FLOOR TELEPHONE & STRUCTURED CABLING LAYOUT PLAN	
BRN NO: 31032012	DRAWN BY: SHAFIEZ	ISSUE: 1	BRANCH NAME: TANJUNG PIANDANG, PERAK
JOB NO: 21/01	SCALE: 1 : 75		DWG NO: TELEPHONE & DATA SERVICES - 01

LEGEND	DESCRIPTION	QTY
⊗	SEISMIC DETECTOR BURGOGUARD / SHOTGUARD	3
▭	SURFACE MAGNETIC CONTACT	9

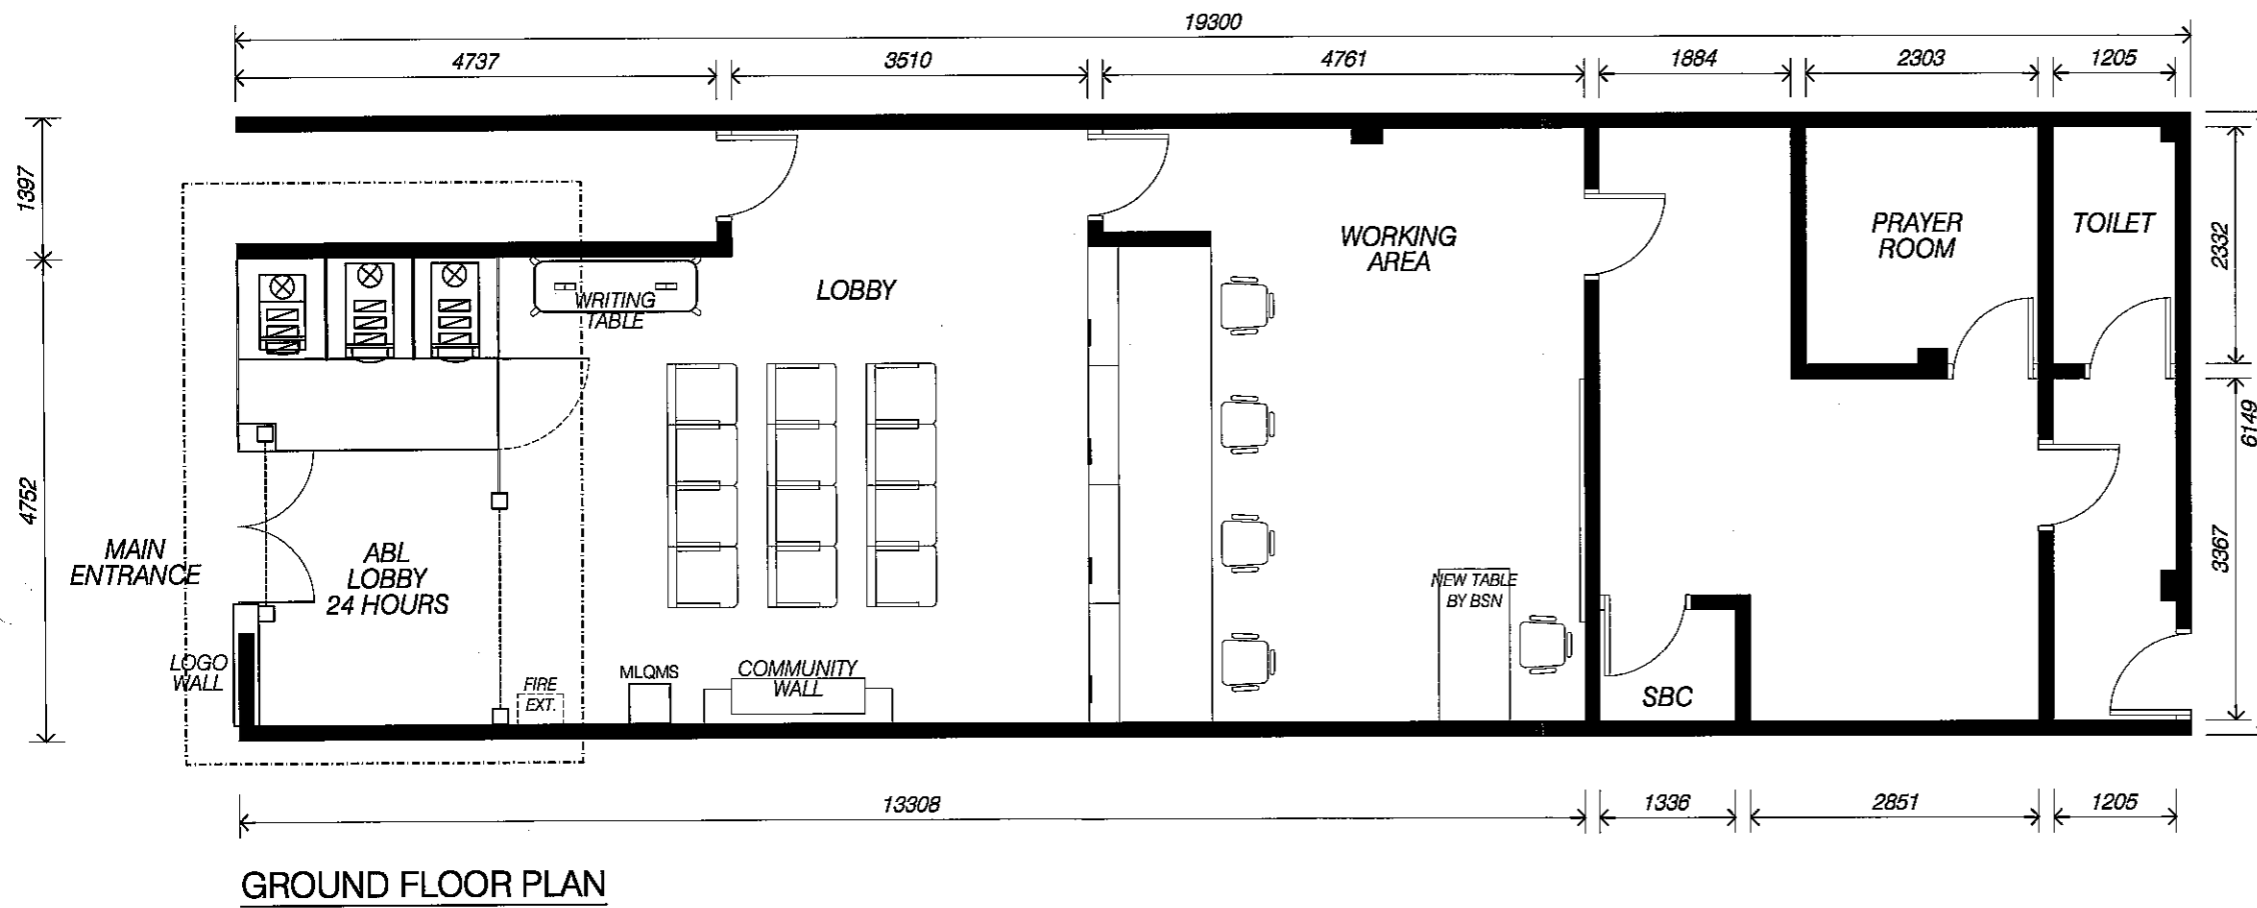

PROJECT TITLE:
**CADANGAN KERJA-KERJA RAISE UP FLOOR
 DI BAHAGIAN ABLCAWANGAN TANJUNG PIANDANG NO. 20,
 JALAN PIANDANG 1, TAMAN PIANDANG INDAH, 34200 TANJUNG PIANDANG, PERAK**

BSN-TANJUNGPIANDANG-01		DWG TITLE: GROUND FLOOR ALARM LAYOUT PLAN	
DRAWING NO: 31032012	DRAWN BY: SHAFIEZ	ISSUE: 1	BRANCH NAME: TANJUNG PIANDANG, PERAK
JOB NO: 21/01	SCALE: 1 : 75	DWG NO: ALARM SERVICES - 01	