

VOLUME 2 OF 2

LUKISAN SEBUTHARGA

**PROPOSED INTERIOR FIT-OUT WORKS FOR BANK SIMPANAN
NASIONAL AT GROUND FLOOR, LOT 625, KAPIT BAZAAR, JALAN
SELIRIK, 96800 KAPIT, SARAWAK**

DRAWING LIST

SERIES 00 – DRAWING LIST & GENERAL NOTES + DRAWING REFERENCE	
SOO-G-DL	Drawing list
SOO-G-GN	General Notes & Drawing Reference
SOO-FS1	Finishes Schedule
BSN/KapitSarawak-01	Existing Layout Plan
S01-G-001	Proposed Layout Plan
S02-G-001	Setting Out Plan
S02-G-002	Partition Coding Plan
S02-G-004	Wall Finishes & Door Coding Plan
S03-G-001	Reflected Ceiling Plan
S04-G-001	Floor Finishes Coding Plan
S05-G-002	Joinery Coding Plan
S05-G-002a	Furniture Setting Out Plan
S05-G-003	Loose Furniture Coding Plan
Electrical Services -01	Lighting Layout Plan
Electrical Services -02	Power Layout Plan
Telephone & Date Services - 01	Telephone & Structured Cabling Layout Plan
CCTV & Card Access Servies -01	CCTV & Card Access Layout Plan
Alarm Services - 01	Alarm Layout Plan
Mechanical Services - 01	Aircond & Exhaust Fan Layout Plan
Mechanical Services - 02	Sanitary Fitting & Diagram Layout Plan
Mechanical Services - 03	Fire Fighting Layout Plan

SERIES 01 – PARTITION & WALL TYPE DETAILS	
S02-G-003	Partition & Wall Type Details - Type 1 & 1A
S02-G-003A	Partition & Wall Type Details - Type 1B, 1C & 1D
S02-G-003B	Partition & Wall Type Details - Type 1E & 1F
S02-G-003C	Partition & Wall Type Details - Type 2, 2A & 2B
S02-G-003D	Partition & Wall Type Details - Type 3 & 3A
S02-G-003E	Partition & Wall Type Details - Type 4

SERIES 02 – DOOR DETAILS & SCHEDULE + DETAILS & IRON MONGERY SCHEDULE	
S02-G-005	Door Detail - Elevations - Door Type A & B
S02-G-005A	Door Detail - Elevations - Door Type C & D
S02-G-005B	Door Detail - Elevations - Door Type E , EA & J
S02-G-005C	Door Detail - Elevations - Door Type F
S02-G-005D	Door Detail - Elevations - Door Type G
S02-G-005E	Door Detail - Elevations - Door Type H & K

SERIES 03 – CEILING DETAILS	
S03-G-003	Typical Ceiling Detail


SERIES 04 - FLOOR FINISHES DETAILS	
S04-G-002	Typical Floor Details
S04-G-002a	Typical Floor Details

SERIES 05 - JOINERY SPECIFICATION & DETAILS	
S05-G-001	Joinery Cover Notes
S05-G-007	BF3 - Logo Wall
S05-G-007a	BF3a - Logo Wall
S05-G-007a	BF3a & BF3b - Community Wall
S05-G-007b	BF3, BF3a & BF3b - Community Wall Section

SERIES 05 - JOINERY SPECIFICATION & DETAILS	
S05-G-008	BF4 - MLQMS + Community Feature Wall
S05-G-008a	BF4 - MLQMS + Community Feature Wall
S05-G-008b	BF4 - MLQMS + Community Feature Wall
S05-G-008c	BF4 - MLQMS + Community Feature Wall
S05-G-008d	BF4 - MLQMS + Community Feature Wall
S05-G-008e	BF4a - MLQMS Compartment
S05-G-008f	BF4a - MLQMS Compartment
S05-G-008g	BF4b - Community Feature Wall
S05-G-009	BF5 - Bar table
S05-G-009a	BF5 - Bar table
S05-G-010	BF6 - Distribution table
S05-G-010a	BF6 - Distribution table
S05-G-012	BF8 - Ledge (Printer)
S05-G-014	BF10 - Self Services Banking
S05-G-014a	BF10 - Self Services Banking
S05-G-014b	BF10 - Self Services Banking
S05-G-014c	BF10 - Self Services Banking
S05-G-014d	BF10 - Self Services Banking
S05-G-015b	BF12 - Teller Counter
S05-G-015c	BF12 - Teller Counter
S05-G-015d	BF12 - Teller Counter - Cash Compartment
S05-G-015e	BF12a - Teller Counter
S05-G-015f	BF12a - Teller Counter
S05-G-015g	BF12a - Teller Counter
S05-G-015h	BF12b - Teller Counter
S05-G-015i	BF12b - Teller Counter
S05-G-017	BF13 - Backdrop
S05-G-018	BF14 - Desk (For Relief Officer)
S05-G-021	BF15 - Filling Cabinet + Work Top
S05-G-021a	BF15 - Filling Cabinet + Work Top
S05-G-022	BF15a - DB Cabinet
S05-G-022a	BF15b - Filling Cabinet + Work Top
S05-G-022b	BF15c - Full Height Cabinet
S05-G-022c	BF15d - Low Cabinet
S05-G-023	BF16 - Bar Counter
S05-G-024	BF17 - Pantry Cabinet
S05-G-024a	BF17a - Pantry Cabinet
S05-G-025	BF18 - Graphic Wall + Hero Wall
S05-G-026	BF18a - Graphic Wall + Distribution Area
S05-G-030	BF21 - Logo Wall
S05-G-031	BF22 - Work Top

SERIES 06 - SIGNAGES	
S07-001	SG1 - Open / Close Signage
S07-002	SG2 - Logo Wall Signage
S07-003	SG3 - VTM & Teller Counter Numbering
S07-004	SG4 - Distribution Desk Numbering Signage
S07-005	SG5 - Entrance Logo Wall Signage
S07-006	SG6 - ATM & CDM Signage

 GENERAL NOTES

S01-L1-001	Denotes Series of Drawing Denotes Floor Level Denotes Numbers of Drawing
Series 00	Drawing List & General Notes + Drawing Reference
Series 01	General Layout Plan
Series 02	Partition Layout, Elevations, Details and Door Schedule and Details+Signages
Series 03	Reflected Ceiling Plan & Typical Ceiling Details
Series 04	Floor Finishes Plan & Typical Floor Details
Series 05	Joinery Cover Notes+Material Schedule & Joinery + Loose Furniture Plan+Specification & Joinery Details
Series 06	Signage
	Building Core Area - By Others Unless Otherwise Specified
	Denotes New Wet Wall
	Denotes New Dry Wall Partition
	Denotes Existing Wall To Be Demolished

PARTITION REFERENCE

	Denotes Partition Type
	Denotes Partition / Wall Finishes
	Denotes Direction for Elevation
	Denotes Numbers of Door Denotes Door Type For description of door, refer to Drawing of Door Types & Elevation
	Center Line Of Wall or Partition

CEILING REFERENCE

	Denotes Ceiling Level Denotes Ceiling Finishes
	Denotes Ceiling Detail Denotes Number Of Section Ceiling Detail
	Fibrous Plaster Ceiling
	Ceiling Tile 600mm X 600mm
	Ceiling Tile 600mm X 1200mm
	Denotes Manual Operated Roller Blinds And Curtains

LIGHTING & M&E REFERENCE

	PLC Downlight
	Halogen
	LED
	Decorative Pendant Light
	Cove Light
	Recessed Fluorescent Size : 600mm X 1200mm
	Recessed Fluorescent Size : 600mm X 600mm
	Square A/C Diffuser
	Linear A/C Diffuser

FLOOR REFERENCE

	Denotes Floor Detail Denotes Number Of Section Floor Detail
---	--

JOINERY REFERENCE

	Denotes Joinery Code
	Denotes Section Detail

LOOSE FURNITURE REFERENCE

	Denotes Loose Furniture Code
---	------------------------------

FINISHES CODE REFERENCE

CODE	DESCRIPTION
	Denotes Accessory Fitting
	Denotes Ceiling Finishes
	Denotes Floor Finishes
	Denotes Joinery Finishes
	Denotes Wall Finishes

150723	A	ISSUE FOR CONSTRUCTION	
DATE	ISSUE	DESCRIPTION	

DWG NO:
S00-C-CN

SCALE:

DWG TITLE:
**LEVEL G - GENERAL NOTES
+ DRAWING REFERENCE**

DATE: 150523

DRAWN BY: SH

ISSUE:

A

JOB NO: 13-1527

CHECK BY: SA

SL + A Sdn. Bhd. retain copyright of all designs and drawings shown in this drawing. Written permission is required for any use and/or reproduction. All prints, specifications and drawings are the property of SL + A Sdn. Bhd. and shall be returned on completion of works. Contractors to the project shall be responsible for any discrepancies on site and notify SL + A Sdn. Bhd. immediately.


FINISHES SCHEDULE

FLOOR FINISHES

Code / Symbol	Area	Material	Color	Range & No.	Sample	Client's Approval
F1	Lobby	600mm x 600mm Homogenous Tile	DCR66518			
F1	Back office area & walkway	600mm x 600mm Homogenous Tile	DCR66518N			
F3	Toilet Area	300mm x 600mm Homogenous Tile	DCR66518N			
F4	Main entrance	1500mm x 600mm 3M Floor Matt	Black colour			

WALL FINISHES

Code / Symbol	Area	Material	Color	Range & No.	Sample	Client's Approval
W1	General	Emulsion Paint	White			
W2		Emulsion Paint	Teal (To match BSN new C.I Colour to be confirm) PANTONE 320C			
W3	Toilet Area	300mm x 600mm Wall Tile	DCR66518N			

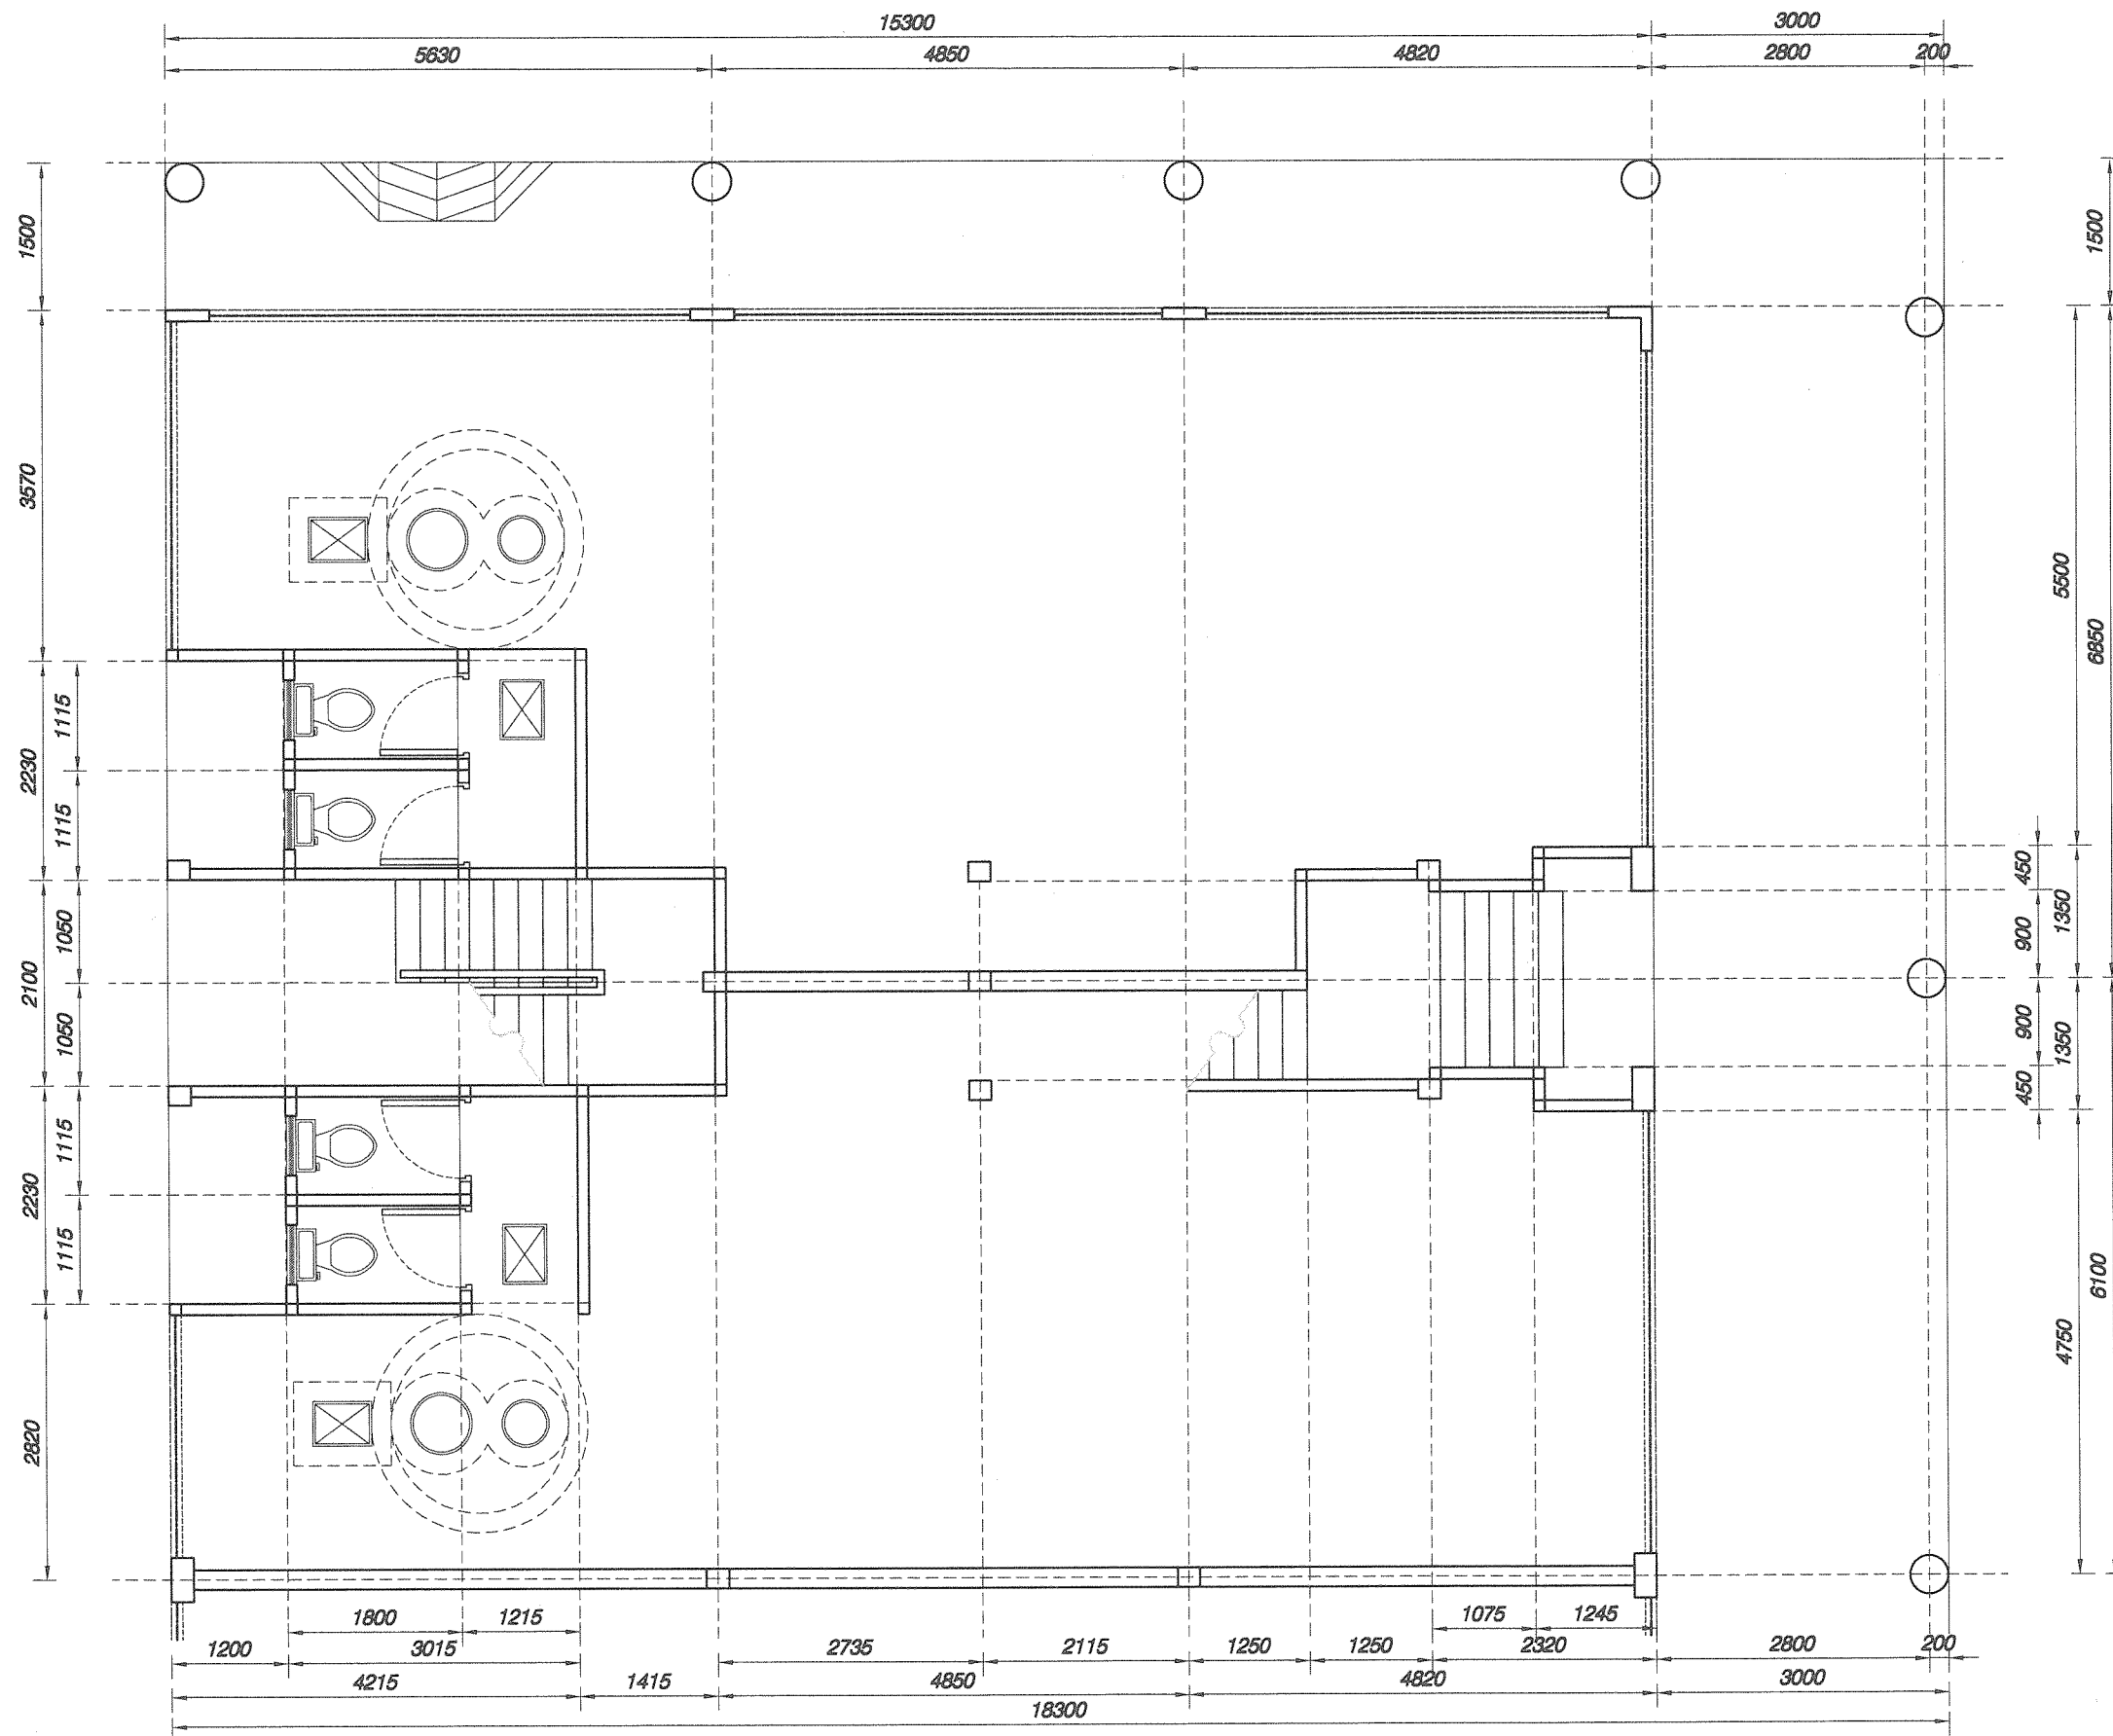

PROJECT TITLE:


PROPOSED INTERIOR FIT-OUT WORKS FOR
BANK SIMPANAN NASIONAL AT GROUND FLOOR & FIRST FLOOR,
LOT 625, KAPIT BAZAAR, JALAN SELIRIK, 96800 KAPIT, SARAWAK

DWG NO:
BSN-KapitSarawak-01

DATE: 120121 DRAWN BY: AYIE

JOB NO: 21/01 SCALE: 1 : 75


DWG TITLE:
GROUND FLOOR
EXISTING LAYOUT PLAN

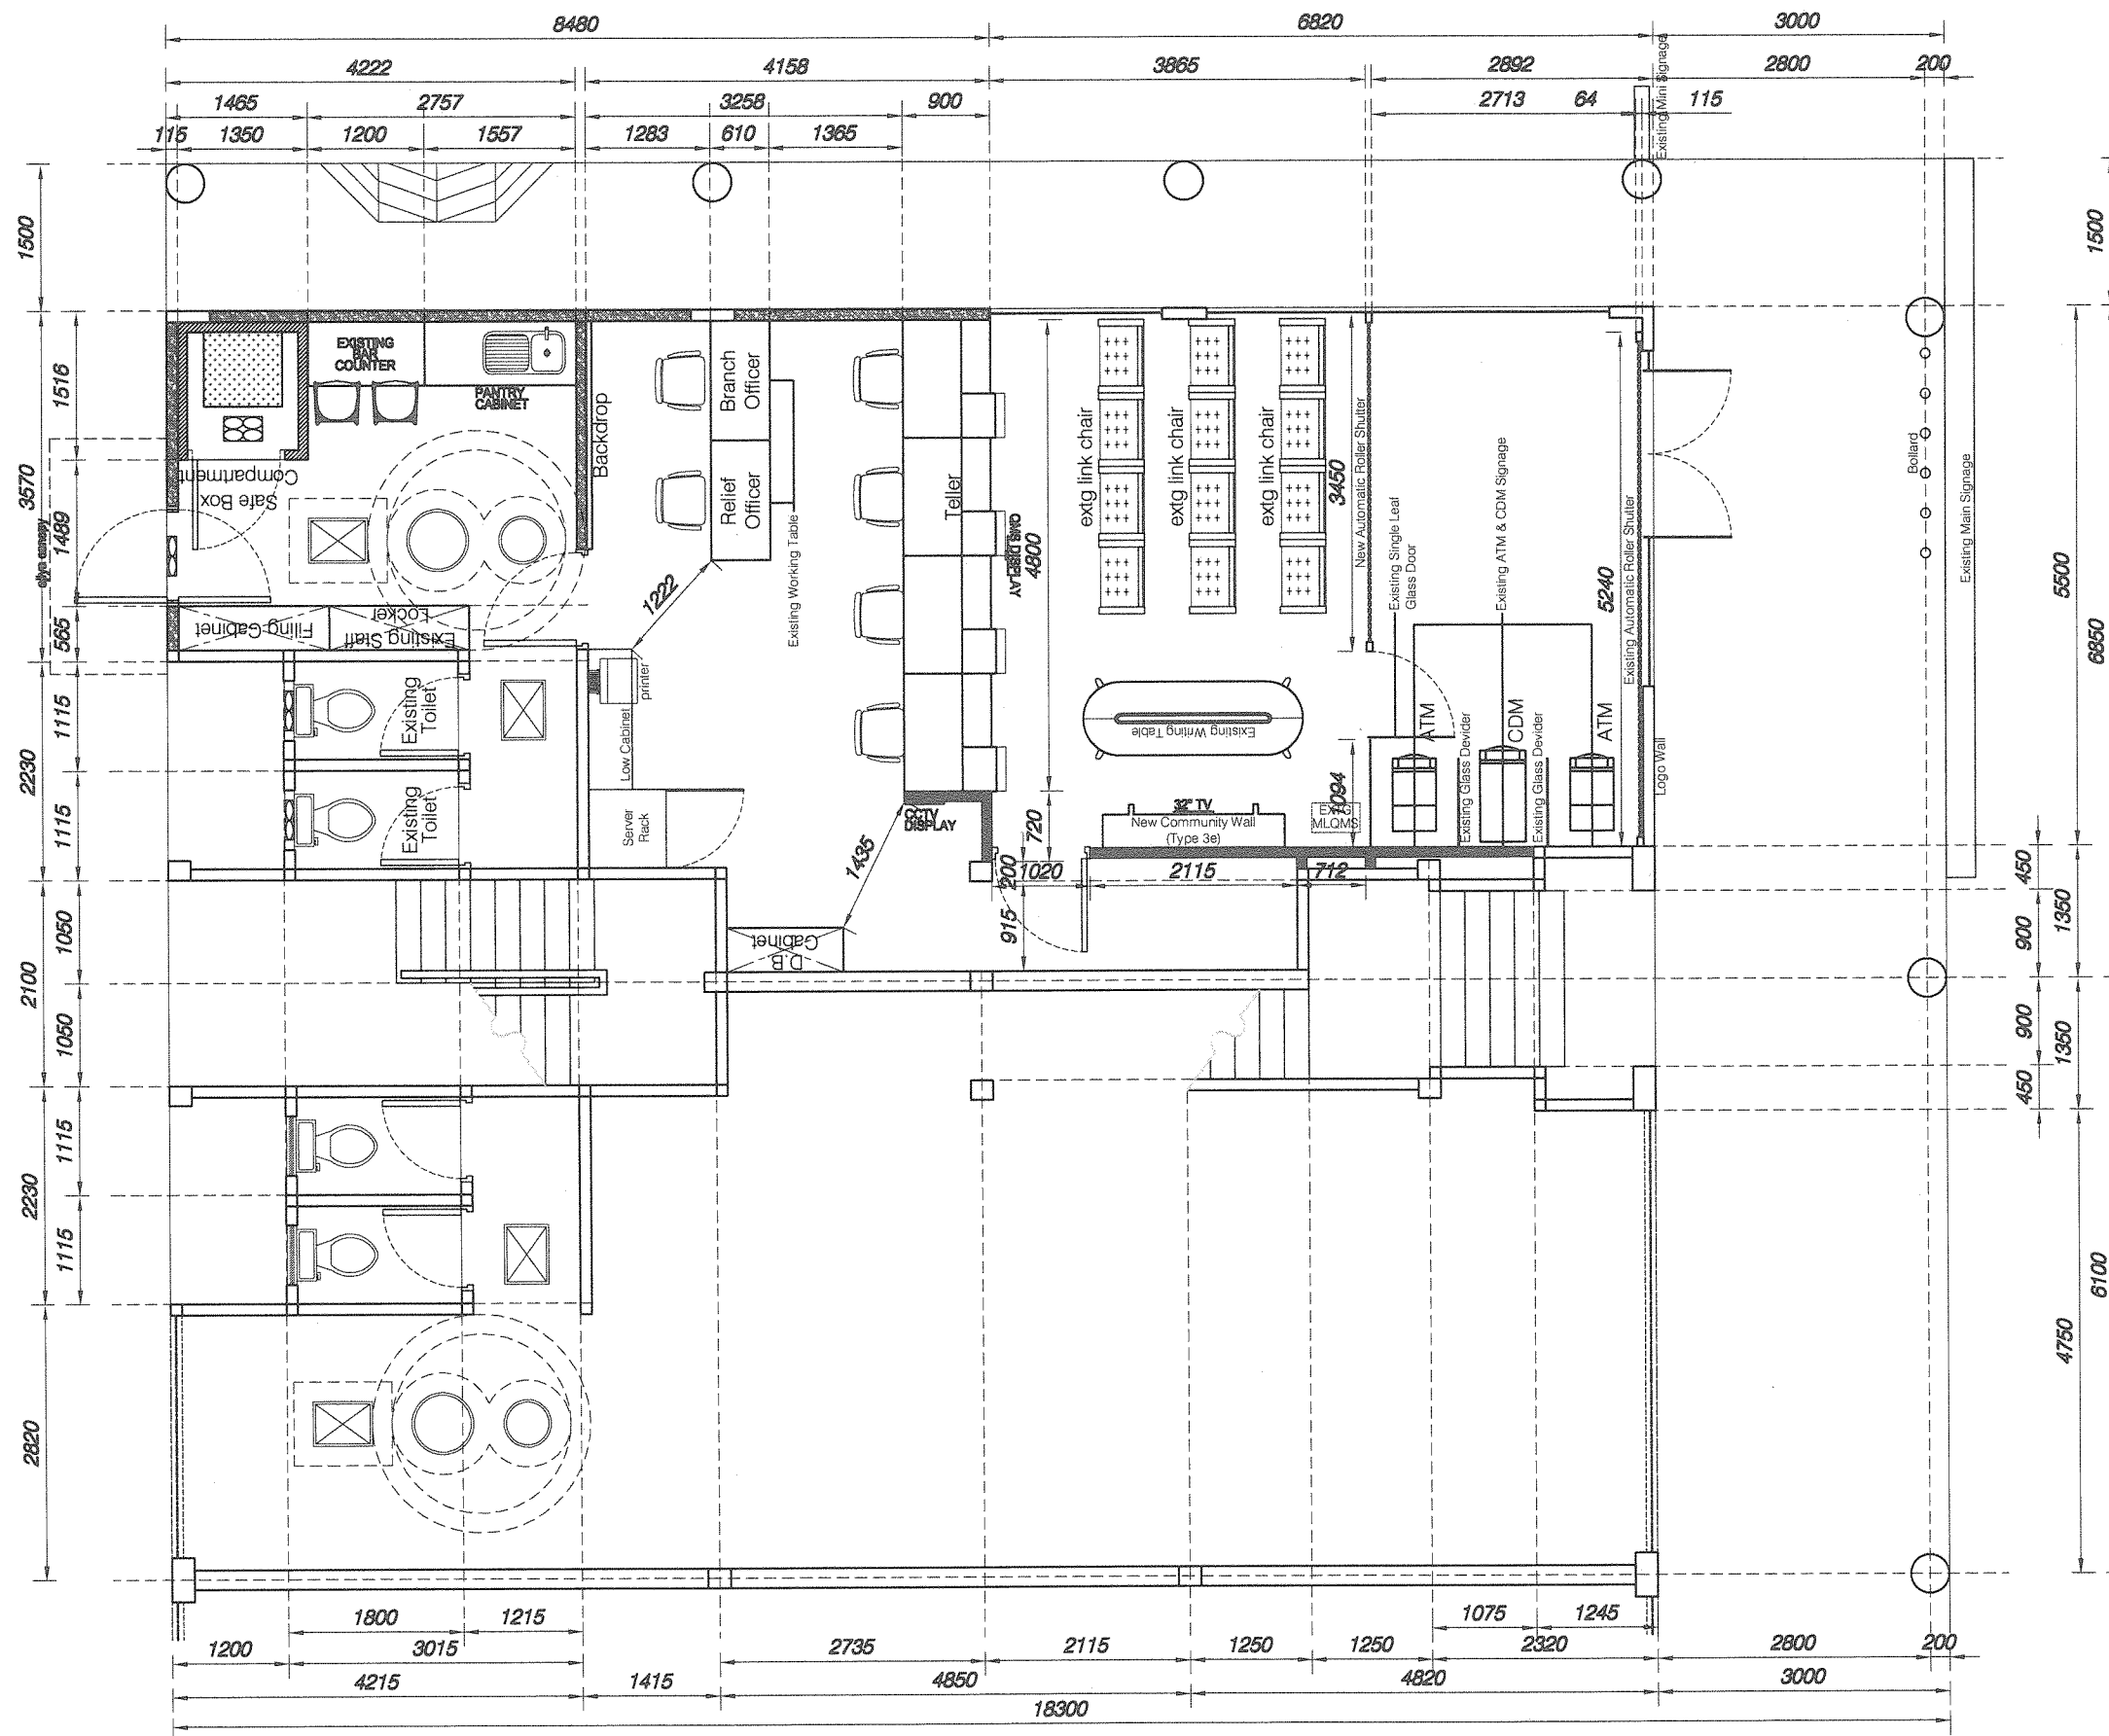

GENERAL SYMBOLS	
	BUILDING CORE AREA
	DENOTES NEW DRYWALL PARTITION
	DENOTES GLASS WALL PARTITION

PROJECT TITLE:
 PROPOSED INTERIOR FIT-OUT WORKS FOR
 BANK SIMPANAN NASIONAL AT GROUND FLOOR & FIRST FLOOR,
 LOT 625, KAPIT BAZAAR, JALAN SELIRIK, 96800 KAPIT, SARAWAK


FILE NO: BSN/IP/JPAK/FD/2020-03	DWG TITLE: GROUND FLOOR PROPOSED LAYOUT PLAN
DATE: 170321	DRAWN BY: AYIE
JOB NO: 21/01	SCALE: 1 : 75
ISSUE: 2	BRANCH NAME: KAPIT, SARAWAK
	DWG NO: S01-G-001

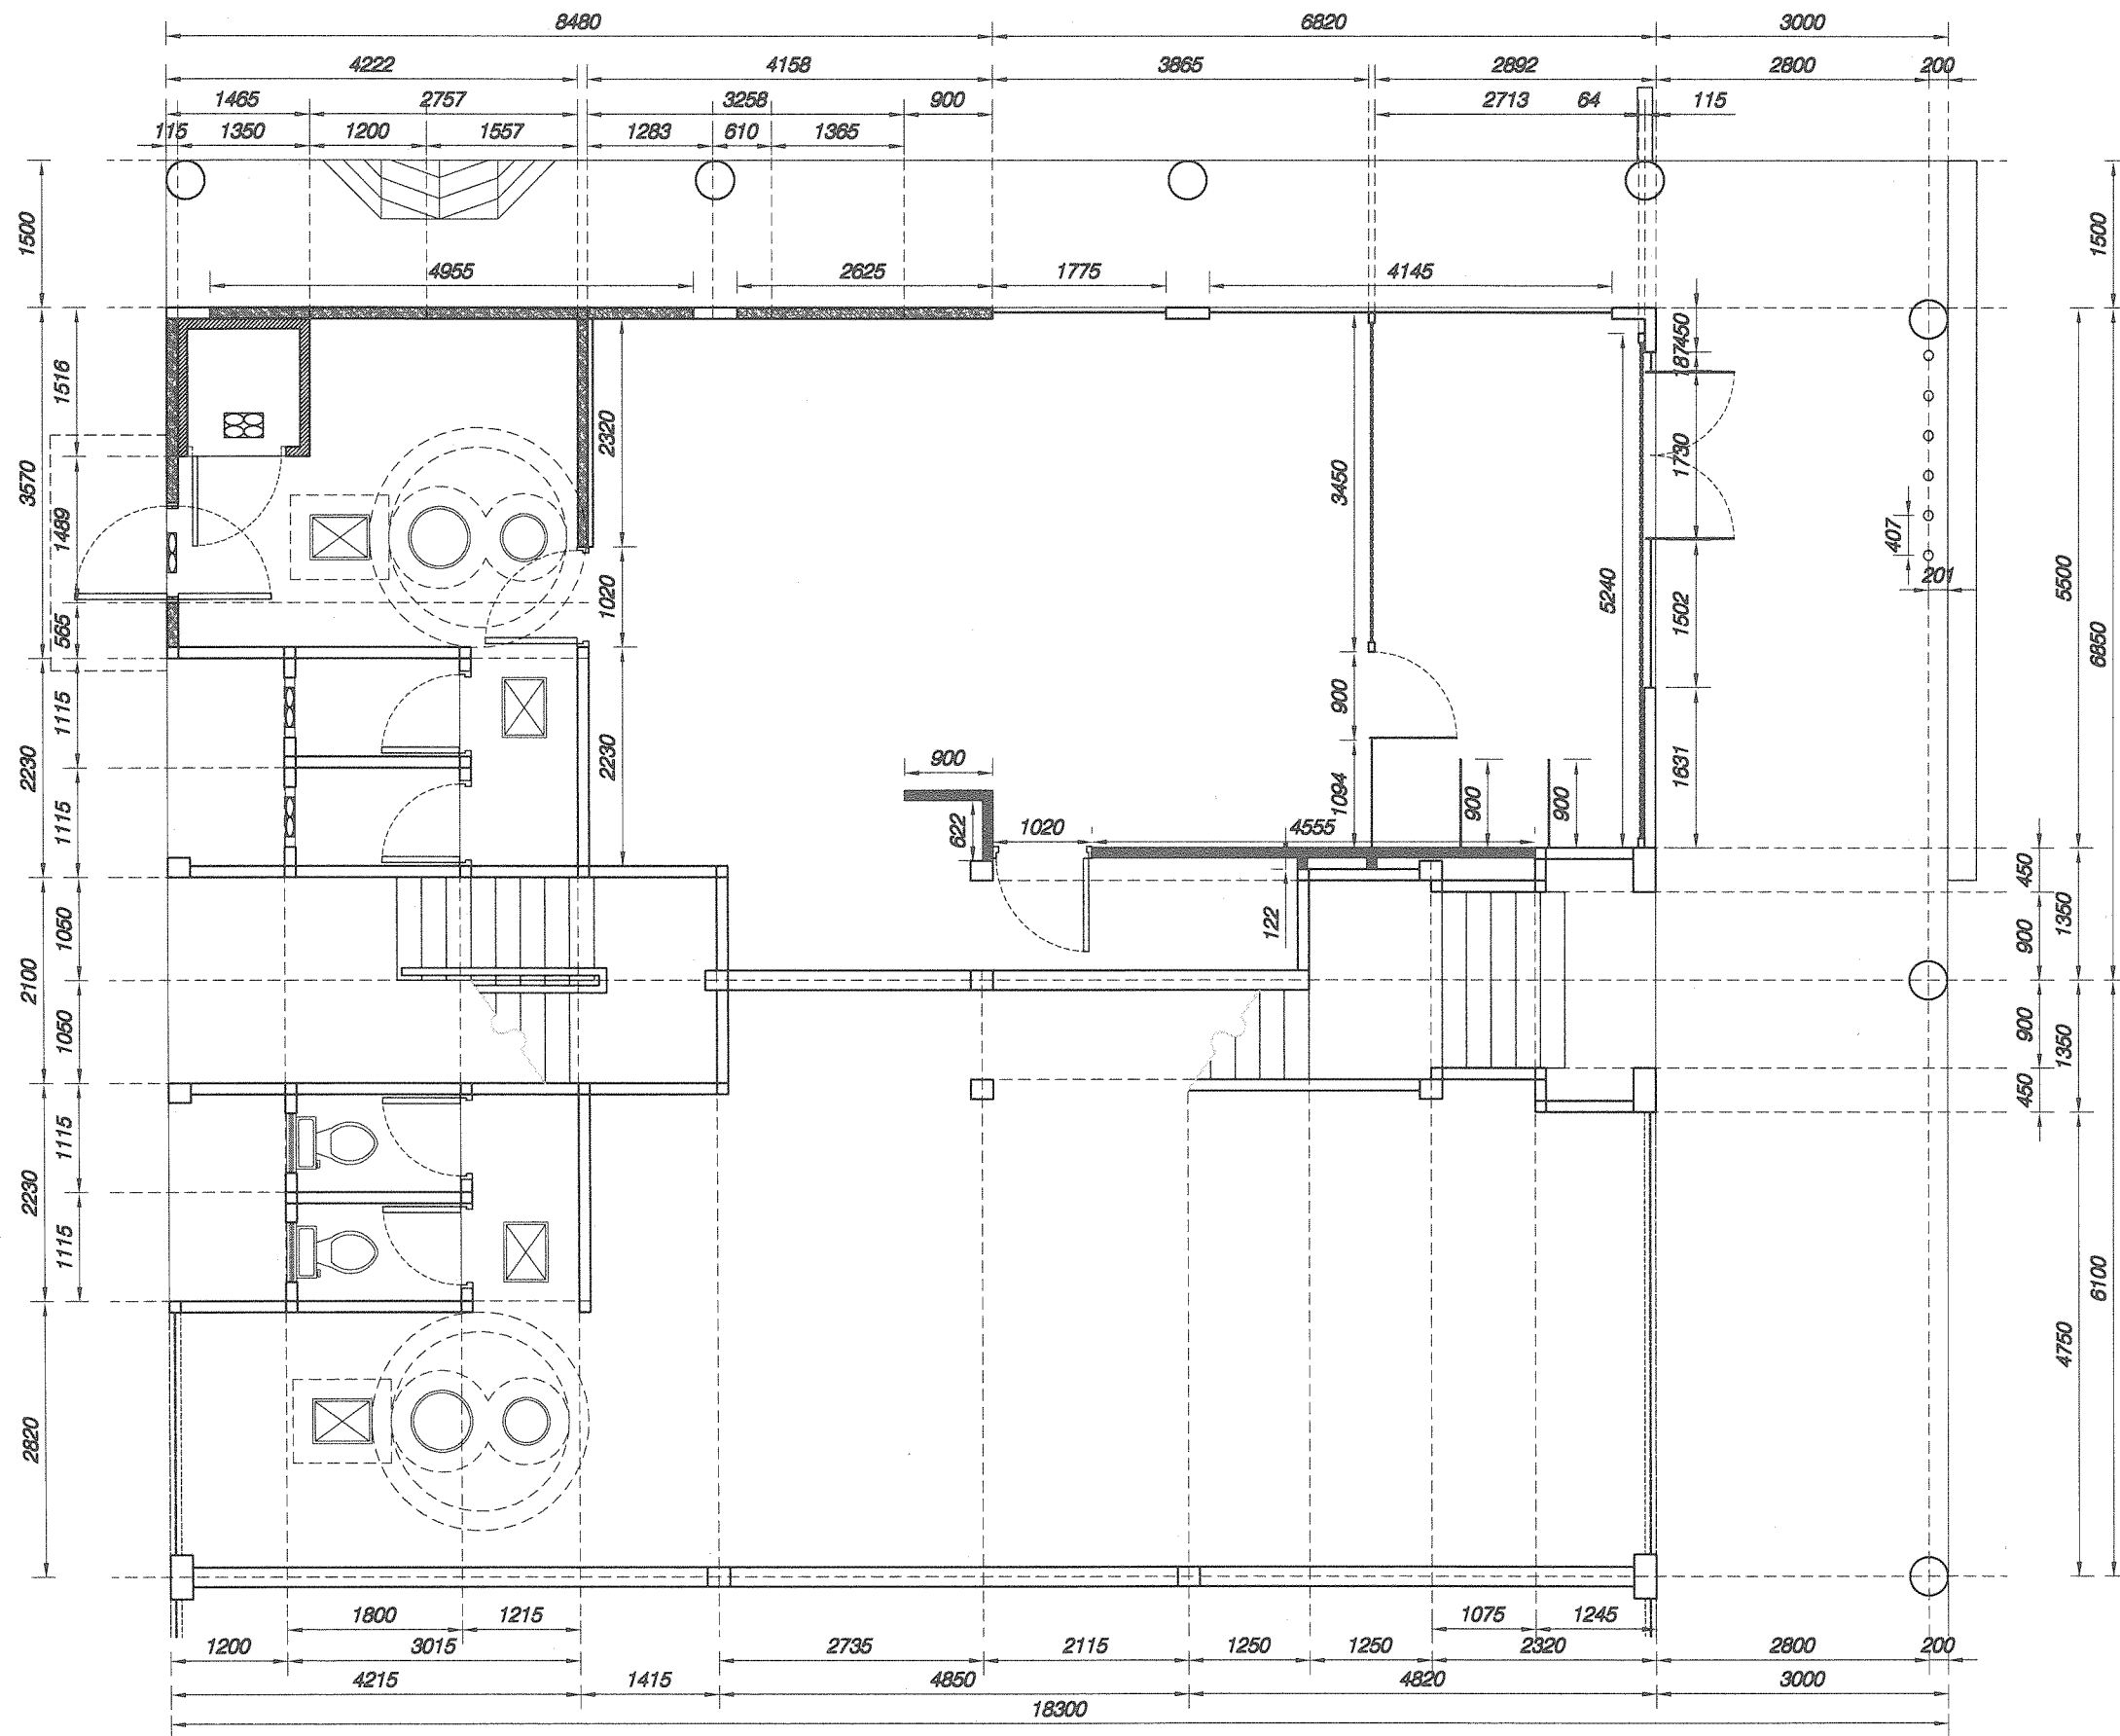

GENERAL SYMBOLS	
	BUILDING CORE AREA
	DENOTES NEW DRYWALL PARTITION
	DENOTES GLASS WALL PARTITION

PROJECT TITLE:
 PROPOSED INTERIOR FIT-OUT WORKS FOR
 BANK SIMPANAN NASIONAL AT GROUND FLOOR & FIRST FLOOR,
 LOT 625, KAPIT BAZAAR, JALAN SELIRIK, 96800 KAPIT, SARAWAK

DWG NO: BSN/IP/JPAK/FD/2020-03		DWG TITLE: GROUND FLOOR SETTING OUT PLAN	
DATE: 170321	DRAWN BY: AYIE	ISSUE: 2	BRANCH NAME: KAPIT, SARAWAK
JOB NO: 21/01	SCALE: 1:75	DWG NO: S02-G-001	

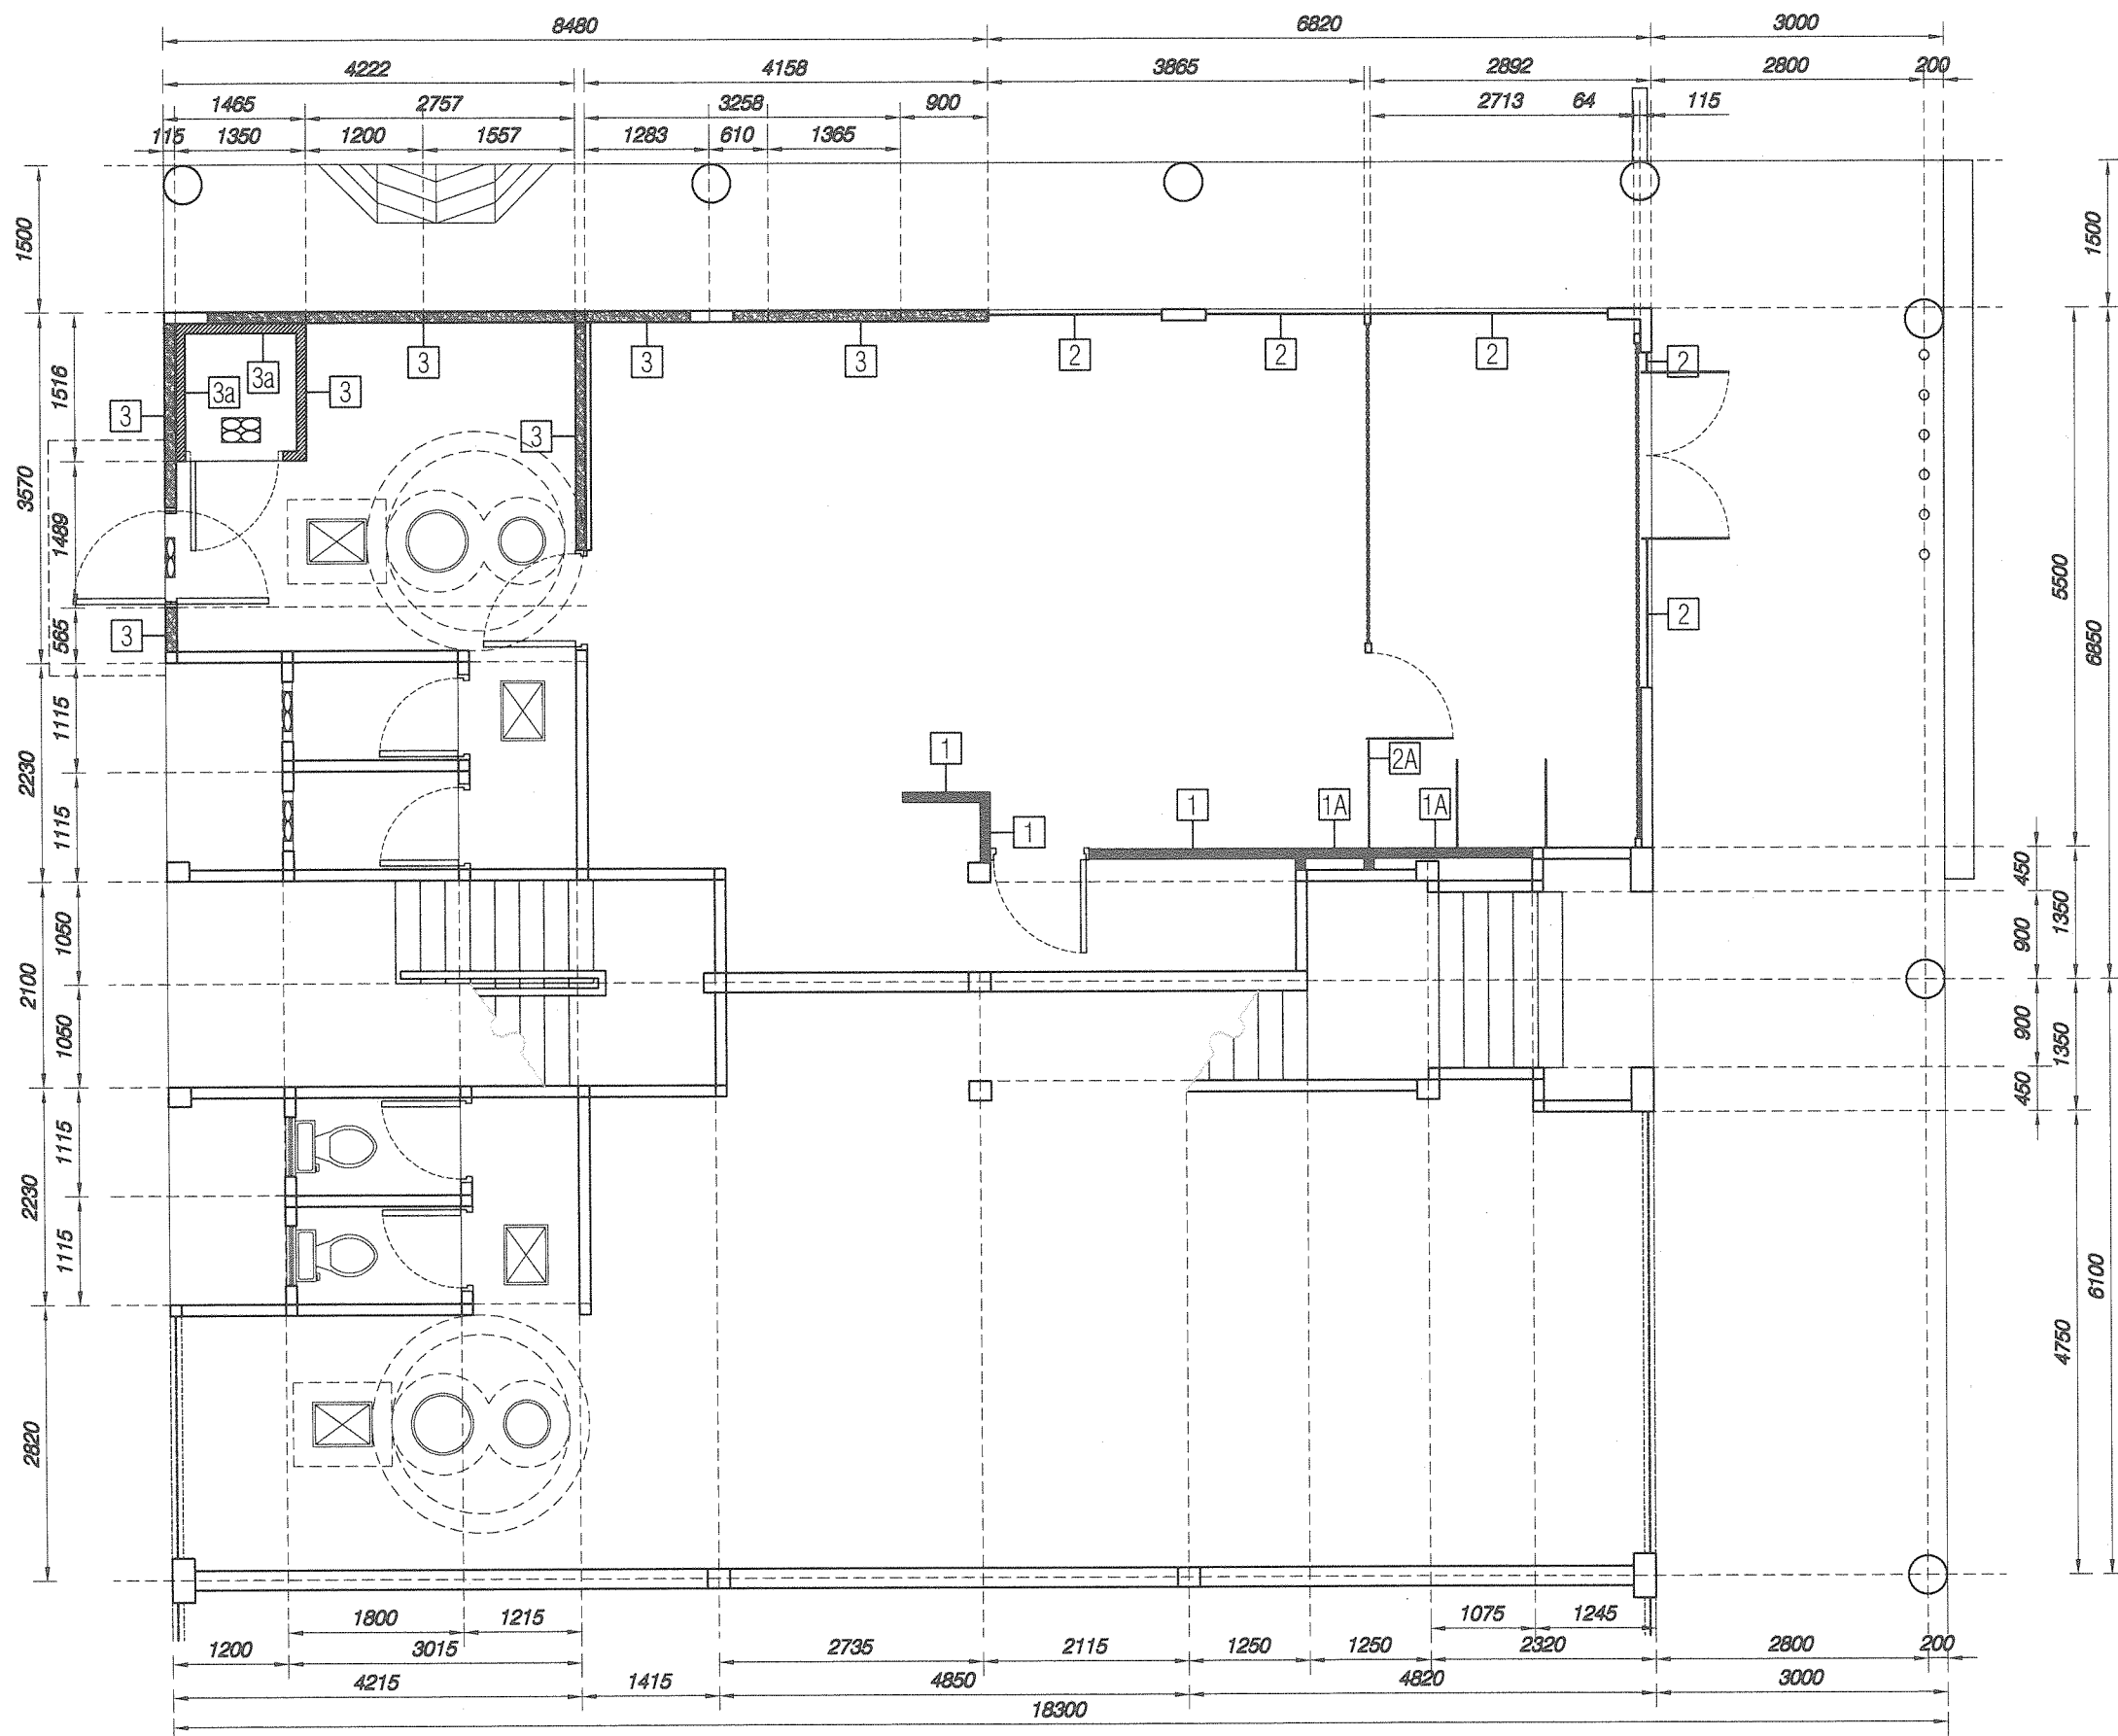


GENERAL SYMBOLS	
	BUILDING CORE AREA
	DENOTES NEW DRYWALL PARTITION
	DENOTES GLASS WALL PARTITION
	DENOTES PARTITION TYPE

PARTITION TYPE	
TYPE	DESCRIPTION
PX	EXISTING PARTITION Existing Partition to make good and touch-up or refurbishment necessary.
EW	EXISTING BRICKWALL Existing Brickwall to make good and touch-up or refurbishment necessary.
1	NORMAL PARTITION New full height 76mm thick 'Normal Partition' with 12.5mm thick 'Boral Plaster Board' both sides finished to underside of ceiling with 51mm metal stud held 600mm centers vertically c/v top and bottom track of partition.
1A	NORMAL PARTITION New full height 76mm thick 'Normal Partition' with 12.5mm thick 'Boral Plaster Board' single sided finished to underside of ceiling with 51mm metal stud held 600mm centers vertically c/v top and bottom track of partition.
1C	WET RESISTANT PARTITION New full height 76mm thick 'Wetstop Partition' with 12.5mm thick 'BORAL WETSTOP PLASTER BOARD' single sided finished and 12.5mm thick 'BORAL PLASTER BOARD' to underside of ceiling with 51mm metal stud held 600mm centers vertically c/v top and bottom track of partition c/v approved wet area membrane and borel wet area sealant w/ foam rod and tape bond breaker.
1E	NORMAL PARTITION New full height 76mm thick 'Normal Partition' with 12.5mm thick 'Boral Plaster Board' both sides finished to underside 2400mm height with 51mm metal stud held 600mm centers vertically c/v top and bottom track of partition.
1F	NORMAL PARTITION + GLASS PANEL New full height 76mm thick 'Normal Partition' with 12.5mm thick 'Boral Plaster Board' both sides finished to underside 1100mm height with 51mm metal stud held 600mm centers vertically c/v top and bottom track of partition with 12mm thick frameless glass panel up to ceiling height.
2	FRAMELESS GLASS PARTITION New 12mm thick 'Frameless Tempered Glass Partition' from floor to 2400mm height.
2A	FRAMELESS GLASS PARTITION New full height 12mm thick 'Frameless Tempered Glass Partition' from floor to ceiling height.
2B	FRAMELESS GLASS DIVIDER New 12mm thick 'Frameless Tempered Glass Divider' from floor to 1829mm height.
3	BRICKWALL New full height 150mm thick brick wall from floor until slab level with 600mm height waterproofing from floor.
3A	BRICKWALL WITH METAL SHEET New full height 150mm thick brick wall from floor until slab level with 600mm height waterproofing from floor with metal sheet clad.

PROJECT TITLE:
PROPOSED INTERIOR FIT-OUT WORKS FOR
BANK SIMPANAN NASIONAL AT GROUND FLOOR & FIRST FLOOR,
LOT 625, KAPIT BAZAAR, JALAN SELIRIK, 96800 KAPIT, SARAWAK

DWG NO: BSN/IP/JPAK/FD/2020-03	DWG TITLE: GROUND FLOOR PARTITION CODING PLAN
DATE: 170321	DRAWN BY: AYIE
JOB NO: 21/01	SCALE: 1 : 75
ISSUE: 2	BRANCH NAME: KAPIT, SARAWAK
	DWG NO: S02-G-002

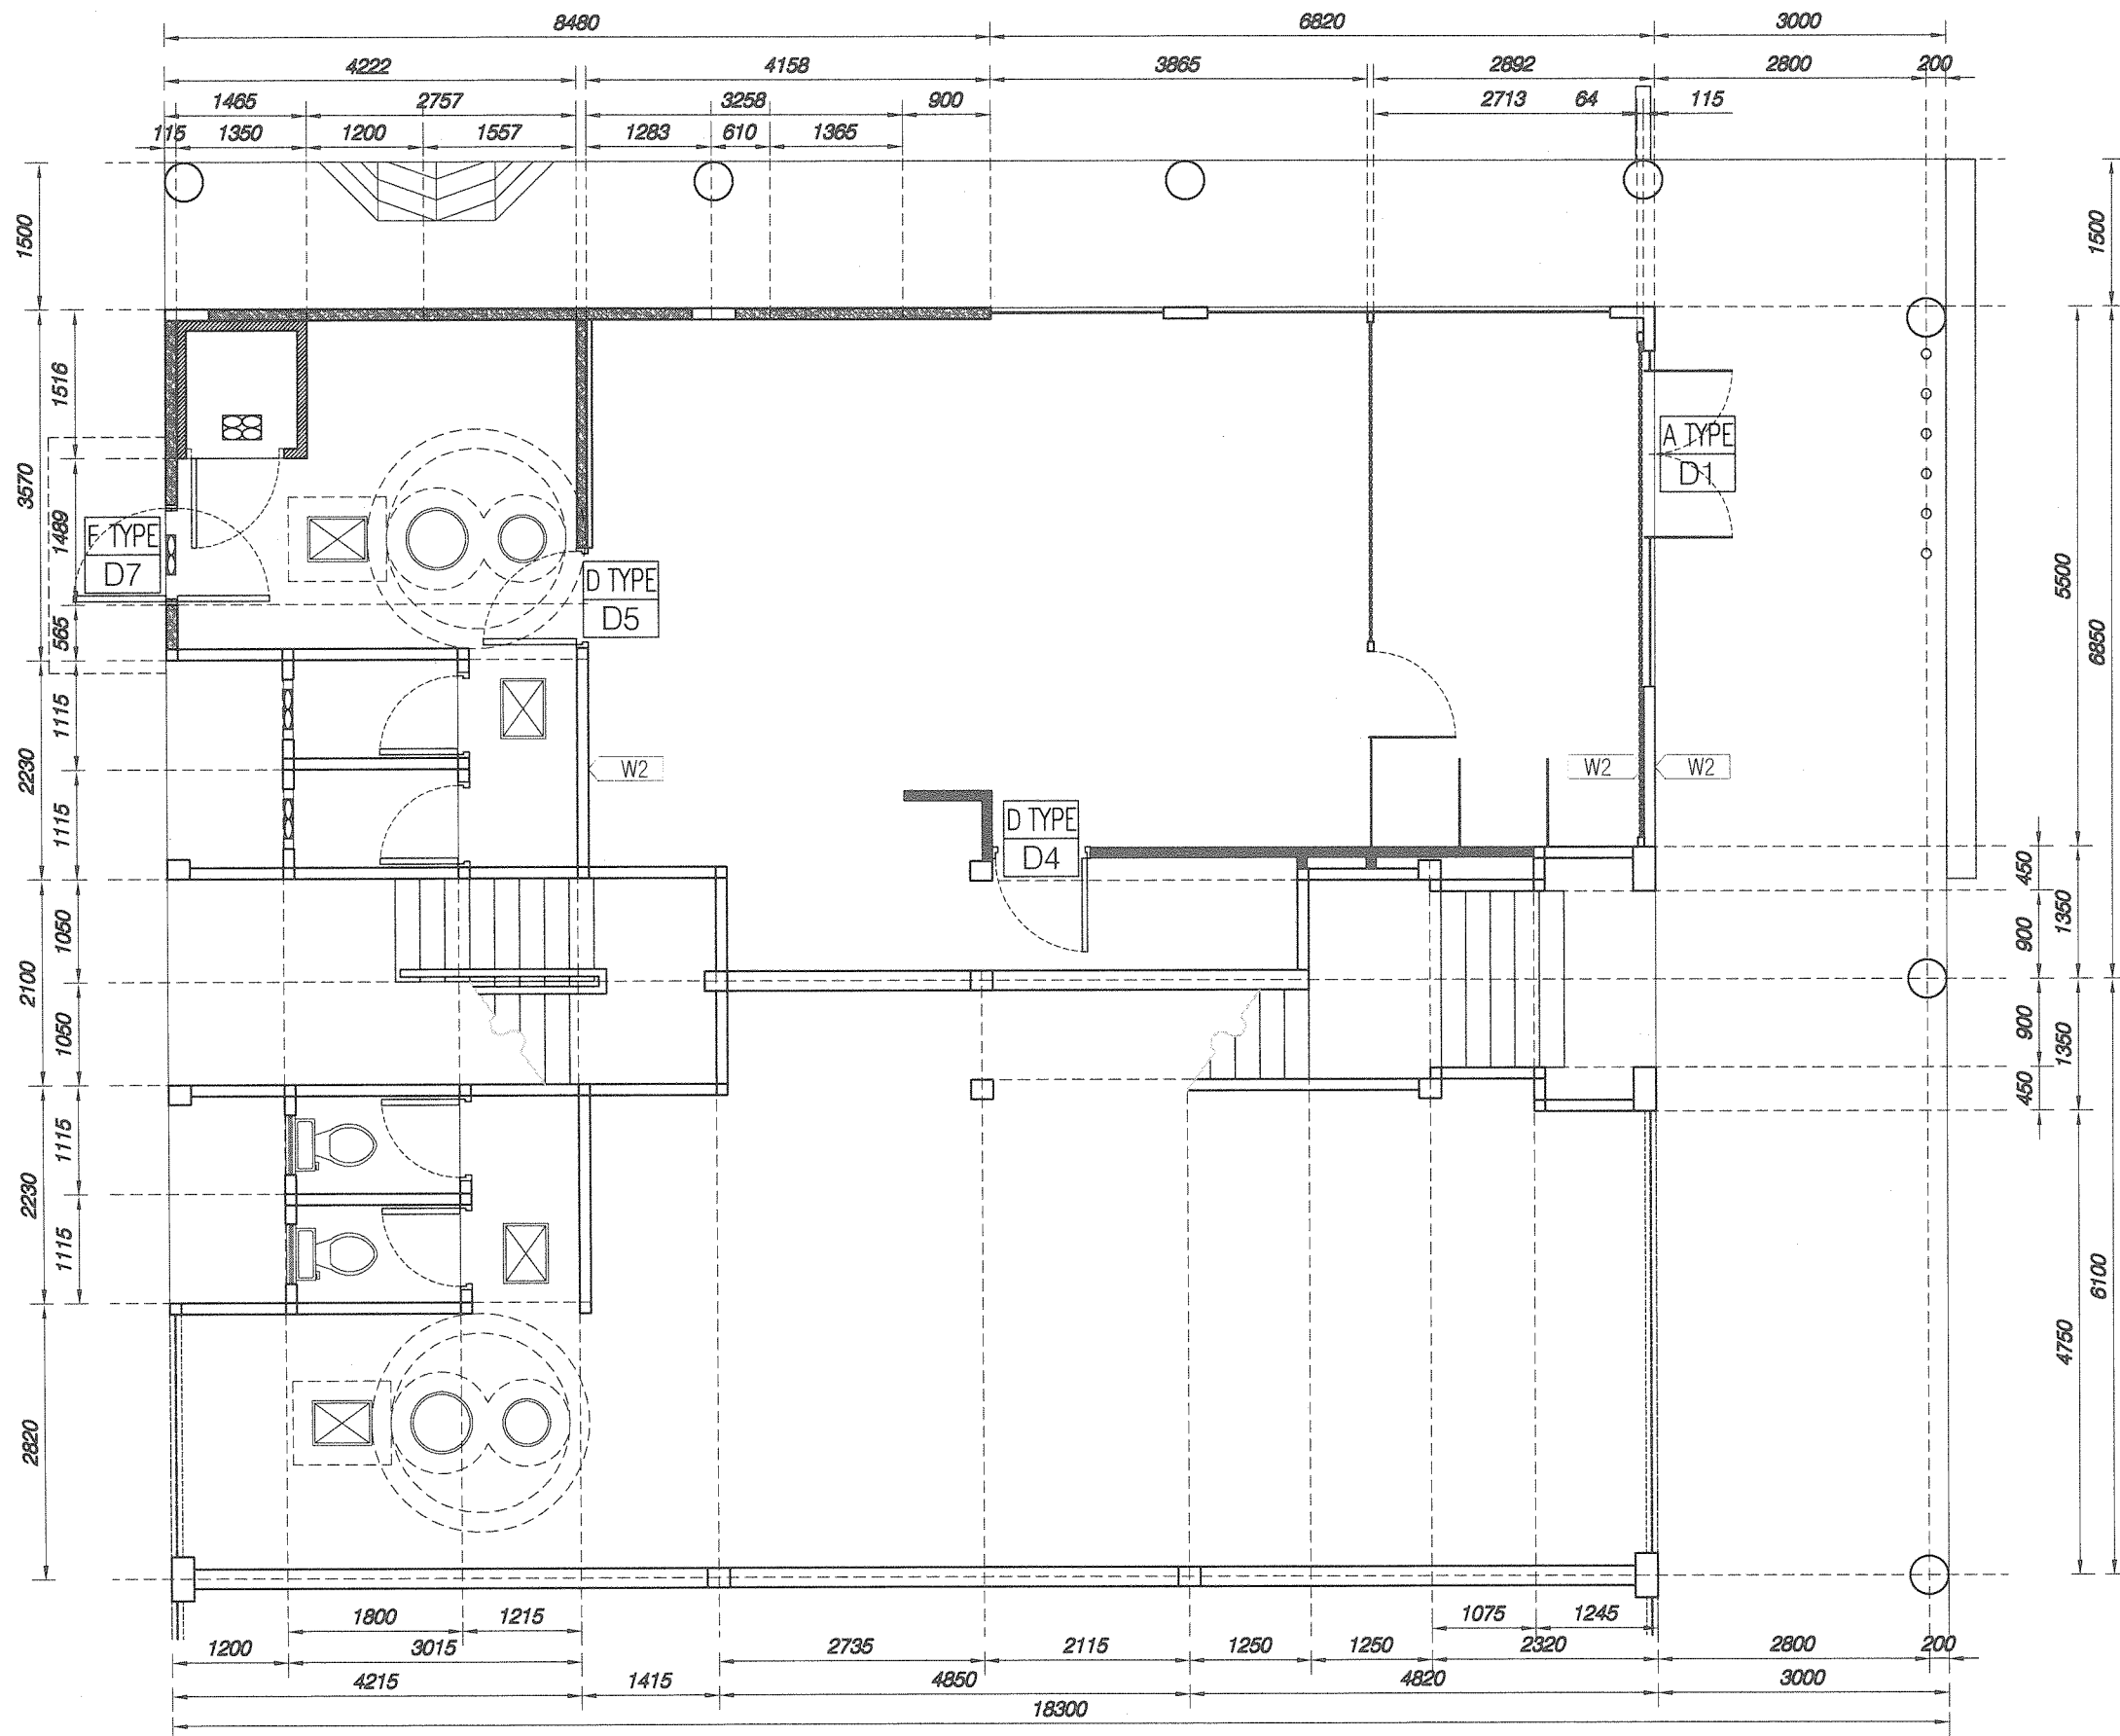

GENERAL SYMBOLS	
	BUILDING CORE AREA
D TYPE	DENOTES DOOR IDENTITY & NUMBER
D5	DENOTES DOOR TYPE For detailed description of door, refer to Door Schedule
XX	DENOTES WALL / PARTITION FINISHES


DOOR LEGEND	
TYPE	DESCRIPTION
A	DOUBLE LEAF FRAMELESS GLASS DOOR -refer door details
B	SINGLE LEAF FRAMELESS GLASS DOOR -refer door details
C	SINGLE LEAF FRAMELESS GLASS DOOR -refer door details
D	SINGLE LEAF SOLID CORE DOOR -refer door details
E	SINGLE LEAF HOLLOW CORE DOOR -refer door details
Ea	SINGLE LEAF HOLLOW CORE DOOR w/ VIEWING PANEL -refer door details
F	SINGLE LEAF SOLID CORE DOOR + METAL GRILL CLADDED WITH STEEL SHEET -refer door details
Fa	SINGLE LEAF HOLLOW CORE DOOR + METAL GRILL -refer door details
G	SINGLE LEAF SOLID CORE DOOR + SLIDING METAL GRILL -refer door details
H	SINGLE LEAF PVC FLUSH DOOR -refer door details
J	SLIDING HOLLOW CORE DOOR -refer door details
RS A	SELECTED MOTORIZED ROLLER SHUTTER
SS	SLIDING DOOR SHOWER SCREEN 10MM THK TEMPERED GLASS

PARTITION FINISHES	
TYPE	DESCRIPTION
W1	Selected Emulsion Paint finish (*WHITE) -refer finishes schedule and detail
W2	Selected Emulsion Paint finish (*TEAL) -refer finishes schedule and detail
W3	Selected 300 X 300 Homogenous Wall Tile -refer finishes schedule and detail

NOTE :
 - All wall / partitions which not specified in plan to be applied with general paint finish 'W1' or refer to joinery plan.

PROJECT TITLE:
 PROPOSED INTERIOR FIT-OUT WORKS FOR
 BANK SIMPANAN NASIONAL AT GROUND FLOOR & FIRST FLOOR,
 LOT 625, KAPIT BAZAAR, JALAN SELIRIK, 96800 KAPIT, SARAWAK

DWG NO: BSN/IP/JPAK/FD/2020-03	DWG TITLE: GROUND FLOOR WALL FINISHES & DOOR CODING PLAN
DATE: 170321	DRAWN BY: AYIE
JOB NO: 21/01	SCALE: 1 : 75
ISSUE: 2	BRANCH NAME: KAPIT, SARAWAK
	DWG NO: S02-G-004

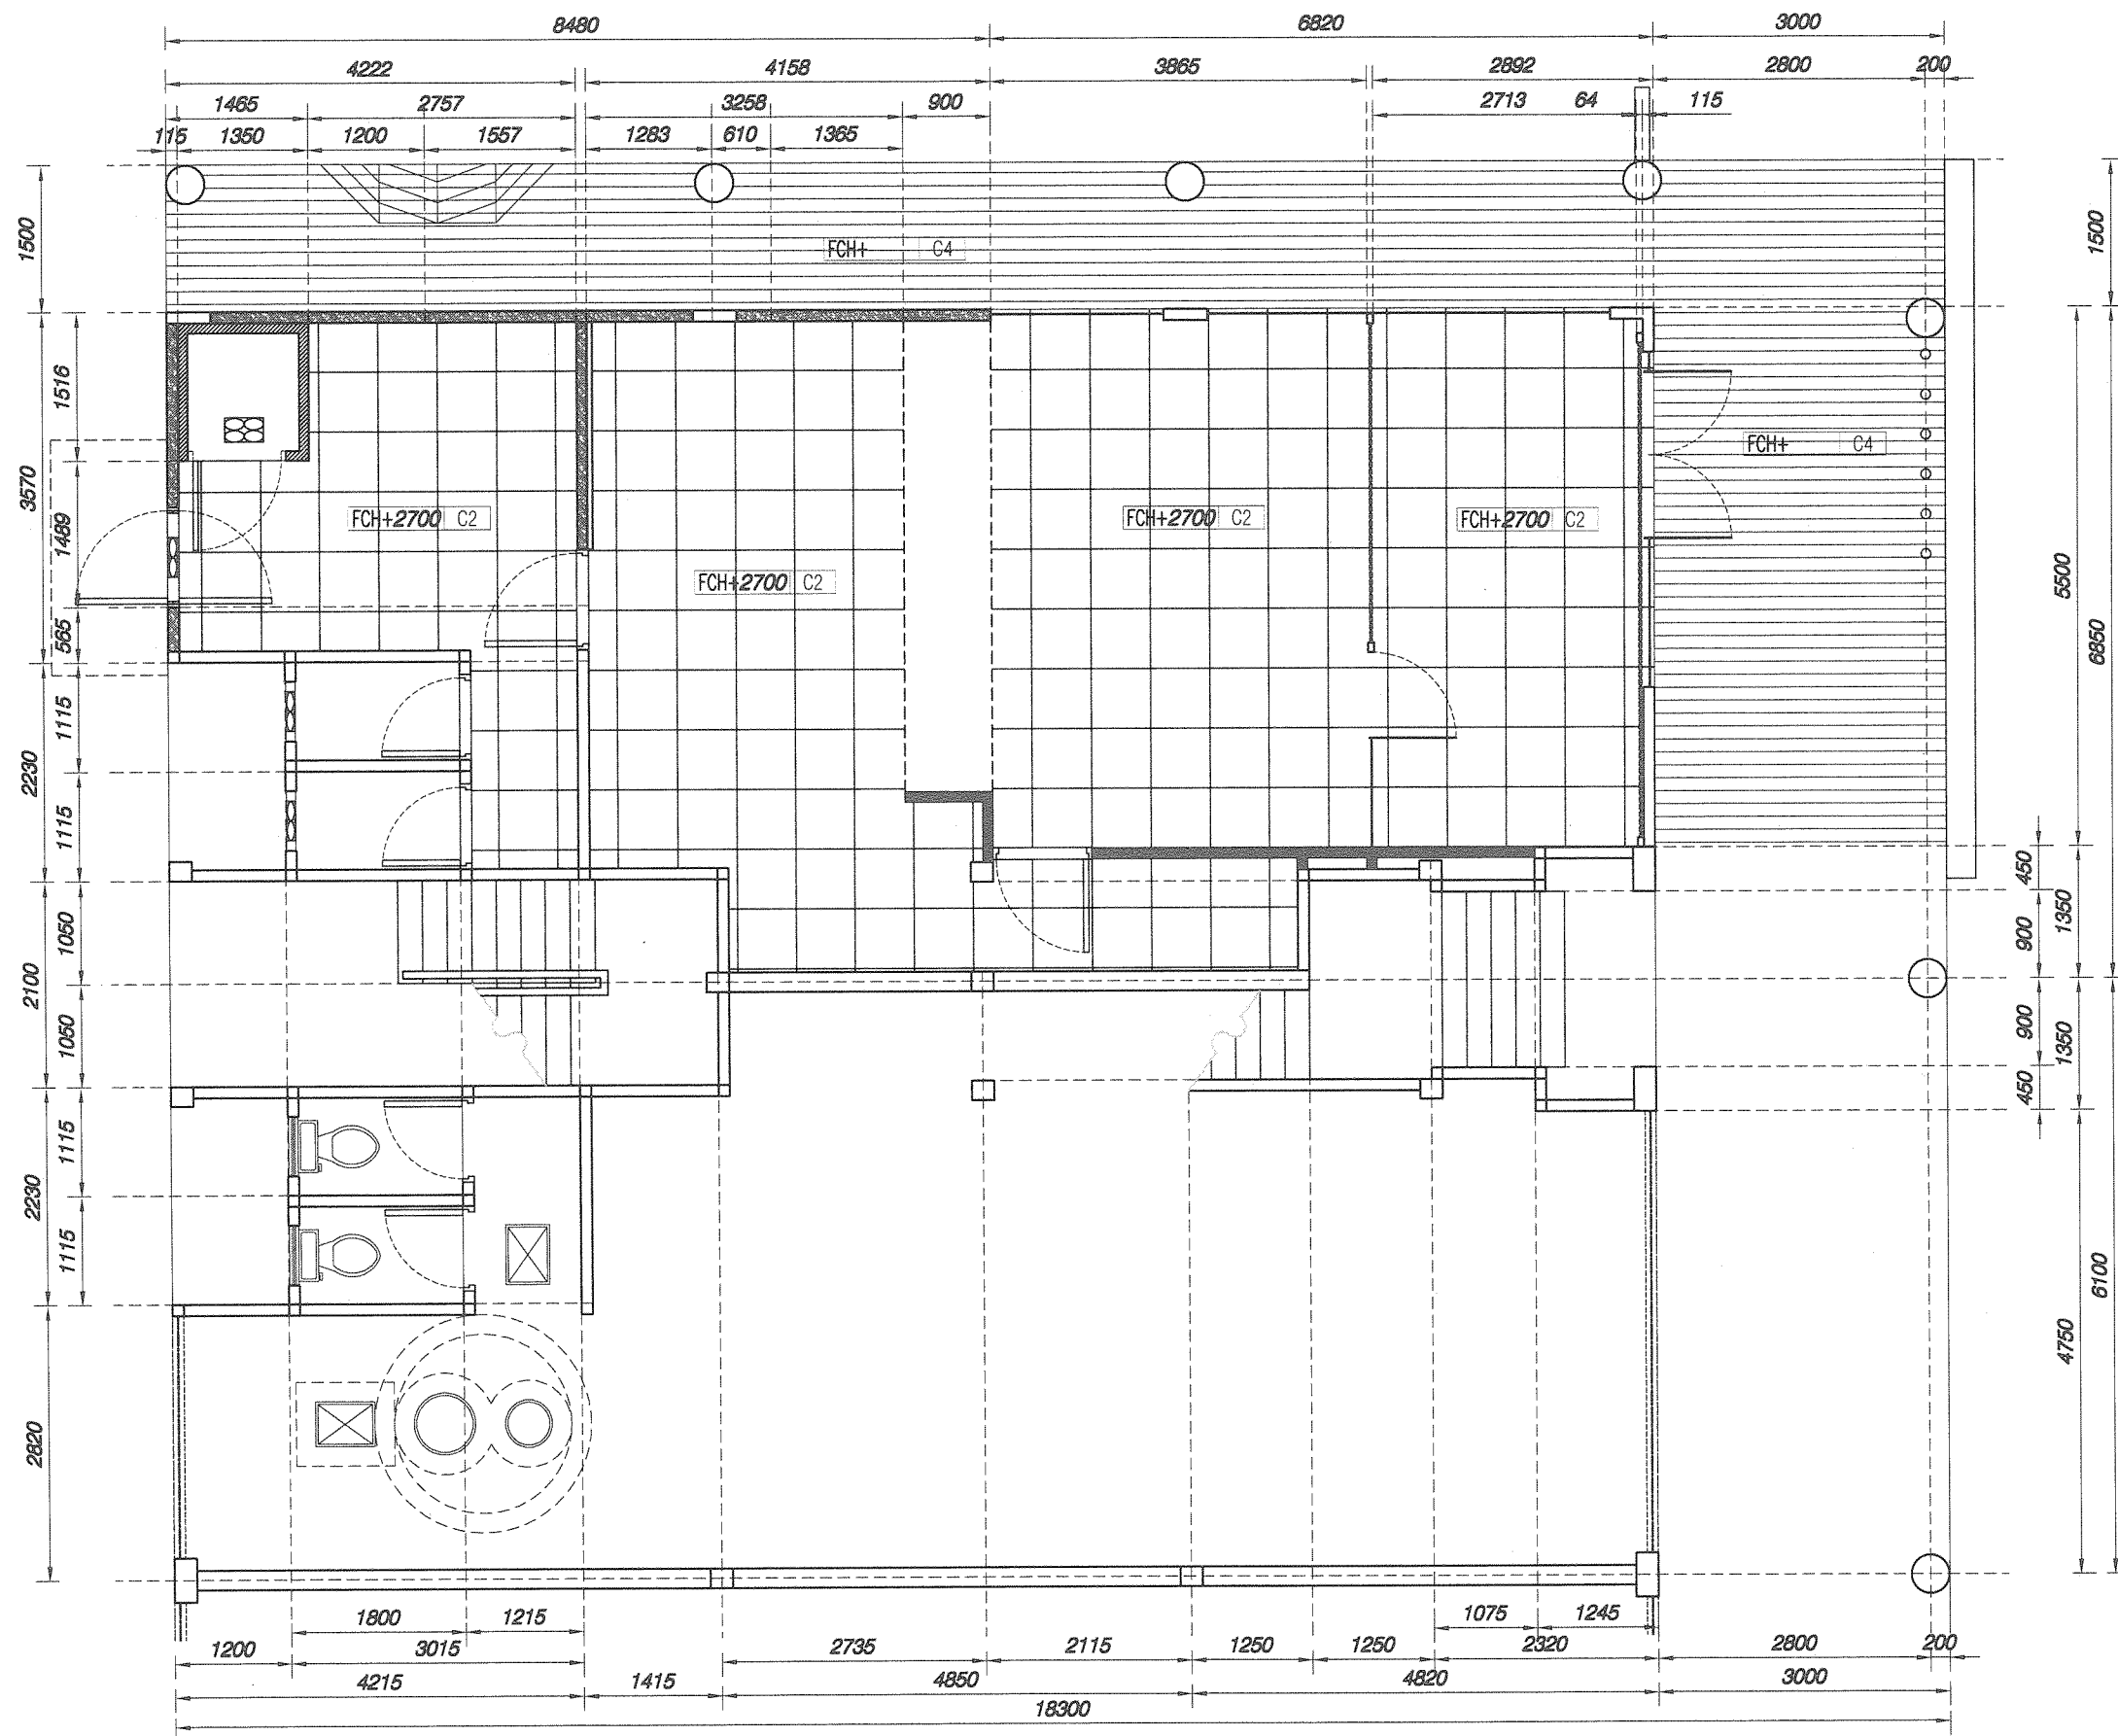


GENERAL SYMBOLS	
BUILDING CORE AREA	
	DENOTES CEILING HEIGHT
	DENOTES CEILING TYPE + FINISHES For detailed description of ceiling, refer ceiling section and details
FCH+2700	C1

CEILING TYPE + FINISHES	
TYPE	DESCRIPTION
EX	EXISTING CEILING -Finishes Specification by others
C1	NEW FIBROUS PLASTER BOARD CEILING IN SELECTED WHITE PAINT FINISH -refer ID Specification
C2	NEW 2' X 2' CEILING TILES -refer ID Specification
C3	BARE CEILING TO MAKE GOOD AND PAINTED -refer ID Specification
C4	Selected Metal Ceiling HUNTER DOUGLAS-150F Colour : Limestone Natural 7080 (gray)

NOTE :
- Finishes specification refer to 'Finishes Schedule' Contractor to provide sample to ID for approval prior to construction.

PROJECT TITLE:
PROPOSED INTERIOR FIT-OUT WORKS FOR
BANK SIMPANAN NASIONAL AT GROUND FLOOR & FIRST FLOOR,
LOT 625, KAPIT BAZAAR, JALAN SELIRIK, 96800 KAPIT, SARAWAK

DWG NO: BSN/IP/JPAK/FD/2020-03	DWG TITLE: GROUND FLOOR REFLECTED CEILING PLAN
DATE: 170321	DRAWN BY: AYIE
JOB NO: 21/01	SCALE: 1 : 75
ISSUE: 2	BRANCH NAME: KAPIT, SARAWAK
	DWG NO: S03-G-001

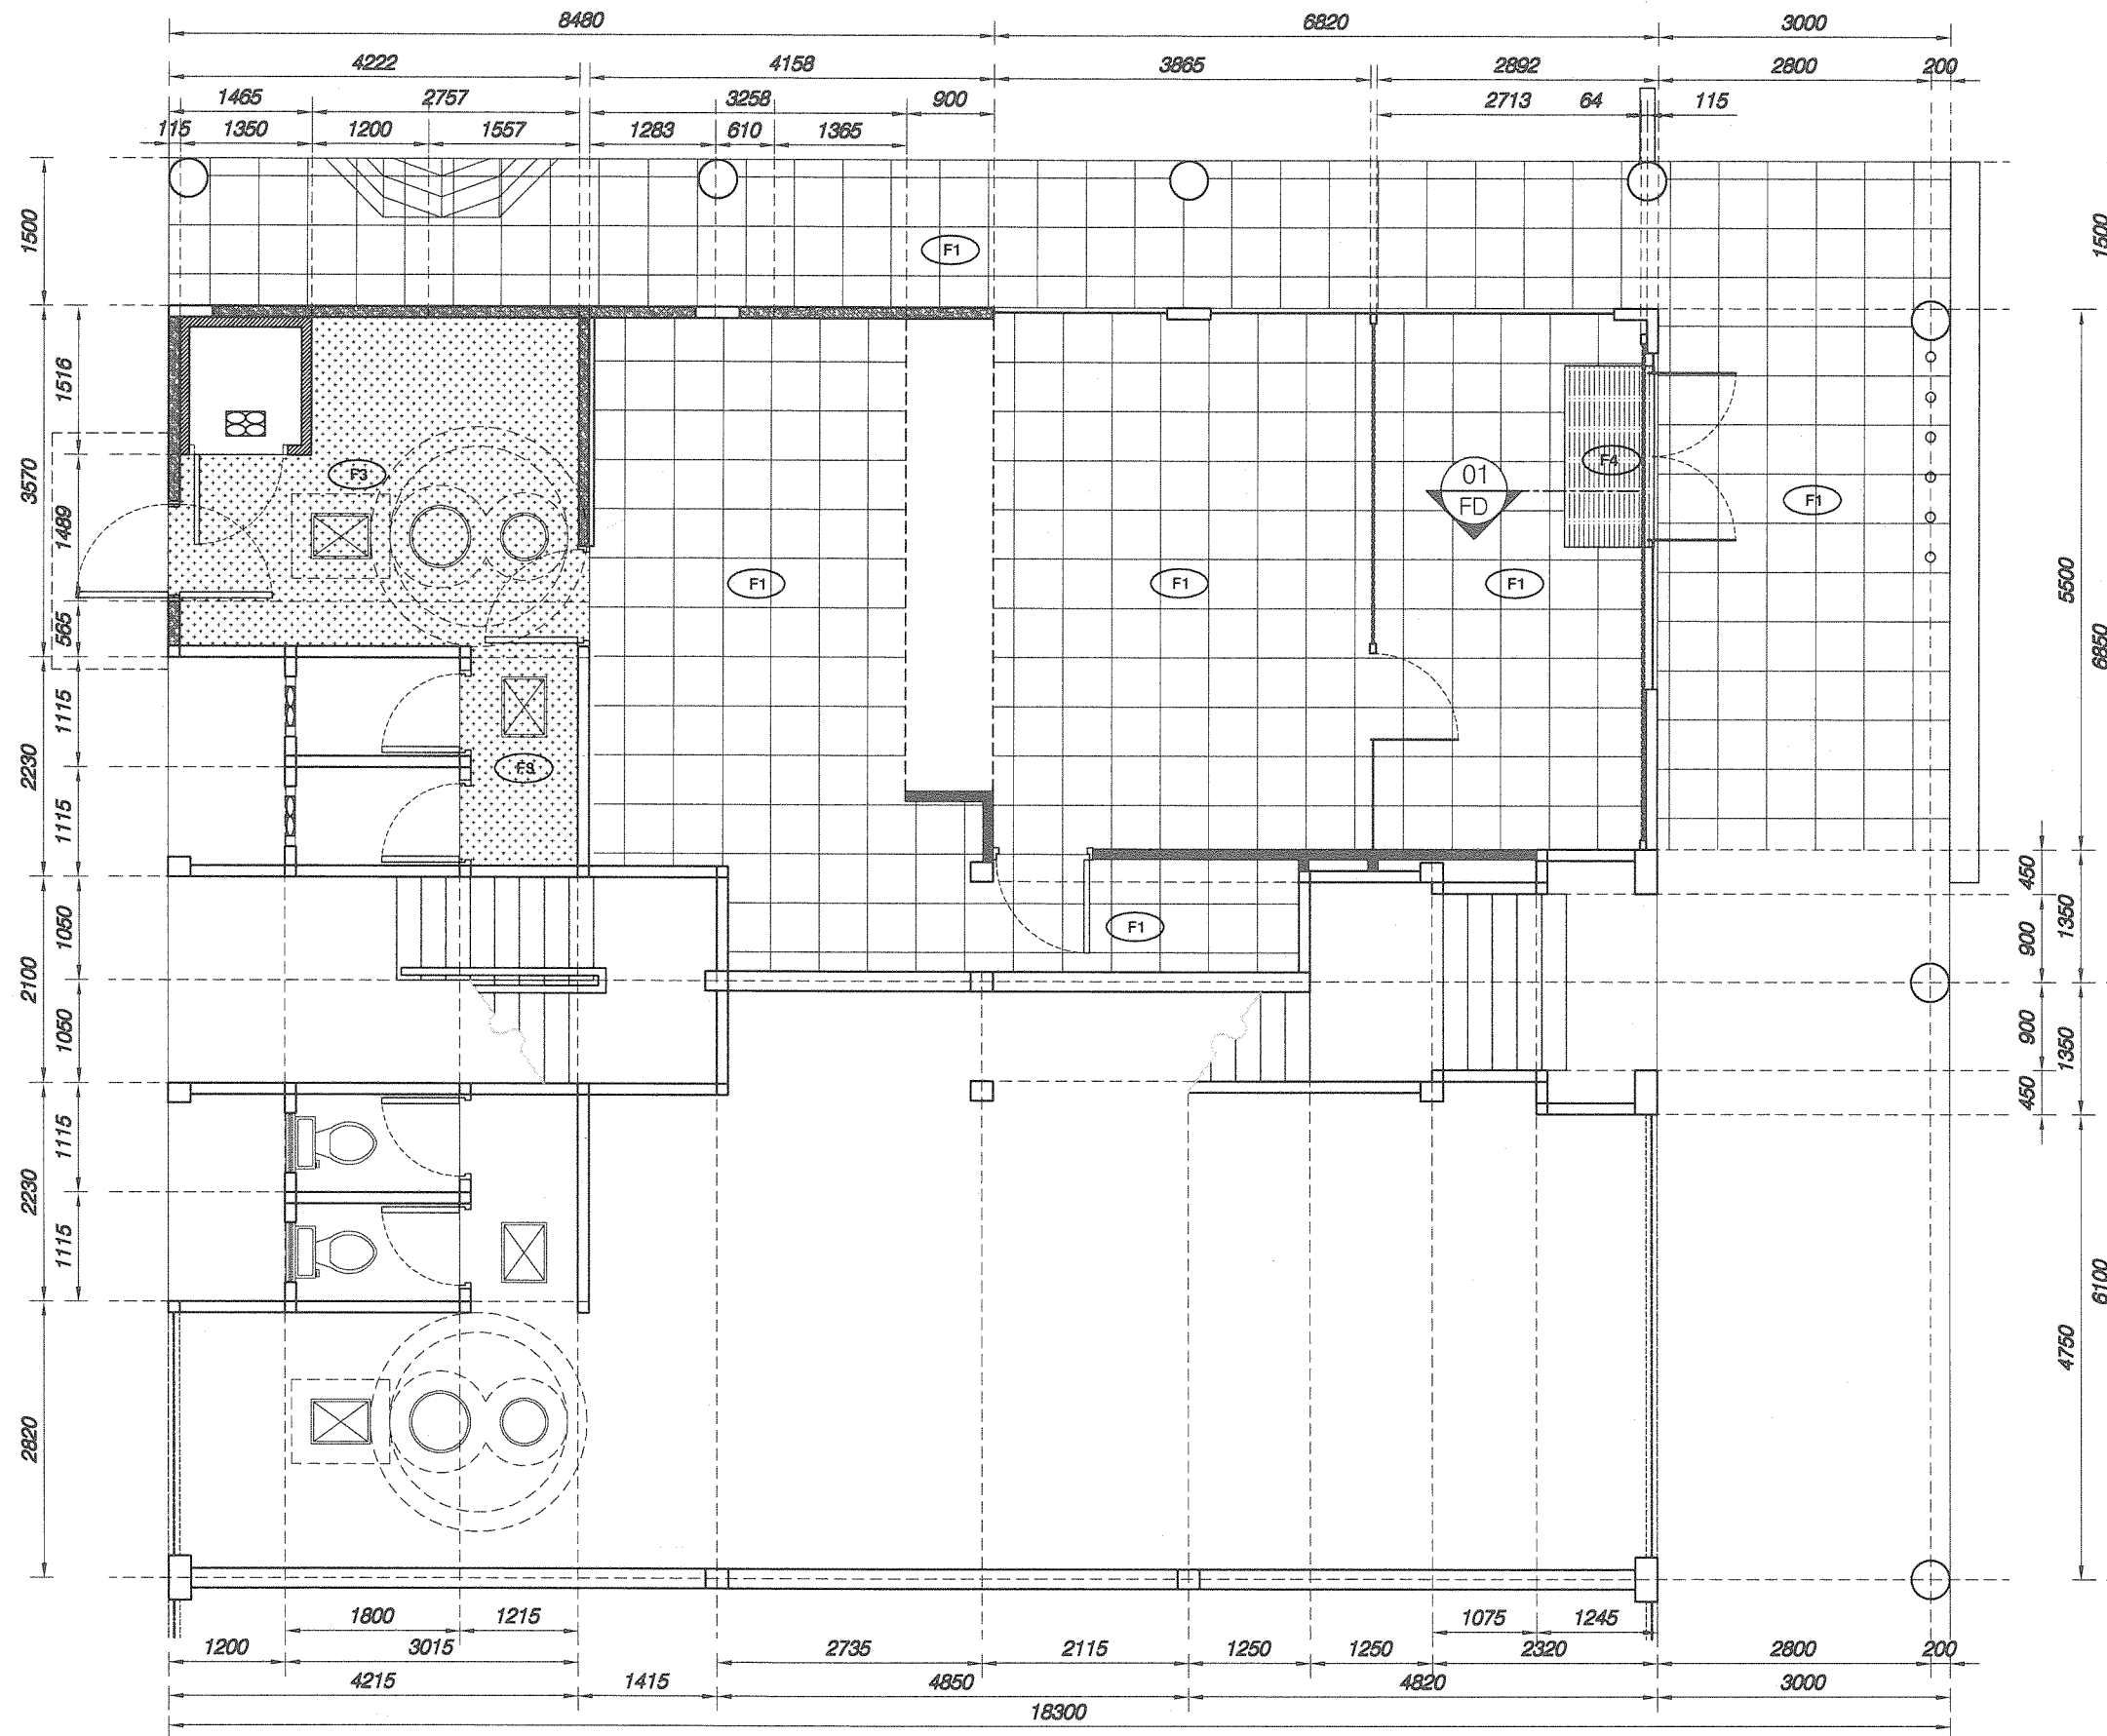


GENERAL SYMBOLS	
	BUILDING CORE AREA
	DENOTES FLOOR FINISHES For detailed description of floor, refer floor section, details & finishes schedule

FLOOR FINISHES	
TYPE	DESCRIPTION
EX	EXISTING FLOOR -Finishes Specification by others
F1	SELECTED HOMOGENOUS TILE FLOORING GREY - COLOR (MATT FINISHES) -refer finishes schedule
F1a	SELECTED HOMOGENOUS TILE FLOORING GREY - COLOR (ROUGH FINISHES) -refer finishes schedule
F2	SELECTED HOMOGENOUS TILE FLOORING TIMBER GRAIN - COLOR (MATT FINISHES) -refer finishes schedule
F3	SELECTED HOMOGENOUS TILE FLOORING GREY - COLOR (MATT FINISHES)
F4	SELECTED 3M SUNKEN FLOOR MAT -refer finishes schedule
F5	SELECTED CARPET TILES

NOTE :
- All the above finishes specifications refer to 'I.D Floor Finishes Schedule' & floor termination details refer to 'Typical Floor Details' drawing.

PROJECT TITLE:
PROPOSED INTERIOR FIT-OUT WORKS FOR
BANK SIMPANAN NASIONAL AT GROUND FLOOR & FIRST FLOOR,
LOT 625, KAPIT BAZAAR, JALAN SELIRIK, 96800 KAPIT, SARAWAK

BSN/IP/JPAK/FD/2020-03		DWG TITLE: GROUND FLOOR FLOOR FINISHES CODING PLAN	
BRN NO: 170321	DRAWN BY: AYIE	ISSUE: 2	BRANCH NAME: KAPIT, SARAWAK
JOB NO: 21/01	SCALE: 1 : 75	DWG NO: S04-6-001	

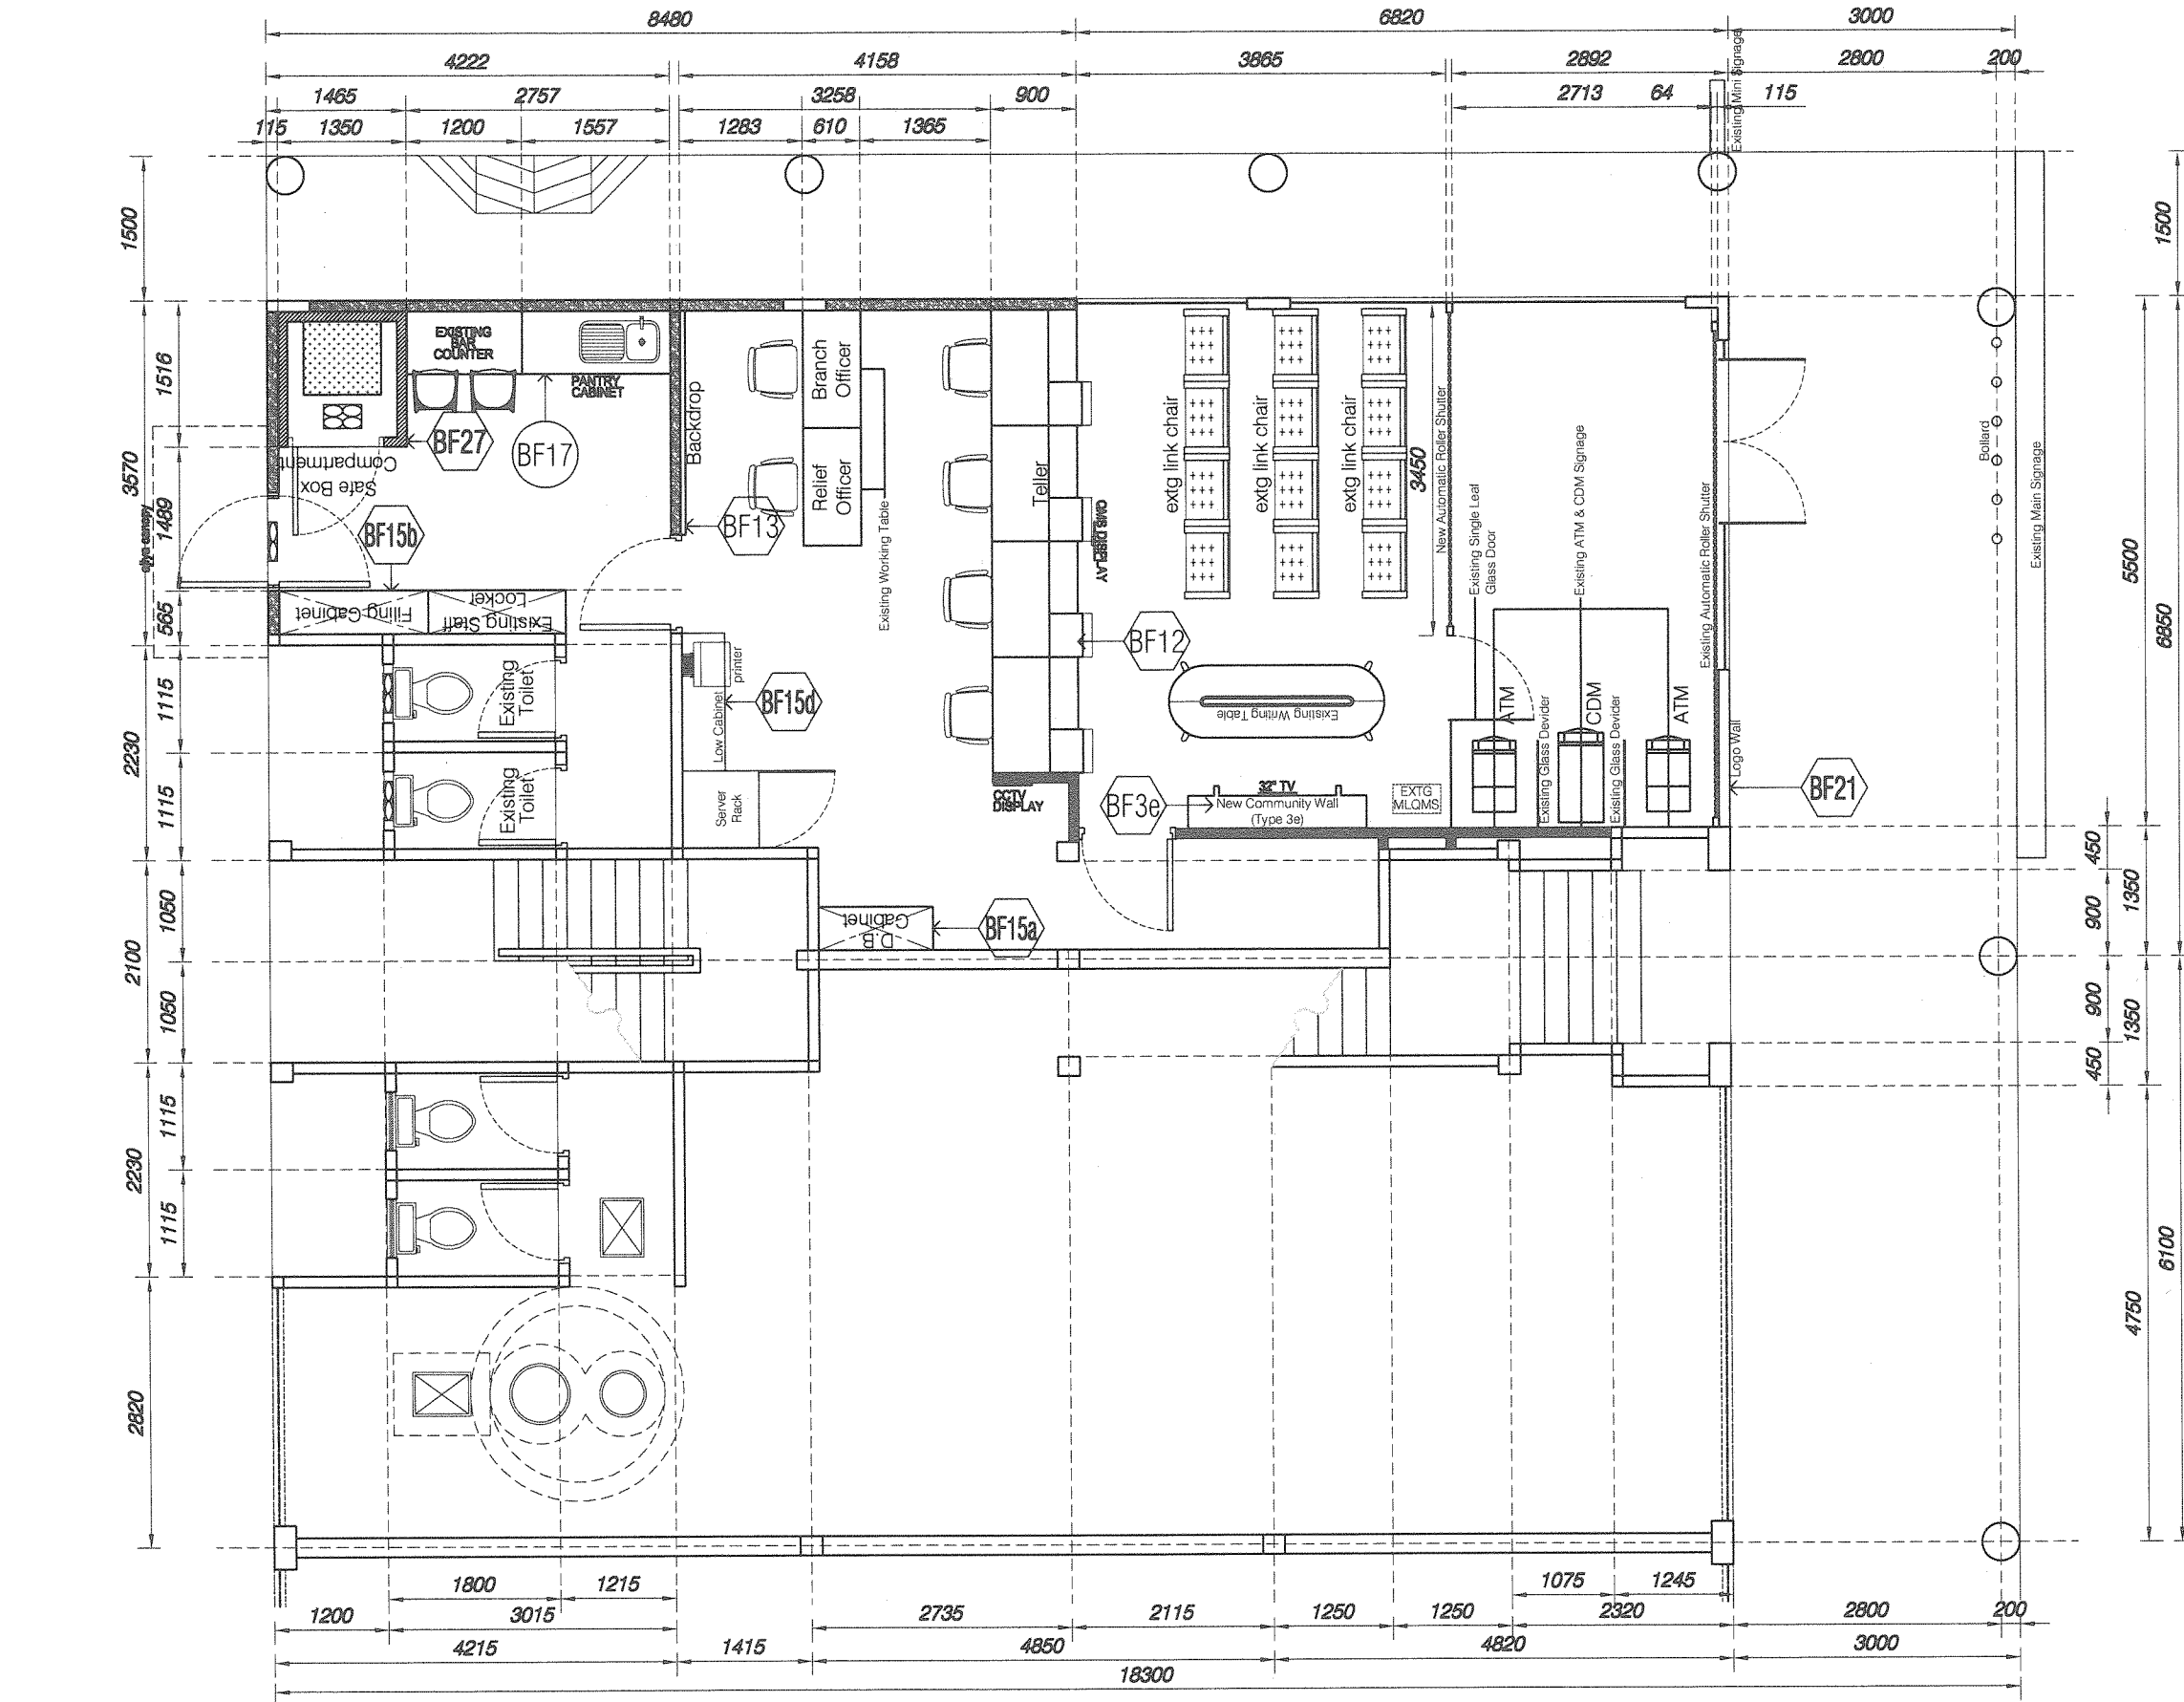


GENERAL SYMBOLS	
	BUILDING CORE AREA

JOINERY CODING PLAN	
TYPE	DESCRIPTION
BF3e	COMMUNITY WALL
BF4c	COMMUNITY FEATURE WALL
BF5	BAR TABLE
BF6	DISTRIBUTION DESK
BF10	SELF SERVICE BANKING
BF12	TELLER COUNTER
BF13	BACKDROP
BF14	DESK - FOR BRANCH OFFICER AND RELIEF OFFICER
BF15a	DB CABINET
BF15b	FILING CABINET + WORKTOP
BF15c	LOW CABINET
BF16	BAR COUNTER
BF17	PANTRY CABINET
BF18	GRAPHIC WALL - HERO WALL
BF21	LOGO WALL
BF22	WORKTOP
BF25	WRITING COUNTER
BF26	QMS COMPARTMENT
BF27	SAFE BOX COMPARTMENT

NOTE :
 - Finishes specification refer to 'Finishes Schedule' Contractor to provide sample to ID for approval prior to construction.


PROJECT TITLE:
 PROPOSED INTERIOR FIT-OUT WORKS FOR
 BANK SIMPANAN NASIONAL AT GROUND FLOOR & FIRST FLOOR,
 LOT 625, KAPIT BAZAAR, JALAN SELIRIK, 96800 KAPIT, SARAWAK

FILE NO: BSN/IP/JPAK/FD/2020-03	DWG TITLE: GROUND FLOOR JOINERY CODING PLAN
DATE: 170321	DRAWN BY: AYIE
JOB NO: 21/01	SCALE: 1 : 75
ISSUE: 2	BRANCH NAME: KAPIT, SARAWAK
	DWG NO: S05-G-002

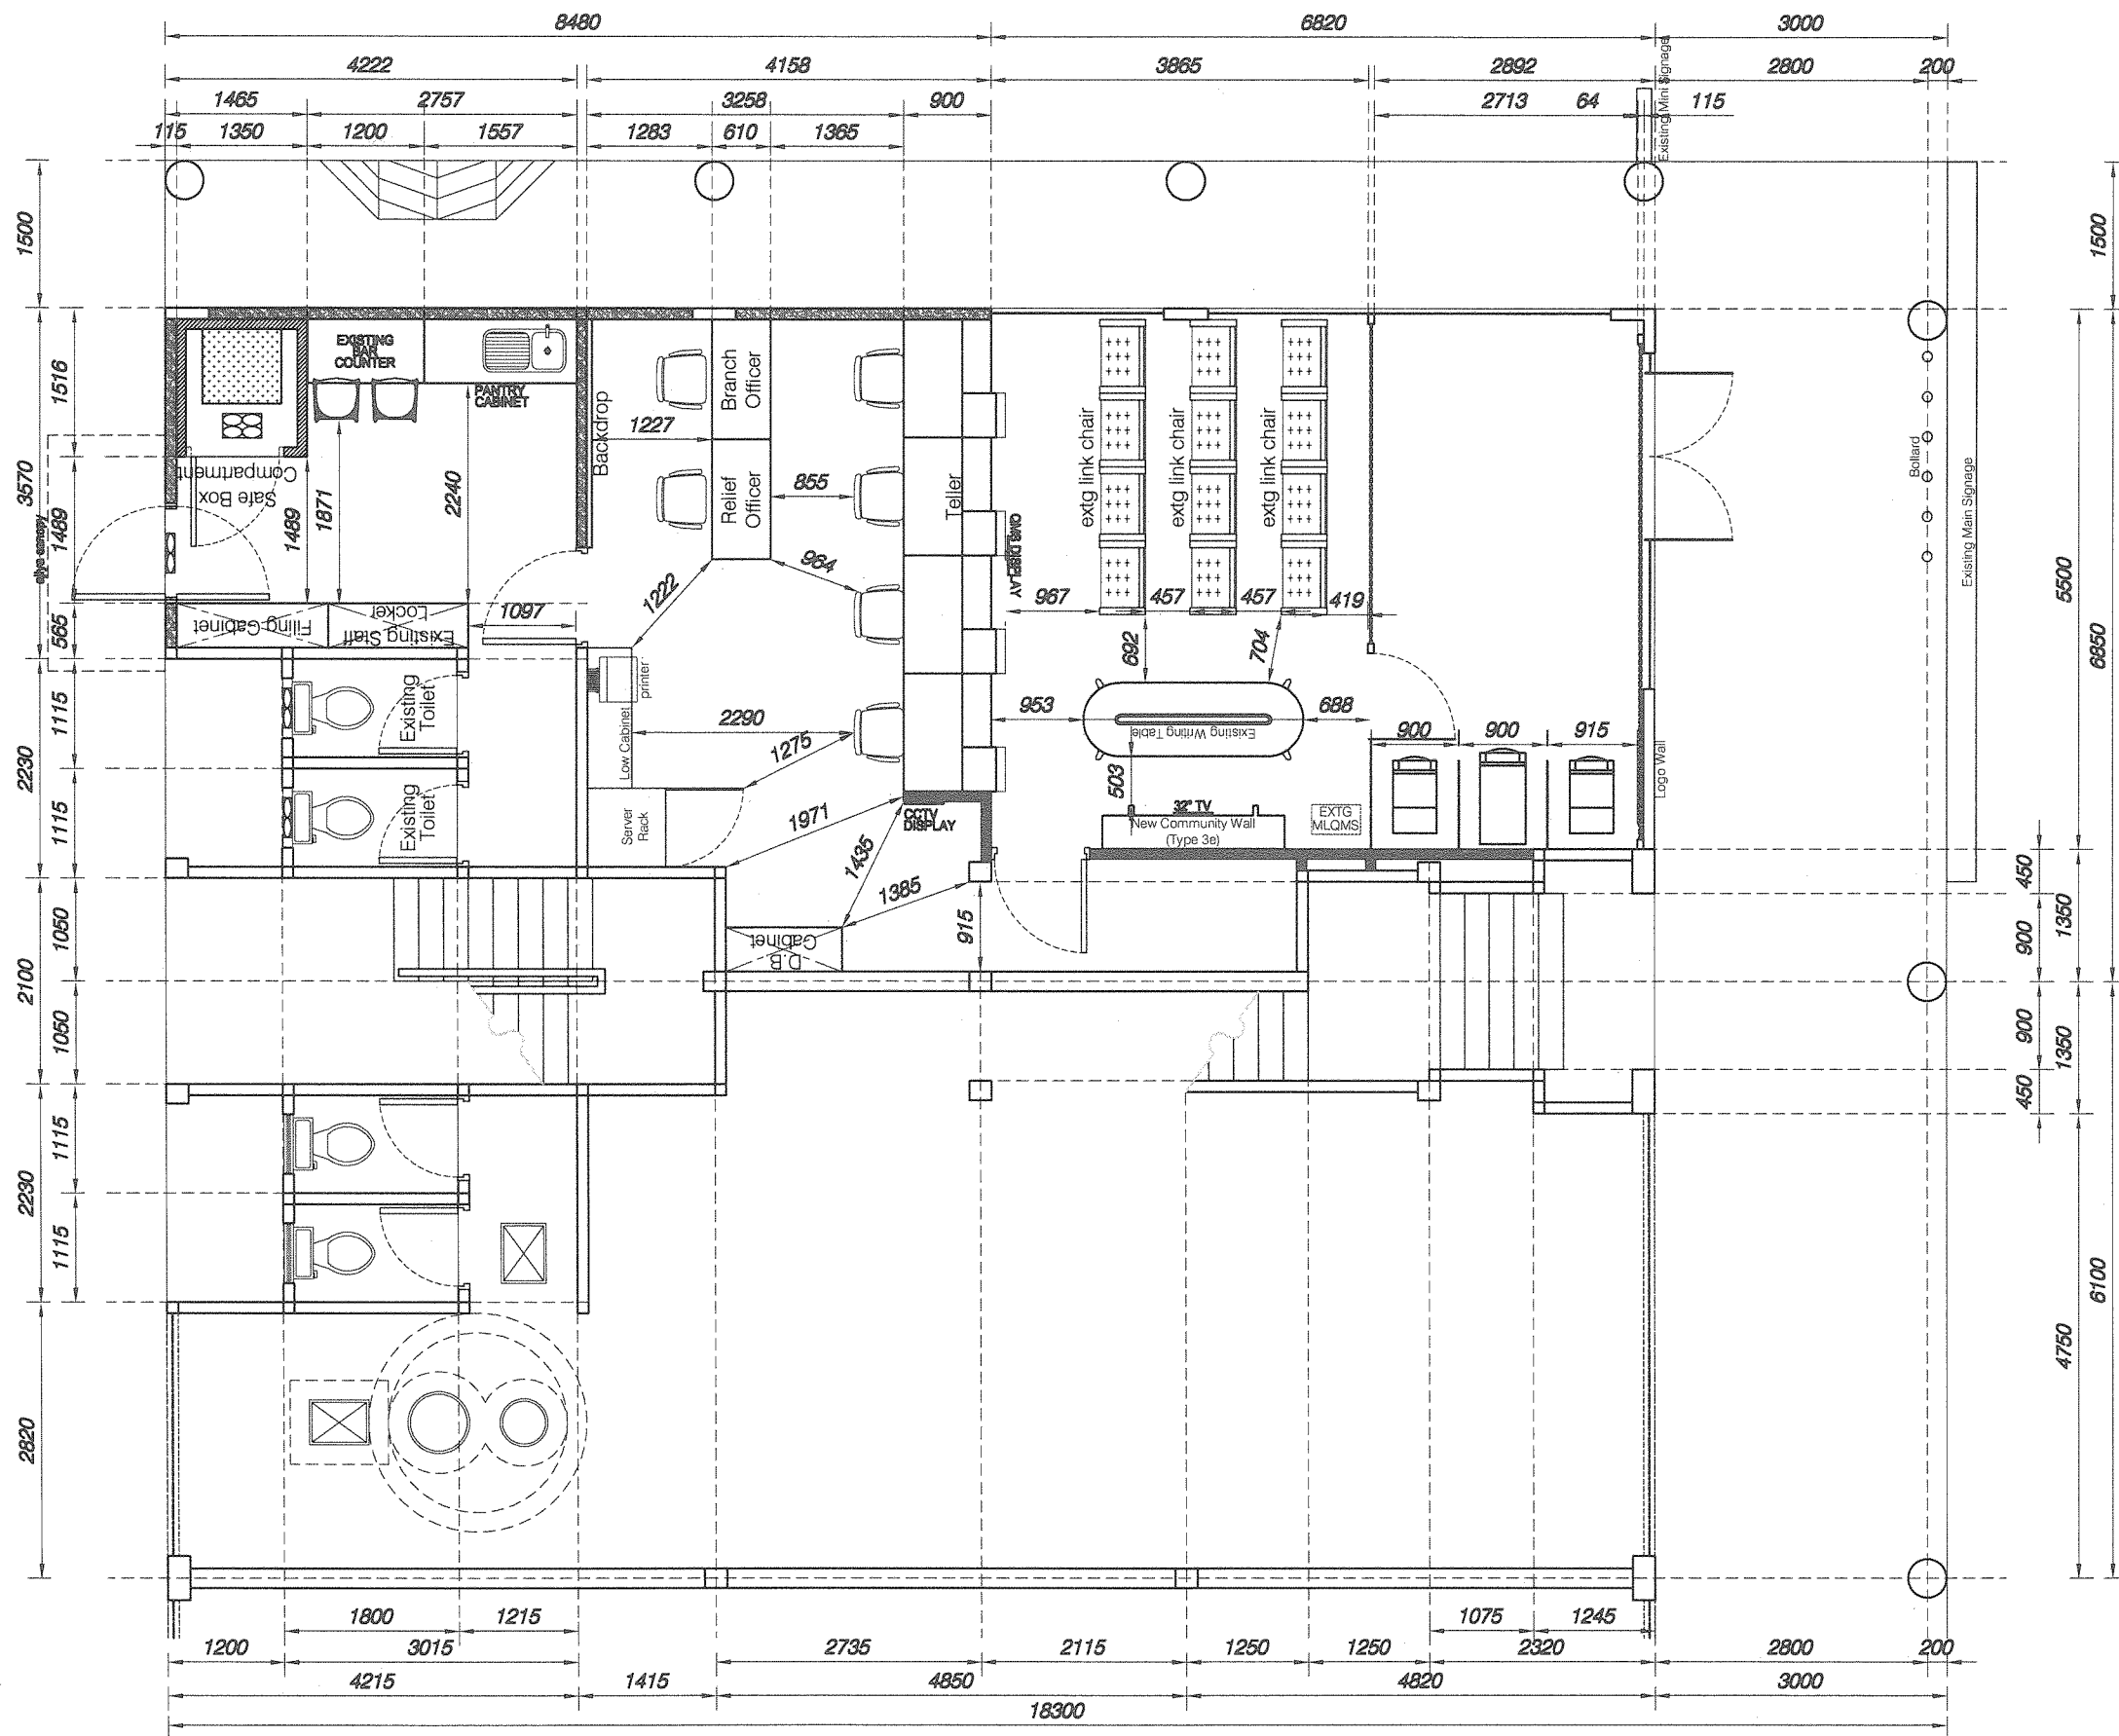

PROJECT TITLE:
 PROPOSED INTERIOR FIT-OUT WORKS FOR
 BANK SIMPANAN NASIONAL AT GROUND FLOOR & FIRST FLOOR,
 LOT 625, KAPIT BAZAAR, JALAN SELIRIK, 96800 KAPIT, SARAWAK

FILE NO: BSN/IP/JPAK/FD/2020-03	DWG TITLE: GROUND FLOOR FURNITURE SETTING OUT PLAN
DATE: 170321	DRAWN BY: AYIE
JOB NO: 21/01	SCALE: 1 : 75
ISSUE: 2	BRANCH NAME: KAPIT, SARAWAK
	DWG NO: S05-G-002a

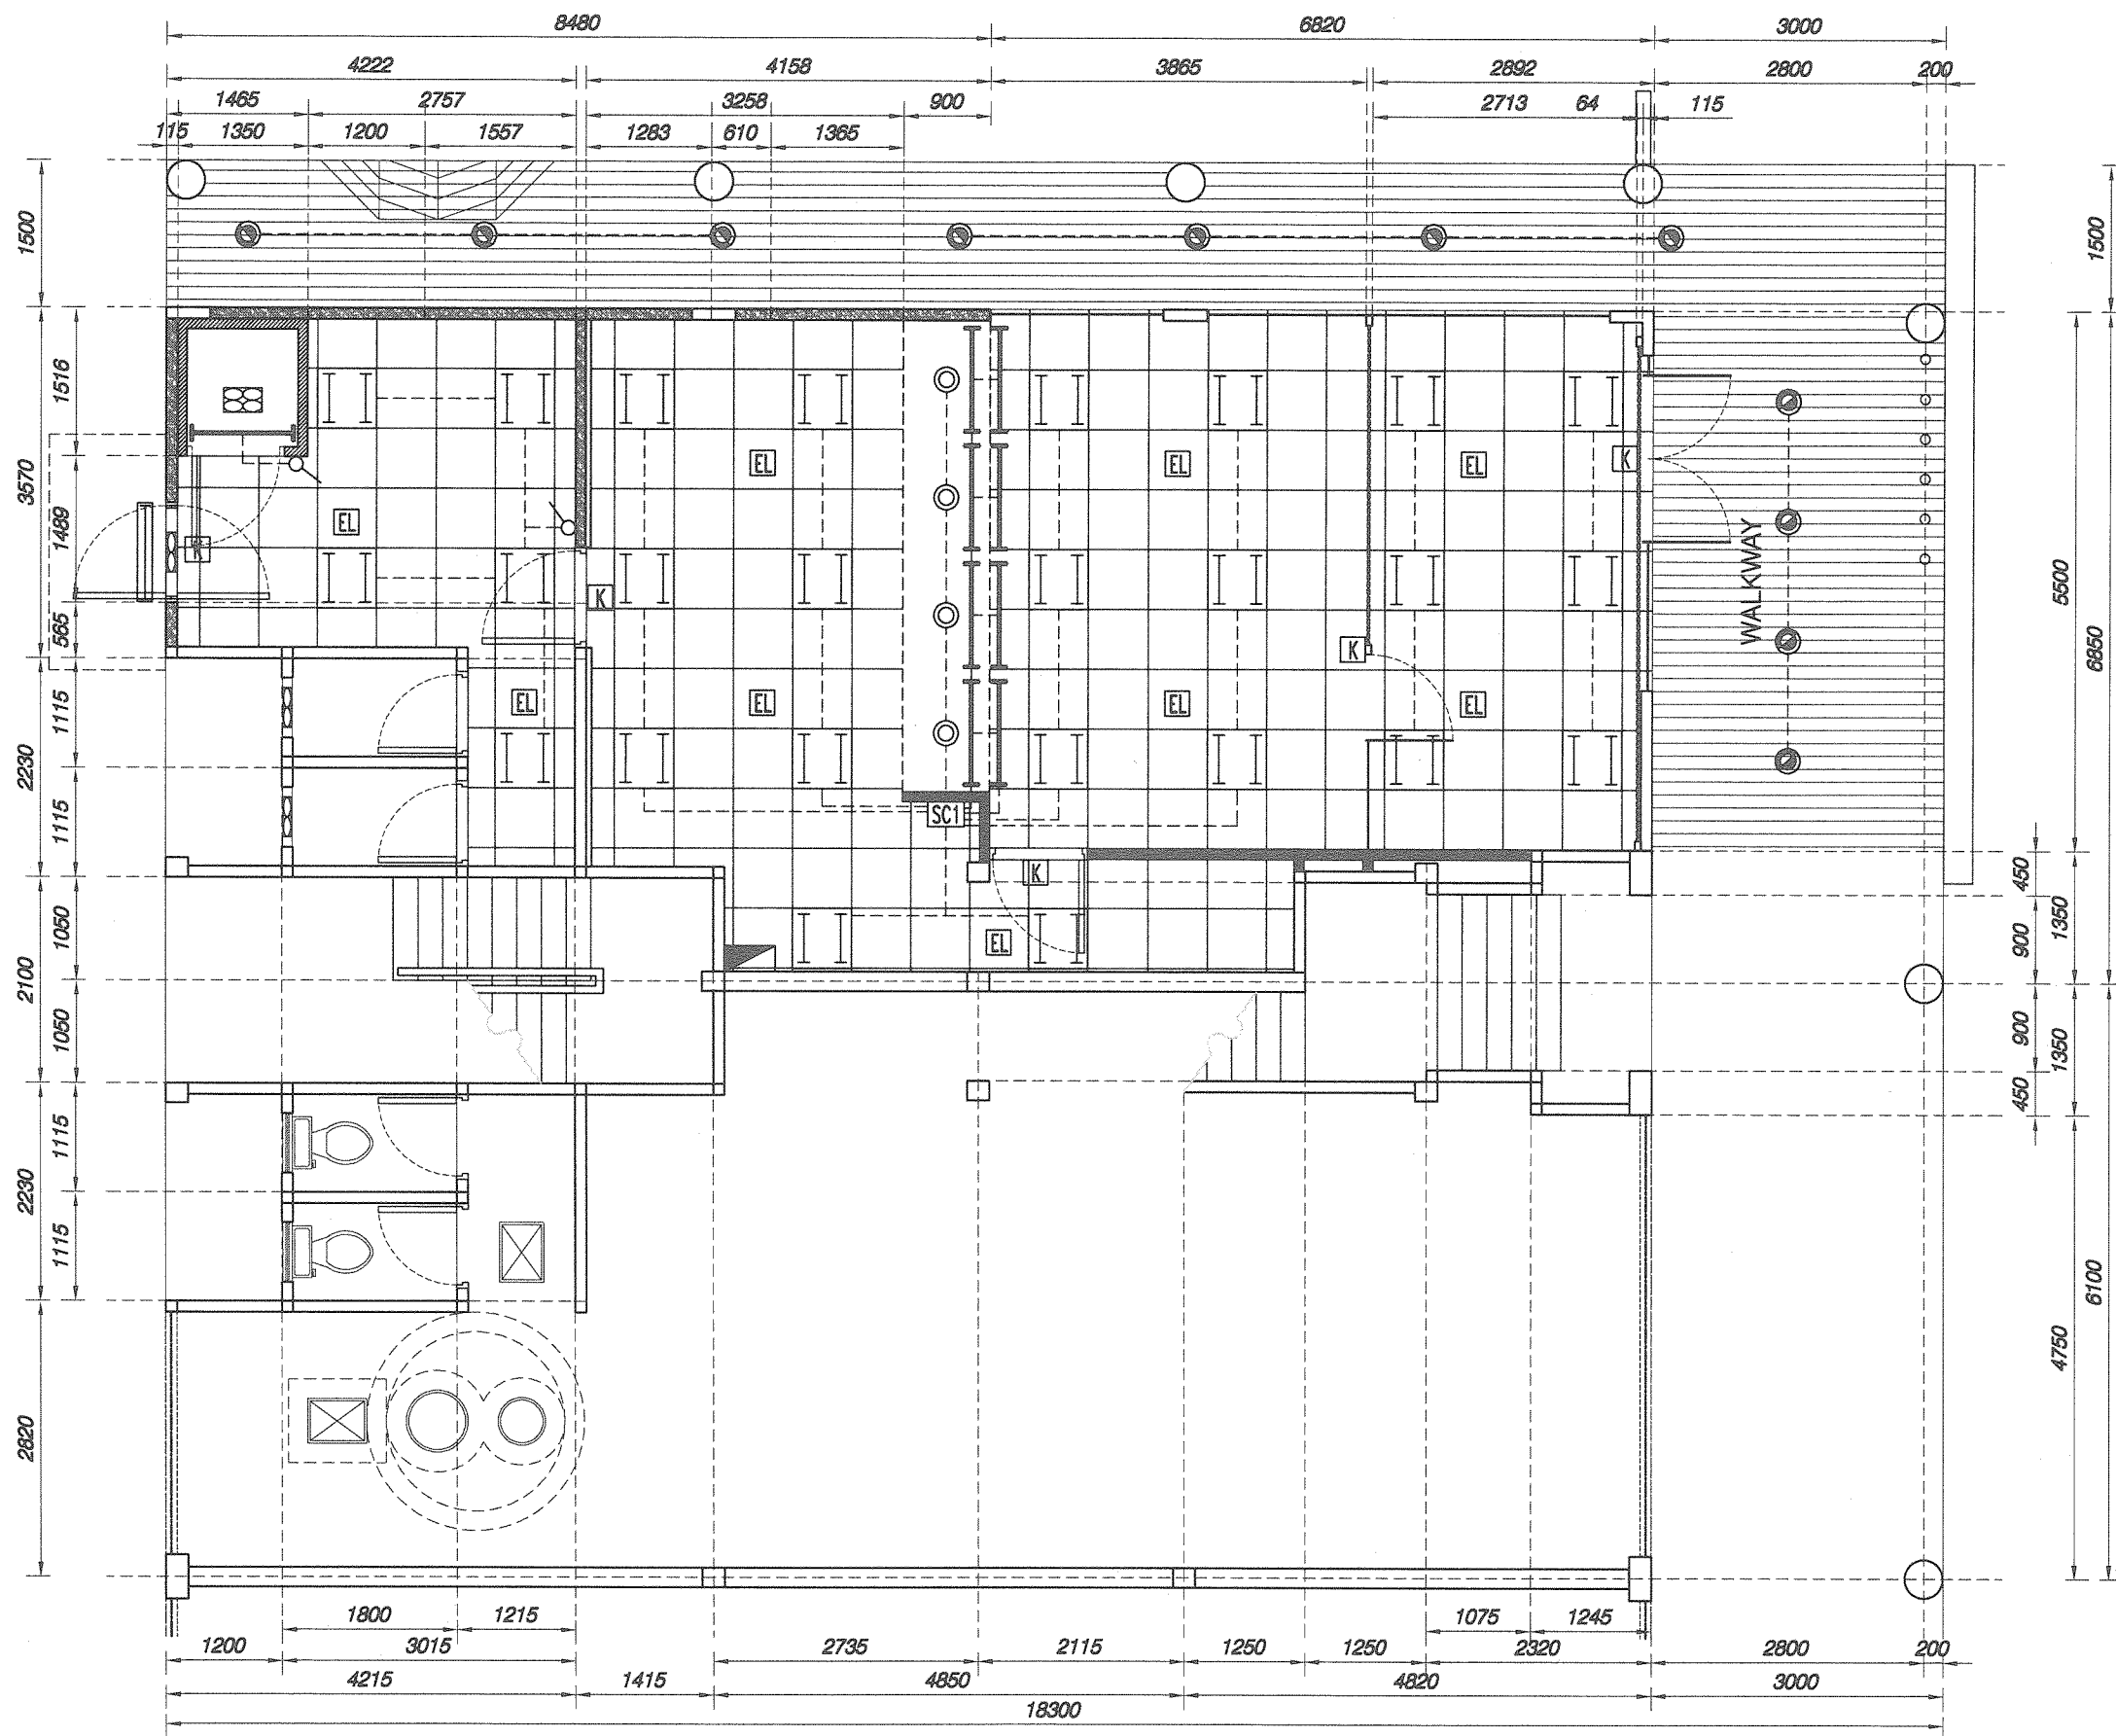

LEGEND	DESCRIPTION
	2 X 15W LED DOWN LIGHT
	1 X 15W LED DOWN LIGHT
	WEATHER PROOF LIGHT FITTING
	2X14W T5 RECESSED FLOURECENT FITTING C/W ALUMINUM REFLECTOR
	PENDANT LED LIGHT FITTING
	LED LIGHT STRIP
	DB ELECTRICAL (LIGHTING & POWER)
	EMERGENCY LIGHT
	KELUAR SIGN
	1 WAY LIGHT SWITCH (1500mm HT)
	LIGHT SWITCH CENTER 1 (700mm HT)
	LIGHT SWITCH CENTER 2 (1500mm HT)
	1 x 28W T5 FLOURECENT FTG
	T5 LED (WHITE)

PROJECT TITLE:

PROPOSED INTERIOR FIT-OUT WORKS FOR
BANK SIMPANAN NASIONAL AT GROUND FLOOR & FIRST FLOOR,
LOT 625, KAPIT BAZAAR, JALAN SELIRIK, 96800 KAPIT, SARAWAK

DWG NO:
BSN/IP/JPAK/FD/2020-03

DATE: 170321
JOB NO: 21/01

DRAWN BY:
AYIE


SCALE: 1:75

DWG TITLE:
GROUND FLOOR
LIGHTING LAYOUT PLAN

BRANCH NAME:
KAPIT, SARAWAK

DWG NO:
ELECTRICAL SERVICES - 01


ISSUE:
2

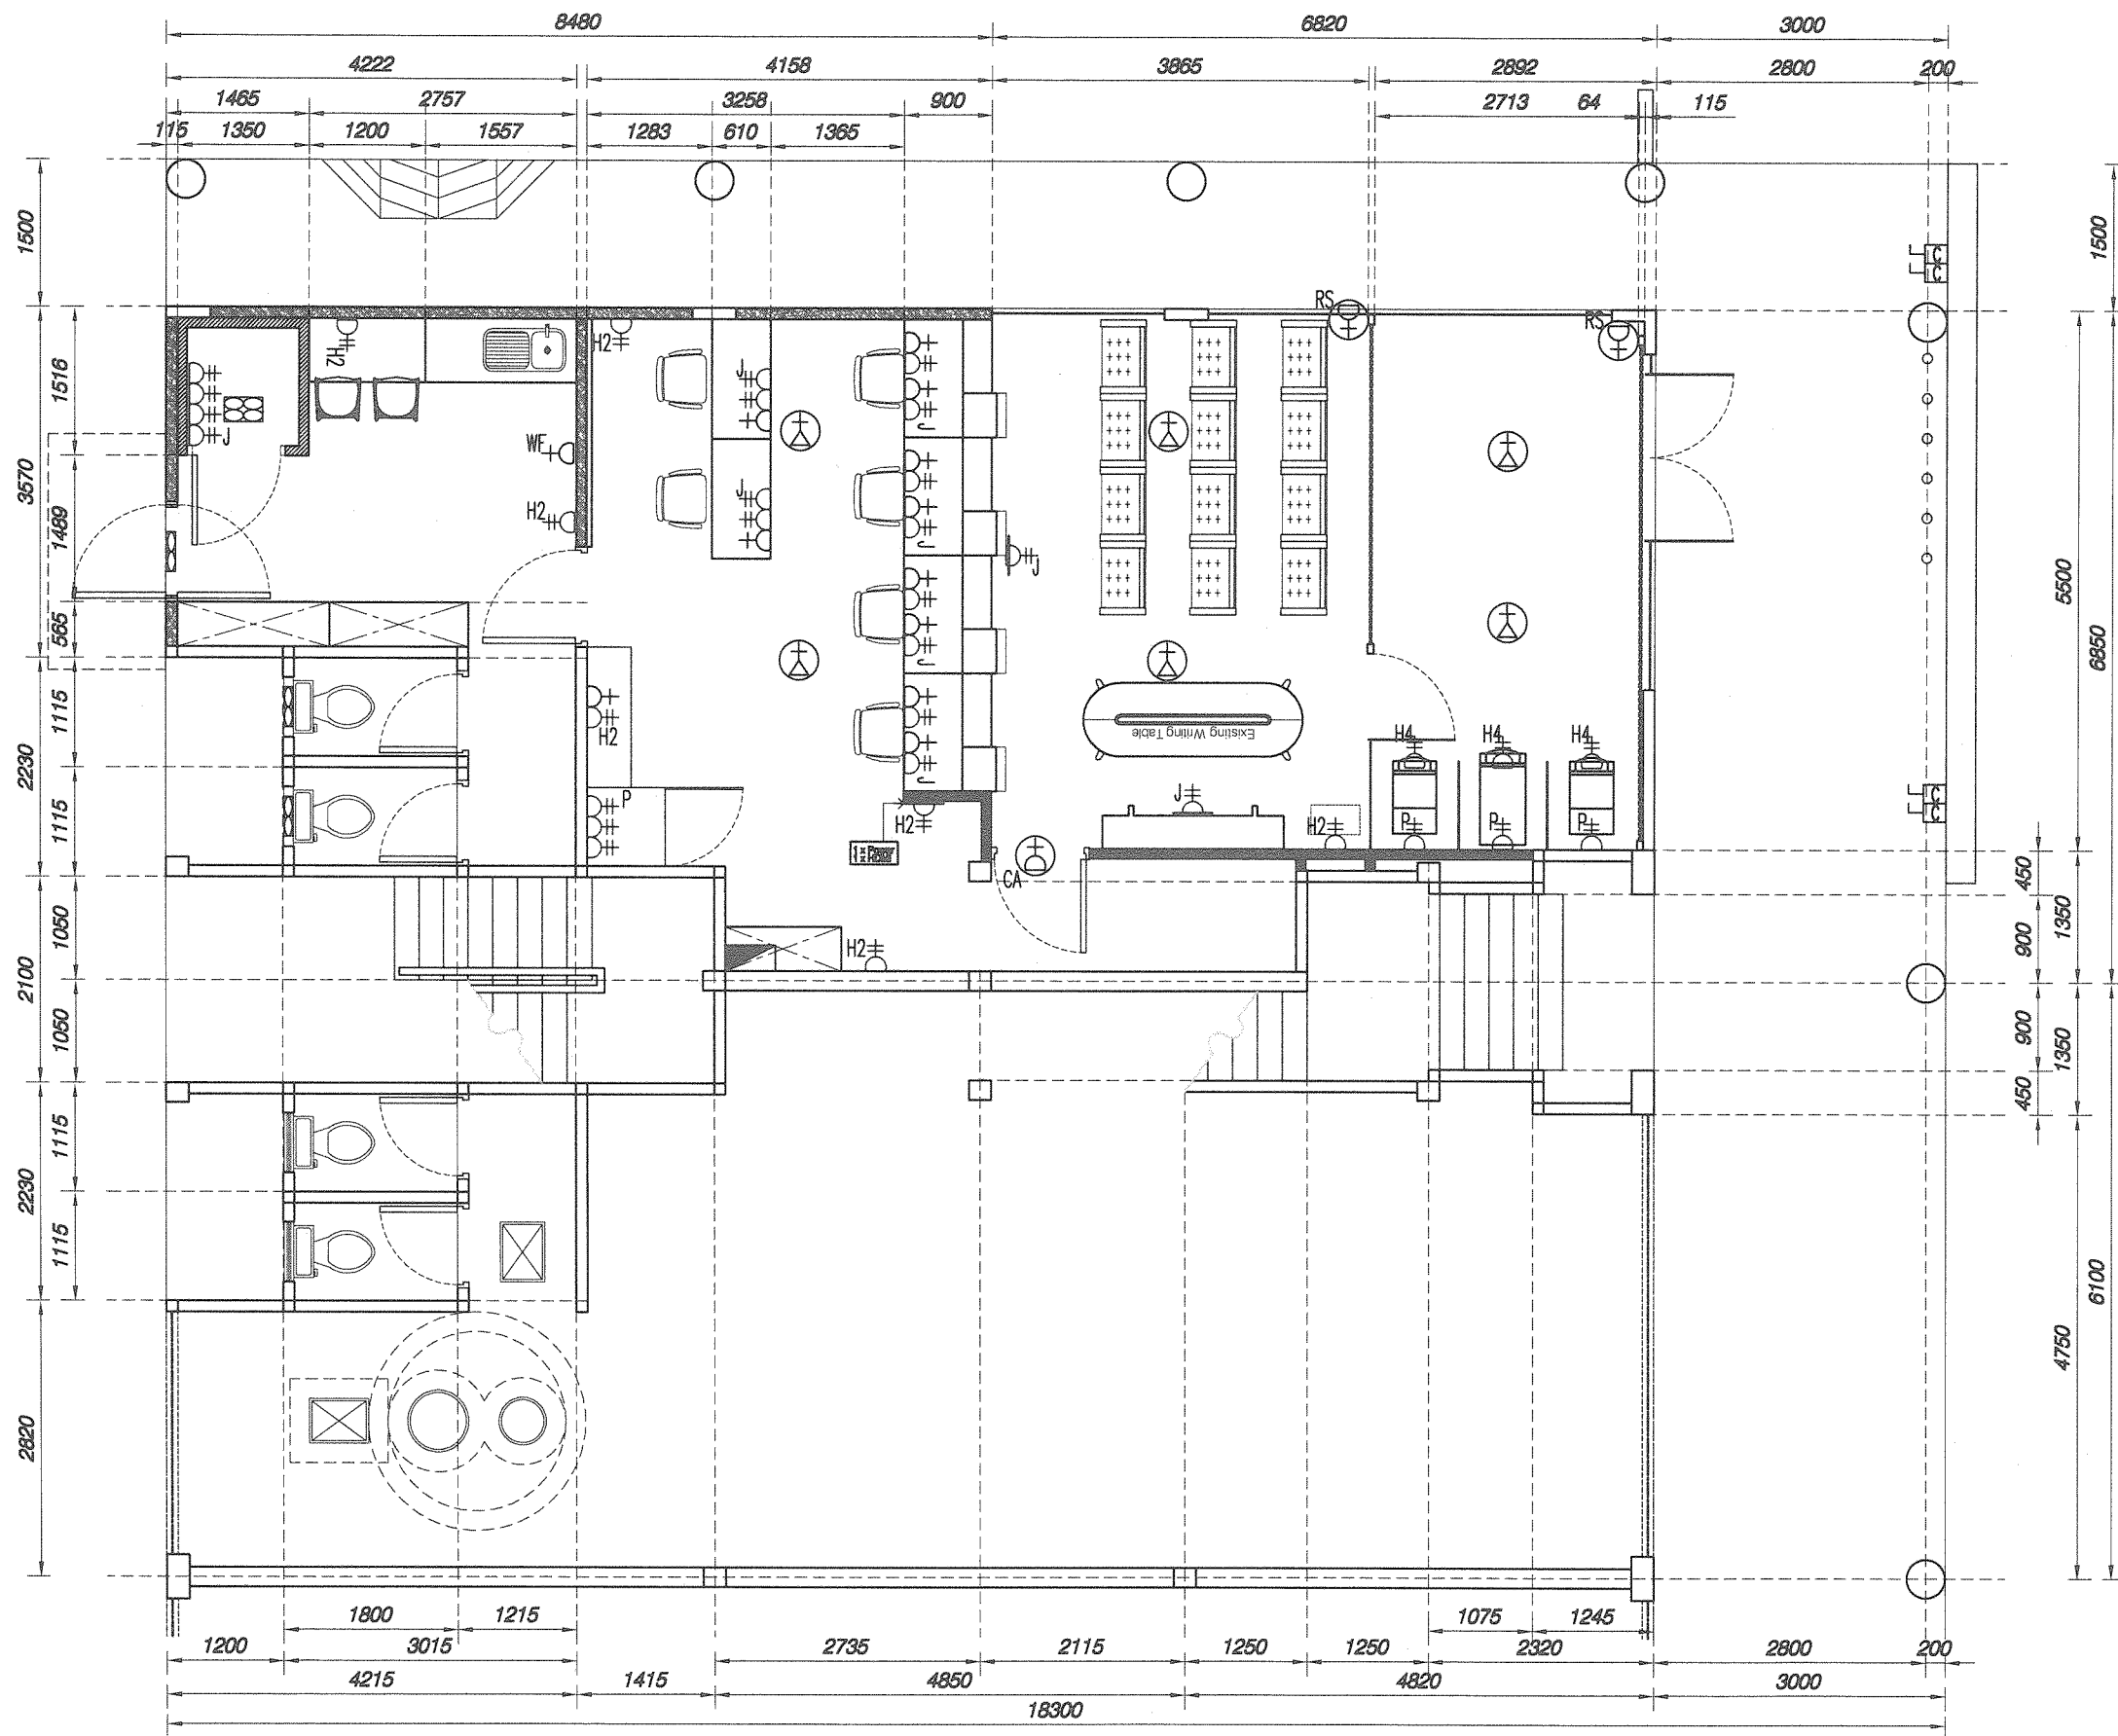

LEGEND	DESCRIPTION
	1 NO. 13A S/S/O
	2 NOS. 13A S/S/O
	1 NO. 13A S/S/O AT ABOVE CEILING LEVEL
	2 NOS. 13A S/S/O AT ABOVE CEILING LEVEL
	1 NO. 15A S/S/O AT ABOVE CEILING LEVEL FOR AC
	1 NO. 15A COMMANDO SOCKET WITH PLUG AT ABOVE CEILING LEVEL
	1 NO. 15A S/S/O-AIR COND AT WALL
W	INDICATES INSTALL ONTO WORKSTATION
P	INDICATES 300mm HT
H2	INDICATES 1050mm HT
H3	INDICATES 1200mm HT
H4	INDICATES 2100mm HT
WF	INDICATES 2100mm HT FOR WALL FAN
CA	INDICATES FOR CARD ACCESS
RS	INDICATES FOR ROLLER SHUTTER
J	INDICATES INSTALL ONTO JOINERY
	DB ELECTRICAL

PROJECT TITLE:
**PROPOSED INTERIOR FIT-OUT WORKS FOR
 BANK SIMPANAN NASIONAL AT GROUND FLOOR & FIRST FLOOR,
 LOT 625, KAPIT BAZAAR, JALAN SELIRIK, 96800 KAPIT, SARAWAK**


FILE NO: BSN/IP/JPAK/FD/2020-03	DWG TITLE: GROUND FLOOR POWER LAYOUT PLAN
DATE: 170321	DRAWN BY: AYIE
JOB NO: 21/01	SCALE: 1:75
ISSUE: 2	BRANCH NAME: KAPIT, SARAWAK
	DWG NO: ELECTRICAL SERVICES - 02

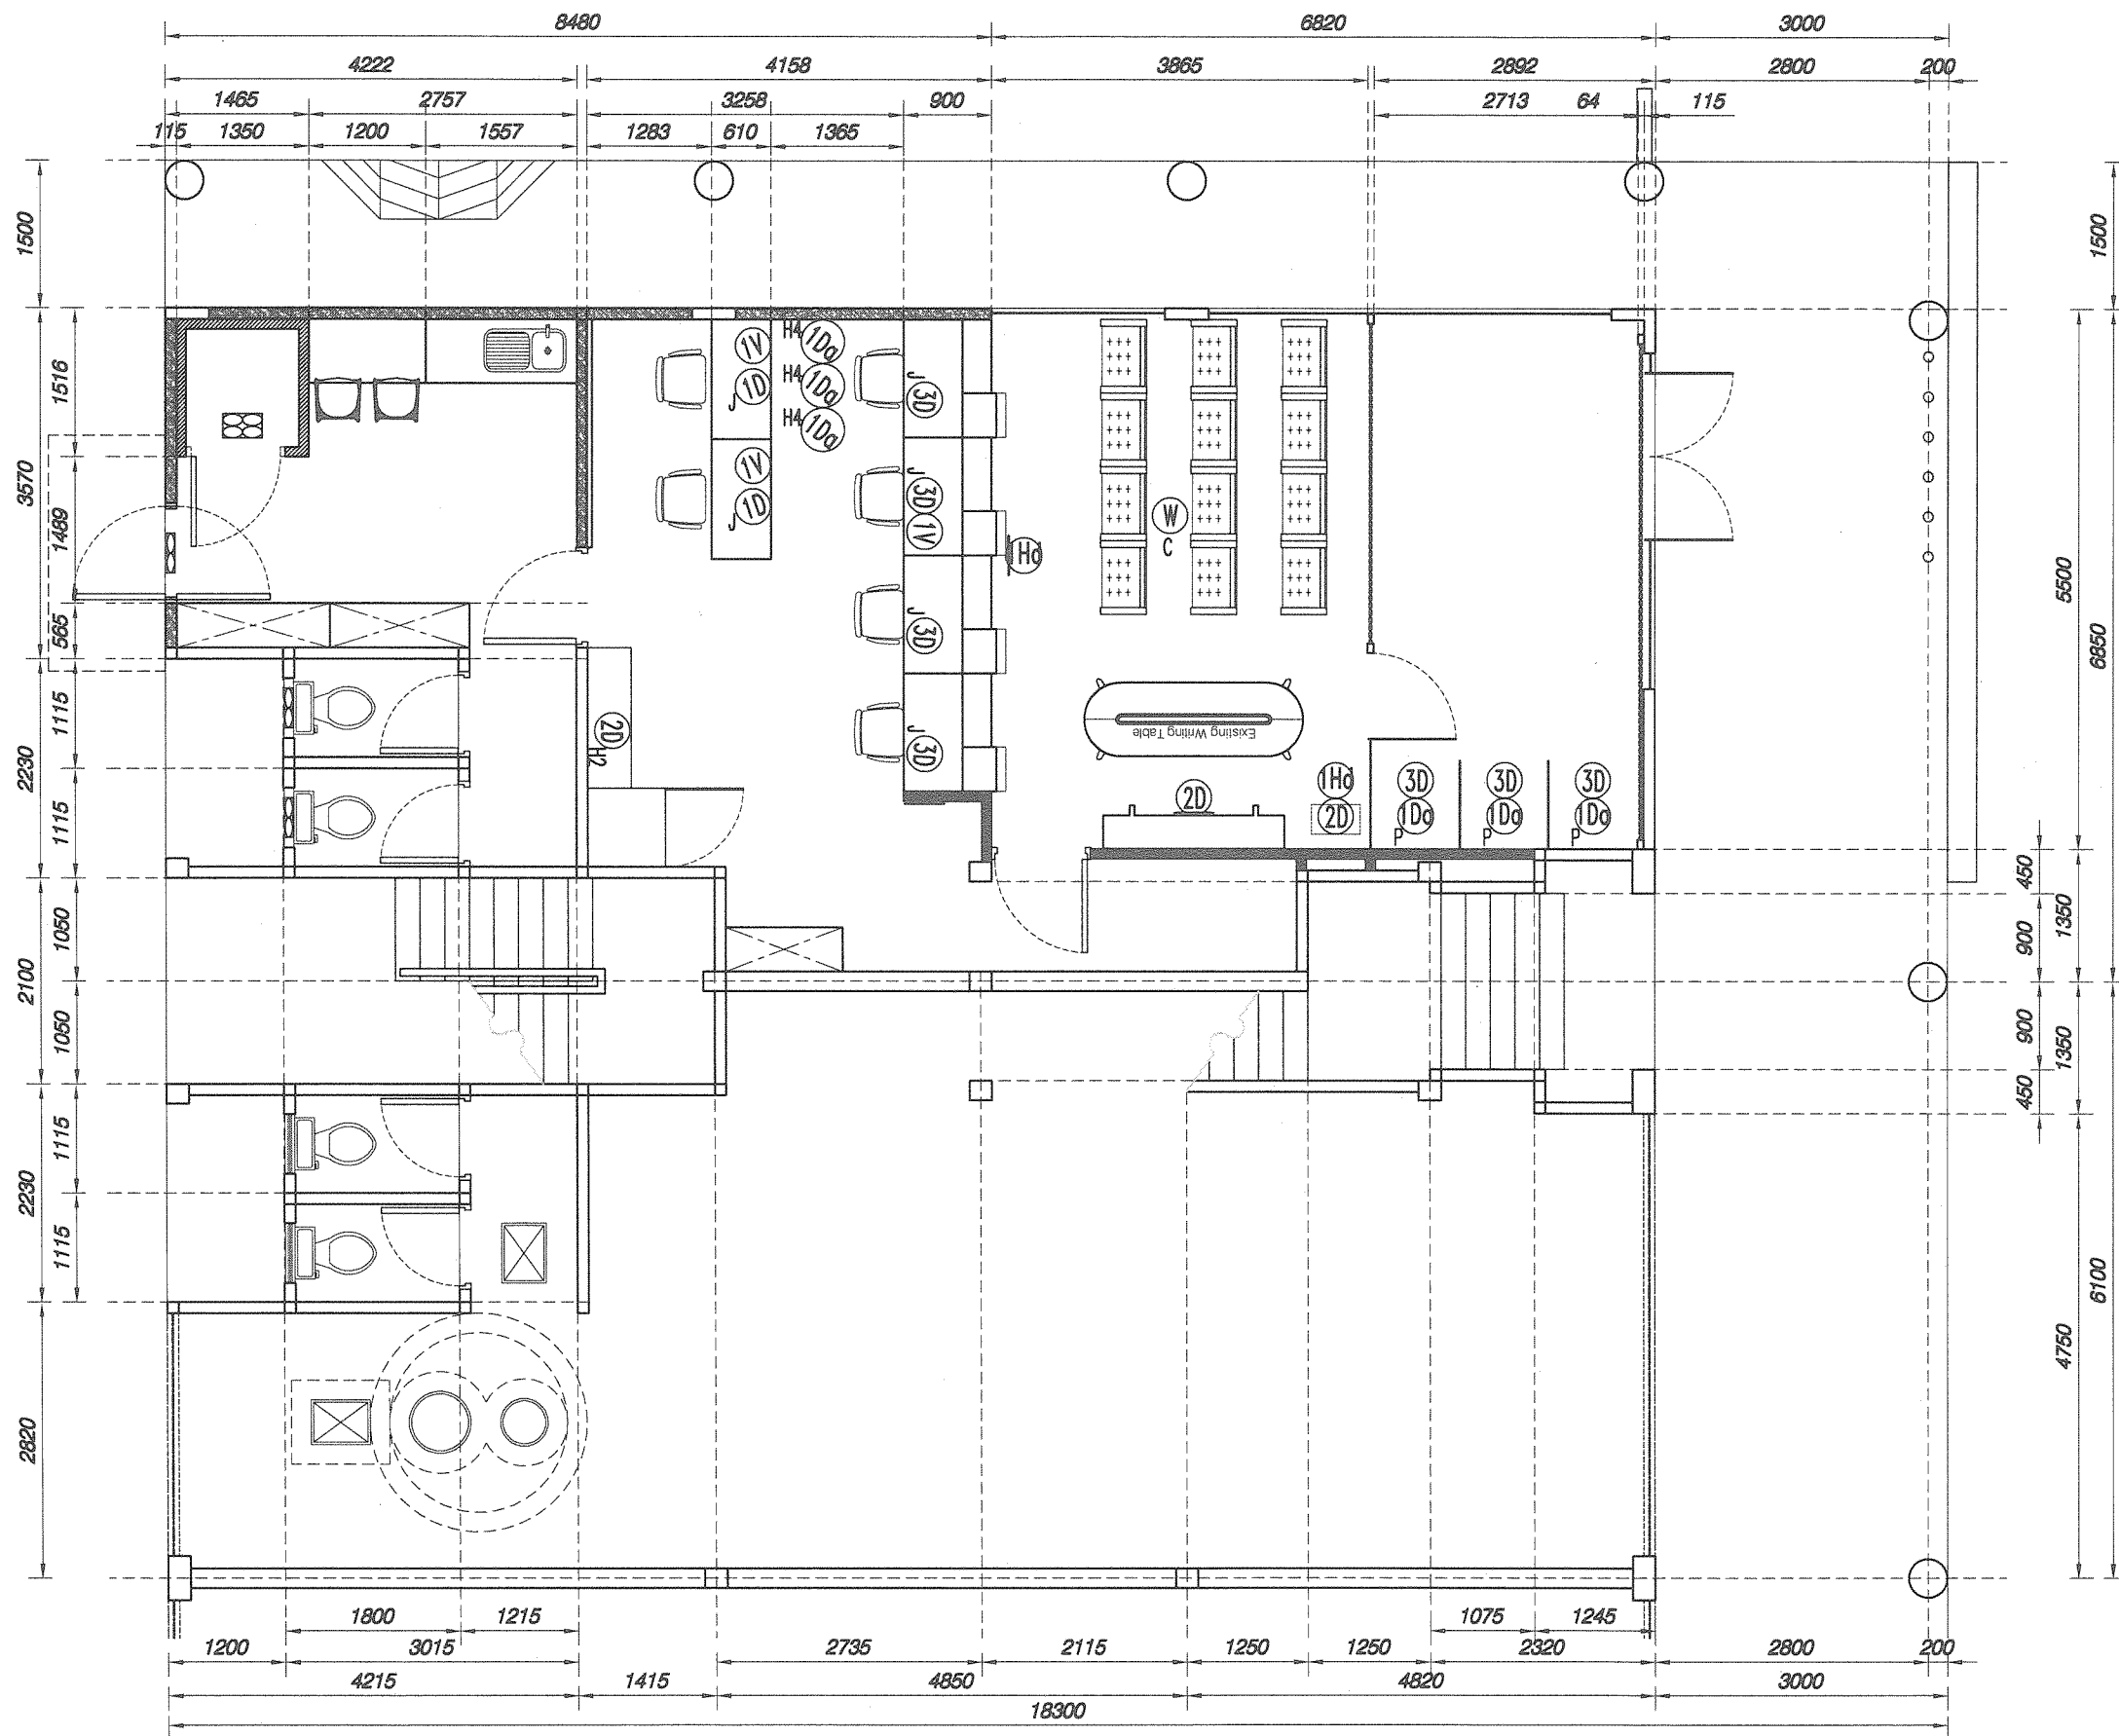

LEGEND	DESCRIPTION
(1D)	1 NO. CAT6 DATA POINT
(2D)	2 NOS. CAT6 DATA POINT
(3D)	3 NOS. CAT6 DATA POINT
(4D)	4 NOS. CAT6 DATA POINT
(1Da)	1 NOS. CAT6 DATA POINT (ATM Indicator point to point direct from each ATM to Relief Officer Area)
(1Hd)	1 NOS. HDMI CABLE COMPLETE WITH HDMI CONVERTER (HDMI cable from MLQMS to MLQMS display)
(1V)	1 NO. CAT6 VOICE POINT
(2V)	2 NOS. CAT6 VOICE POINT
C	INDICATES AT ABOVE CEILING LEVEL
W	INDICATES FIX ONTO WORKSTATION
J	INDICATES FIX ONTO JOINERY
P	INDICATES 300mm HT
H2	INDICATES 1050mm HT
H3	INDICATES 1200mm HT
H4	INDICATES 2100mm HT
	1 UNIT 42U X 800mm X 800mm SERVER RACK

PROJECT TITLE:
 PROPOSED INTERIOR FIT-OUT WORKS FOR
 BANK SIMPANAN NASIONAL AT GROUND FLOOR & FIRST FLOOR,
 LOT 625, KAPIT BAZAAR, JALAN SELIRIK, 96800 KAPIT, SARAWAK

FILE NO: BSN/IP/JPAK/FD/2020-03	DWG TITLE: GROUND FLOOR TELEPHONE & STRUCTURED CABLING LAYOUT PLAN
DATE: 170321	DRAWN BY: AYIE
JOB NO: 21/01	SCALE: 1 : 75
ISSUE: 2	BRANCH NAME: KAPIT, SARAWAK
	DWG NO: TELEPHONE & DATA SERVICES - 01

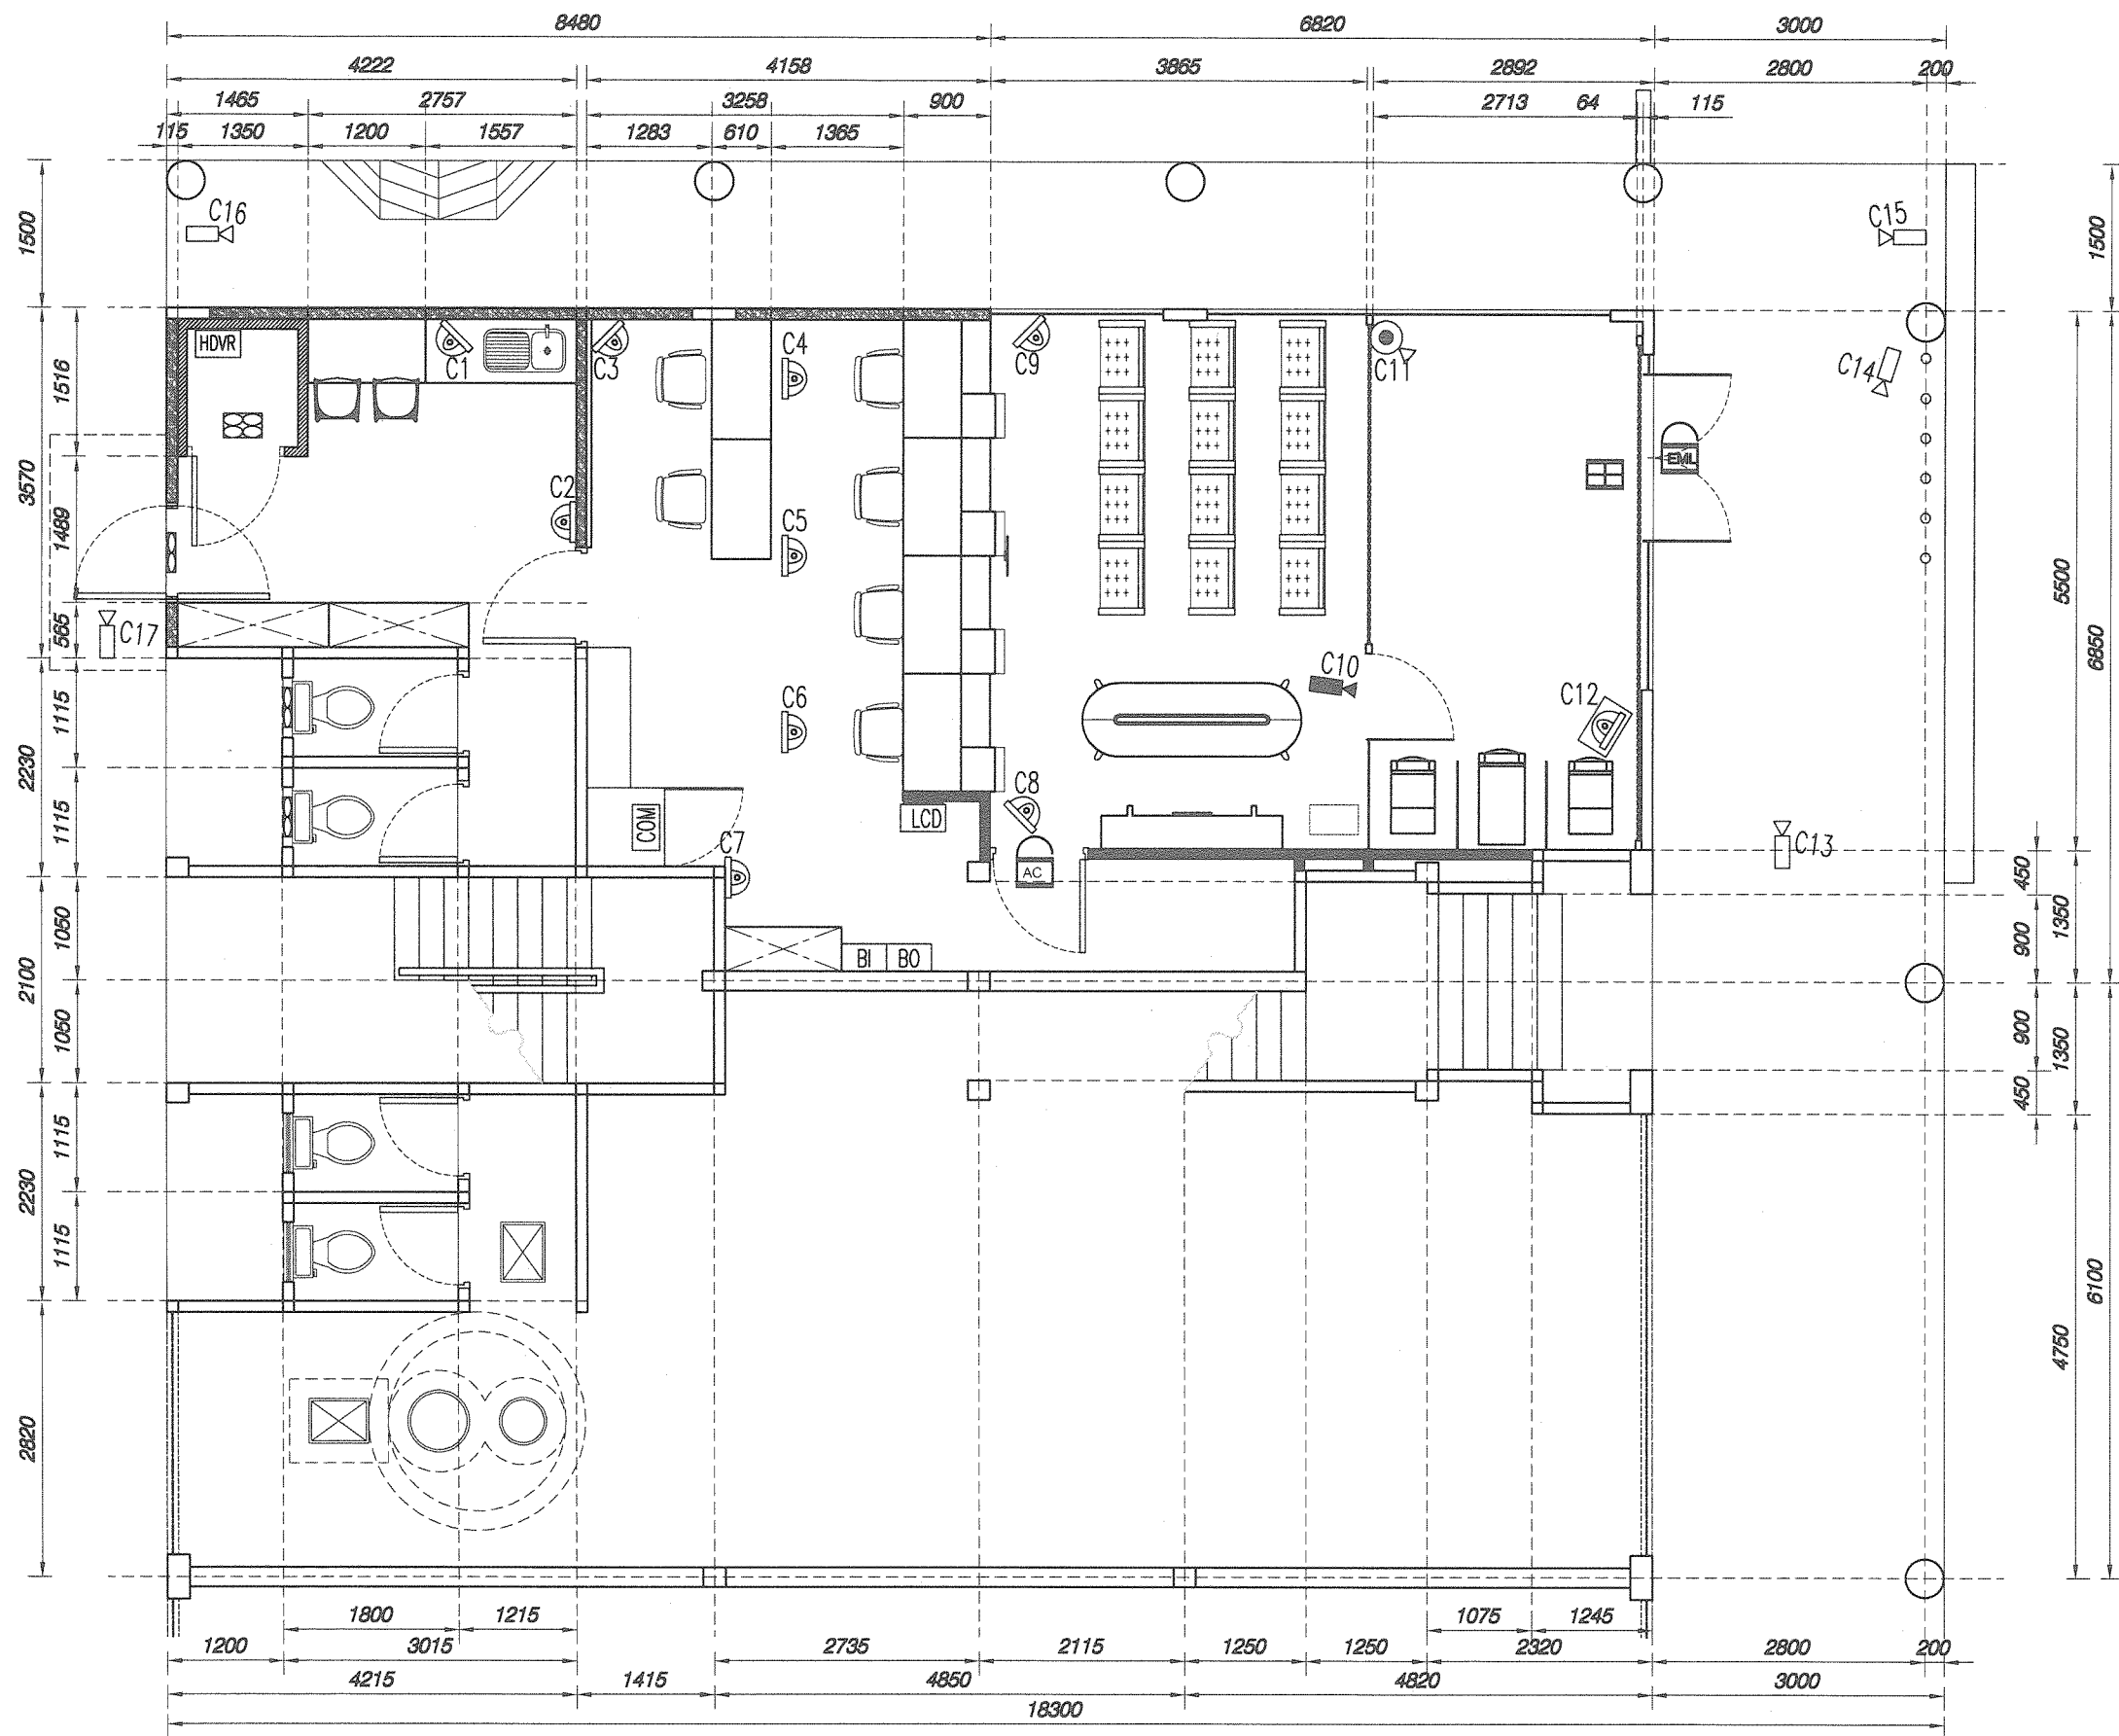

LEGEND	DESCRIPTION	QUANTITY
	ANTIVANDAL DOME IP CAMERA 4 MEGAPIXEL	1
	IP DOME CAMERA 4 MEGAPIXEL	9
	IR BULLET IP CAMERA 4 MEGAPIXEL	5
	3MP PIN HOLE IP CAMERA C/W BRACKET	1
	2 WAY COMMUNICATION IP DOME CAMERA	1
	32 CHANNEL DAHUA (32TB HDD) Network Video Recorder (NVR) IN 6U WALL MOUNT RACK (1800mm HT)	1
	CCTV MONITOR ON DESK	1
	BIOMETRIC FINGERPRINT "OUT"	1
	BIOMETRIC FINGERPRINT "IN"	1
	COMPUTER ACCESS CARD/WORKSTATION	1
	ACCESS CONTROL / CARD c/w FULL ACCESSORIES	1
	AUTOLOCK CONTROL PANEL c/w FULL ACCESSORIES	1
	ELECTRO MAGNET LOCK (600lbs minimum) c/w FULL ACCESSORIES	1

PROJECT TITLE:

PROPOSED INTERIOR FIT-OUT WORKS FOR
BANK SIMPANAN NASIONAL AT GROUND FLOOR & FIRST FLOOR,
LOT 625, KAPIT BAZAAR, JALAN SELIRIK, 96800 KAPIT, SARAWAK

FILE NO:
BSN/IP/JPAK/FD/2020-03

DATE: 170321
DRAWN BY: AYIE


JOB NO: 21/01
SCALE: 1 : 75

DWG TITLE:
GROUND FLOOR
CCTV & CARD ACCESS LAYOUT PLAN

BRANCH NAME:
KAPIT, SARAWAK

DWG NO:
CCTV & CARD ACCESS SERVICES - 01



ISSUE:
2

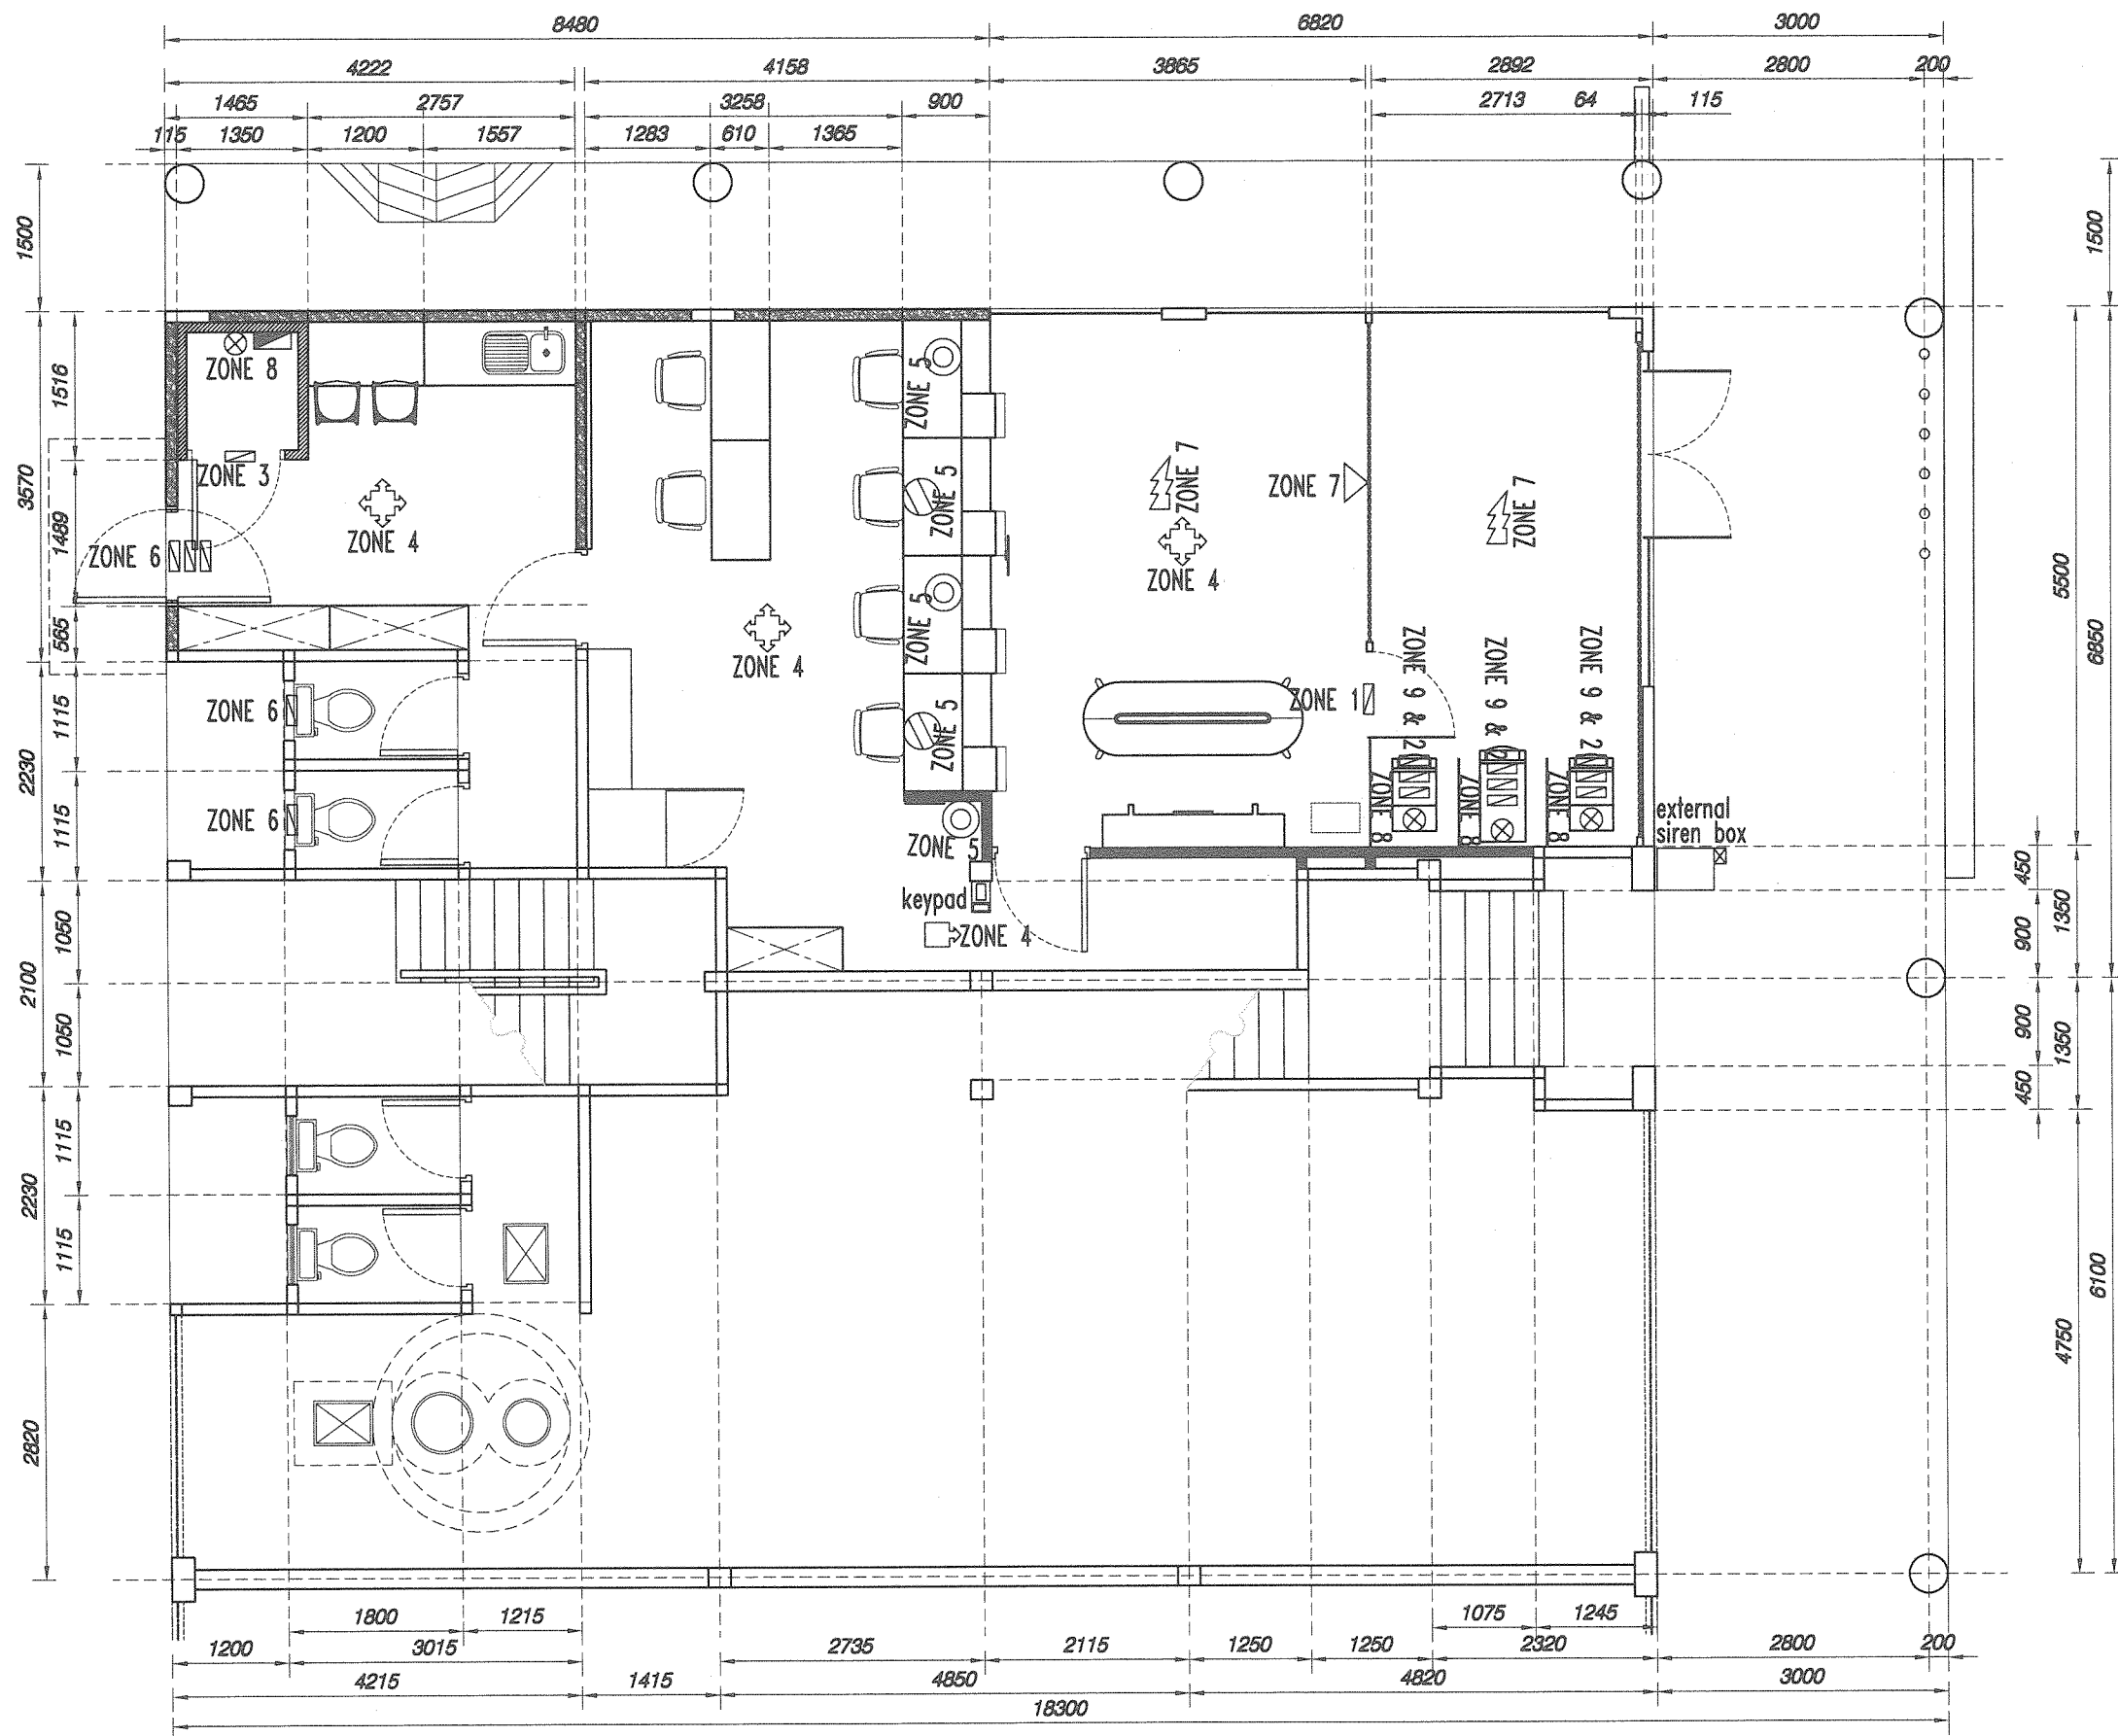

LEGEND	DESCRIPTION	QTY
	MAIN ALARM PANEL	1
	KEYPAD	1
	PIR DETECTOR 360 deg	3
	PIR DETECTOR 120 deg	1
	SEISMIC DETECTOR BURGOGUARD / SHOTGUARD	4
	OVERHEAD MAGNETIC CONTACT	1
	BREAKGLASS DETECTOR	2
	SURFACE MAGNETIC CONTACT	16
	EXTERNAL SIREN BOX	1
	PANIC BUTTON	3
	KICK BAR	2


PROJECT TITLE:
 PROPOSED INTERIOR FIT-OUT WORKS FOR
 BANK SIMPANAN NASIONAL AT GROUND FLOOR & FIRST FLOOR,
 LOT 625, KAPIT BAZAAR, JALAN SELIRIK, 96800 KAPIT, SARAWAK

FILE NO: BSN/IP/JPAK/FD/2020-03	DWG TITLE: GROUND FLOOR ALARM LAYOUT PLAN
DATE: 170321	DRAWN BY: AYIE
JOB NO: 21/01	SCALE: 1 : 75
ISSUE: 2	BRANCH NAME: KAPIT, SARAWAK
	DWG NO: ALARM SERVICES - 01

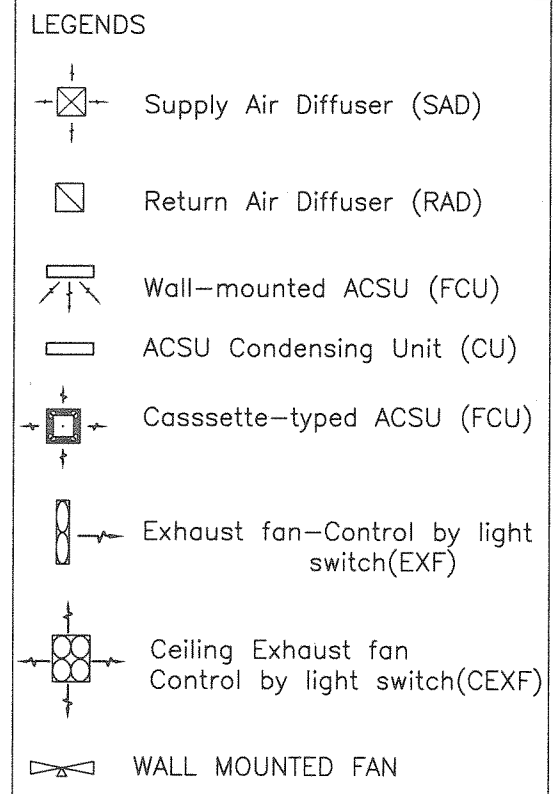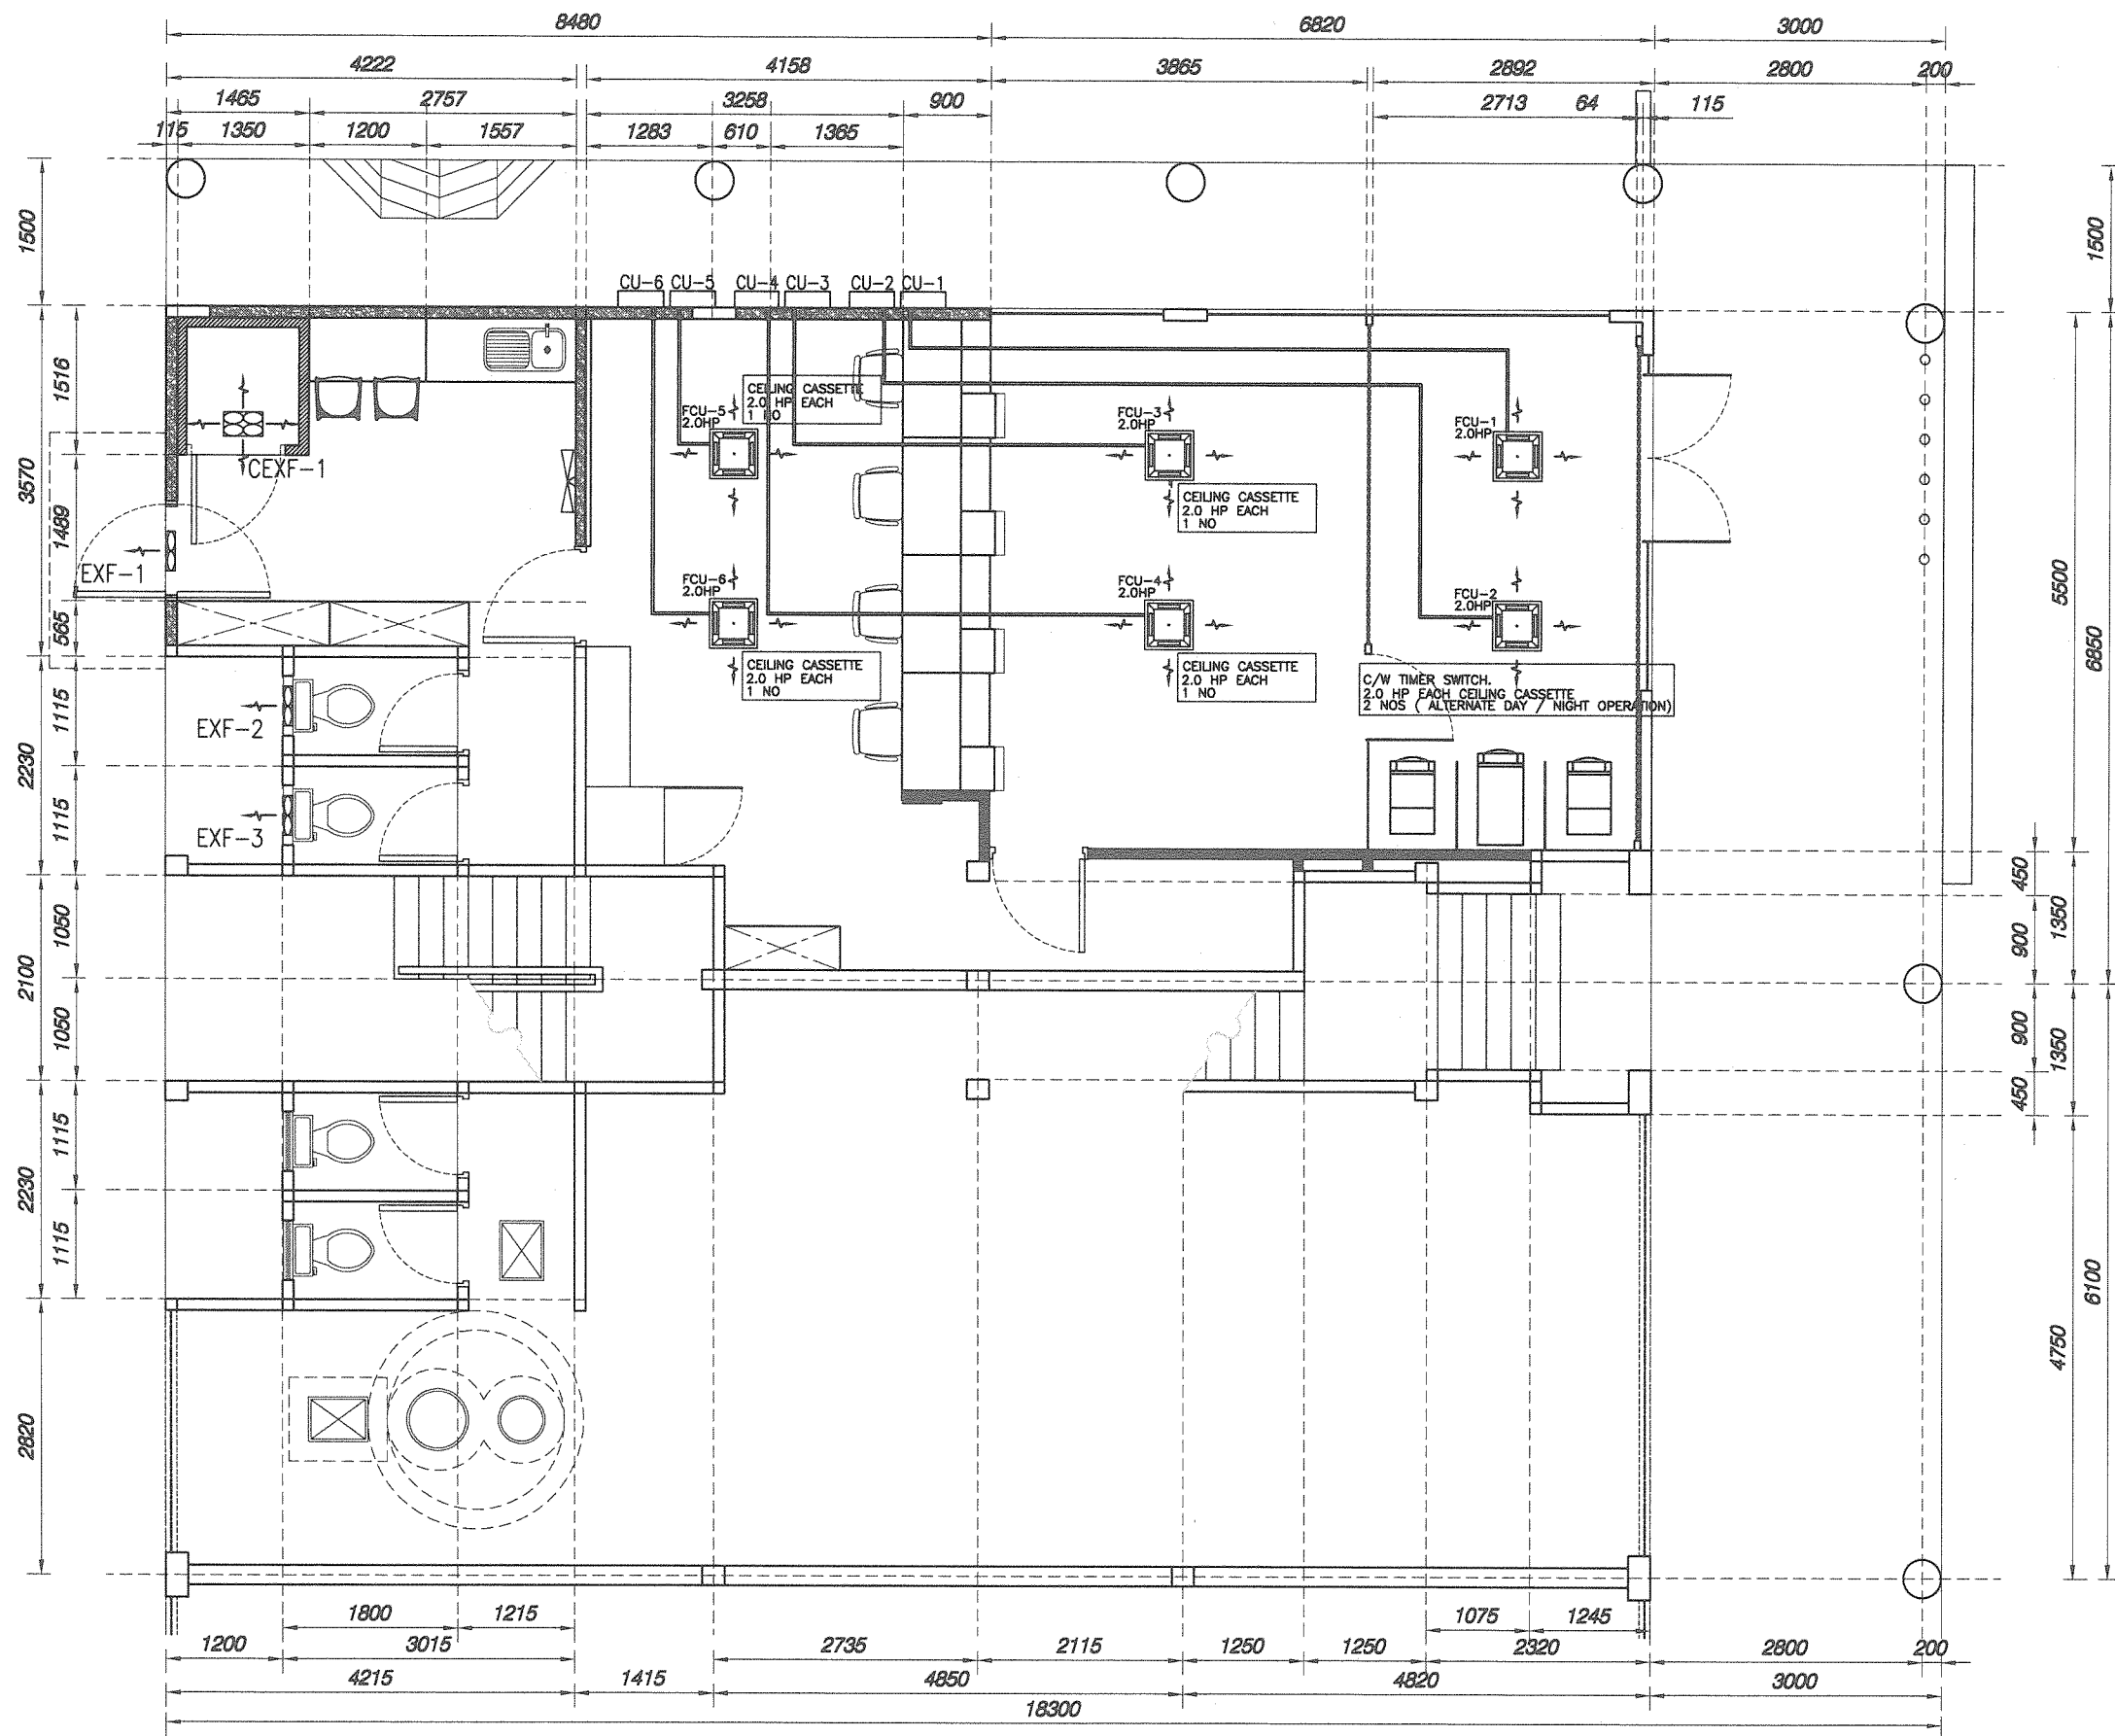

PROJECT TITLE:
**PROPOSED INTERIOR FIT-OUT WORKS FOR
 BANK SIMPANAN NASIONAL AT GROUND FLOOR & FIRST FLOOR,
 LOT 625, KAPIT BAZAAR, JALAN SELIRIK, 96800 KAPIT, SARAWAK**

FILE NO: BSN/IP/JPAK/FD/2020-03		DWG TITLE: GROUND FLOOR AIRCOND & EXHAUST FAN LAYOUT PLAN	
DATE: 170321	DRAWN BY: AYIE	ISSUE: 2	BRANCH NAME: KAPIT, SARAWAK
JOB NO: 21/01	SCALE: 1 : 75	DWG NO: MECHANICAL SERVICES - 01	

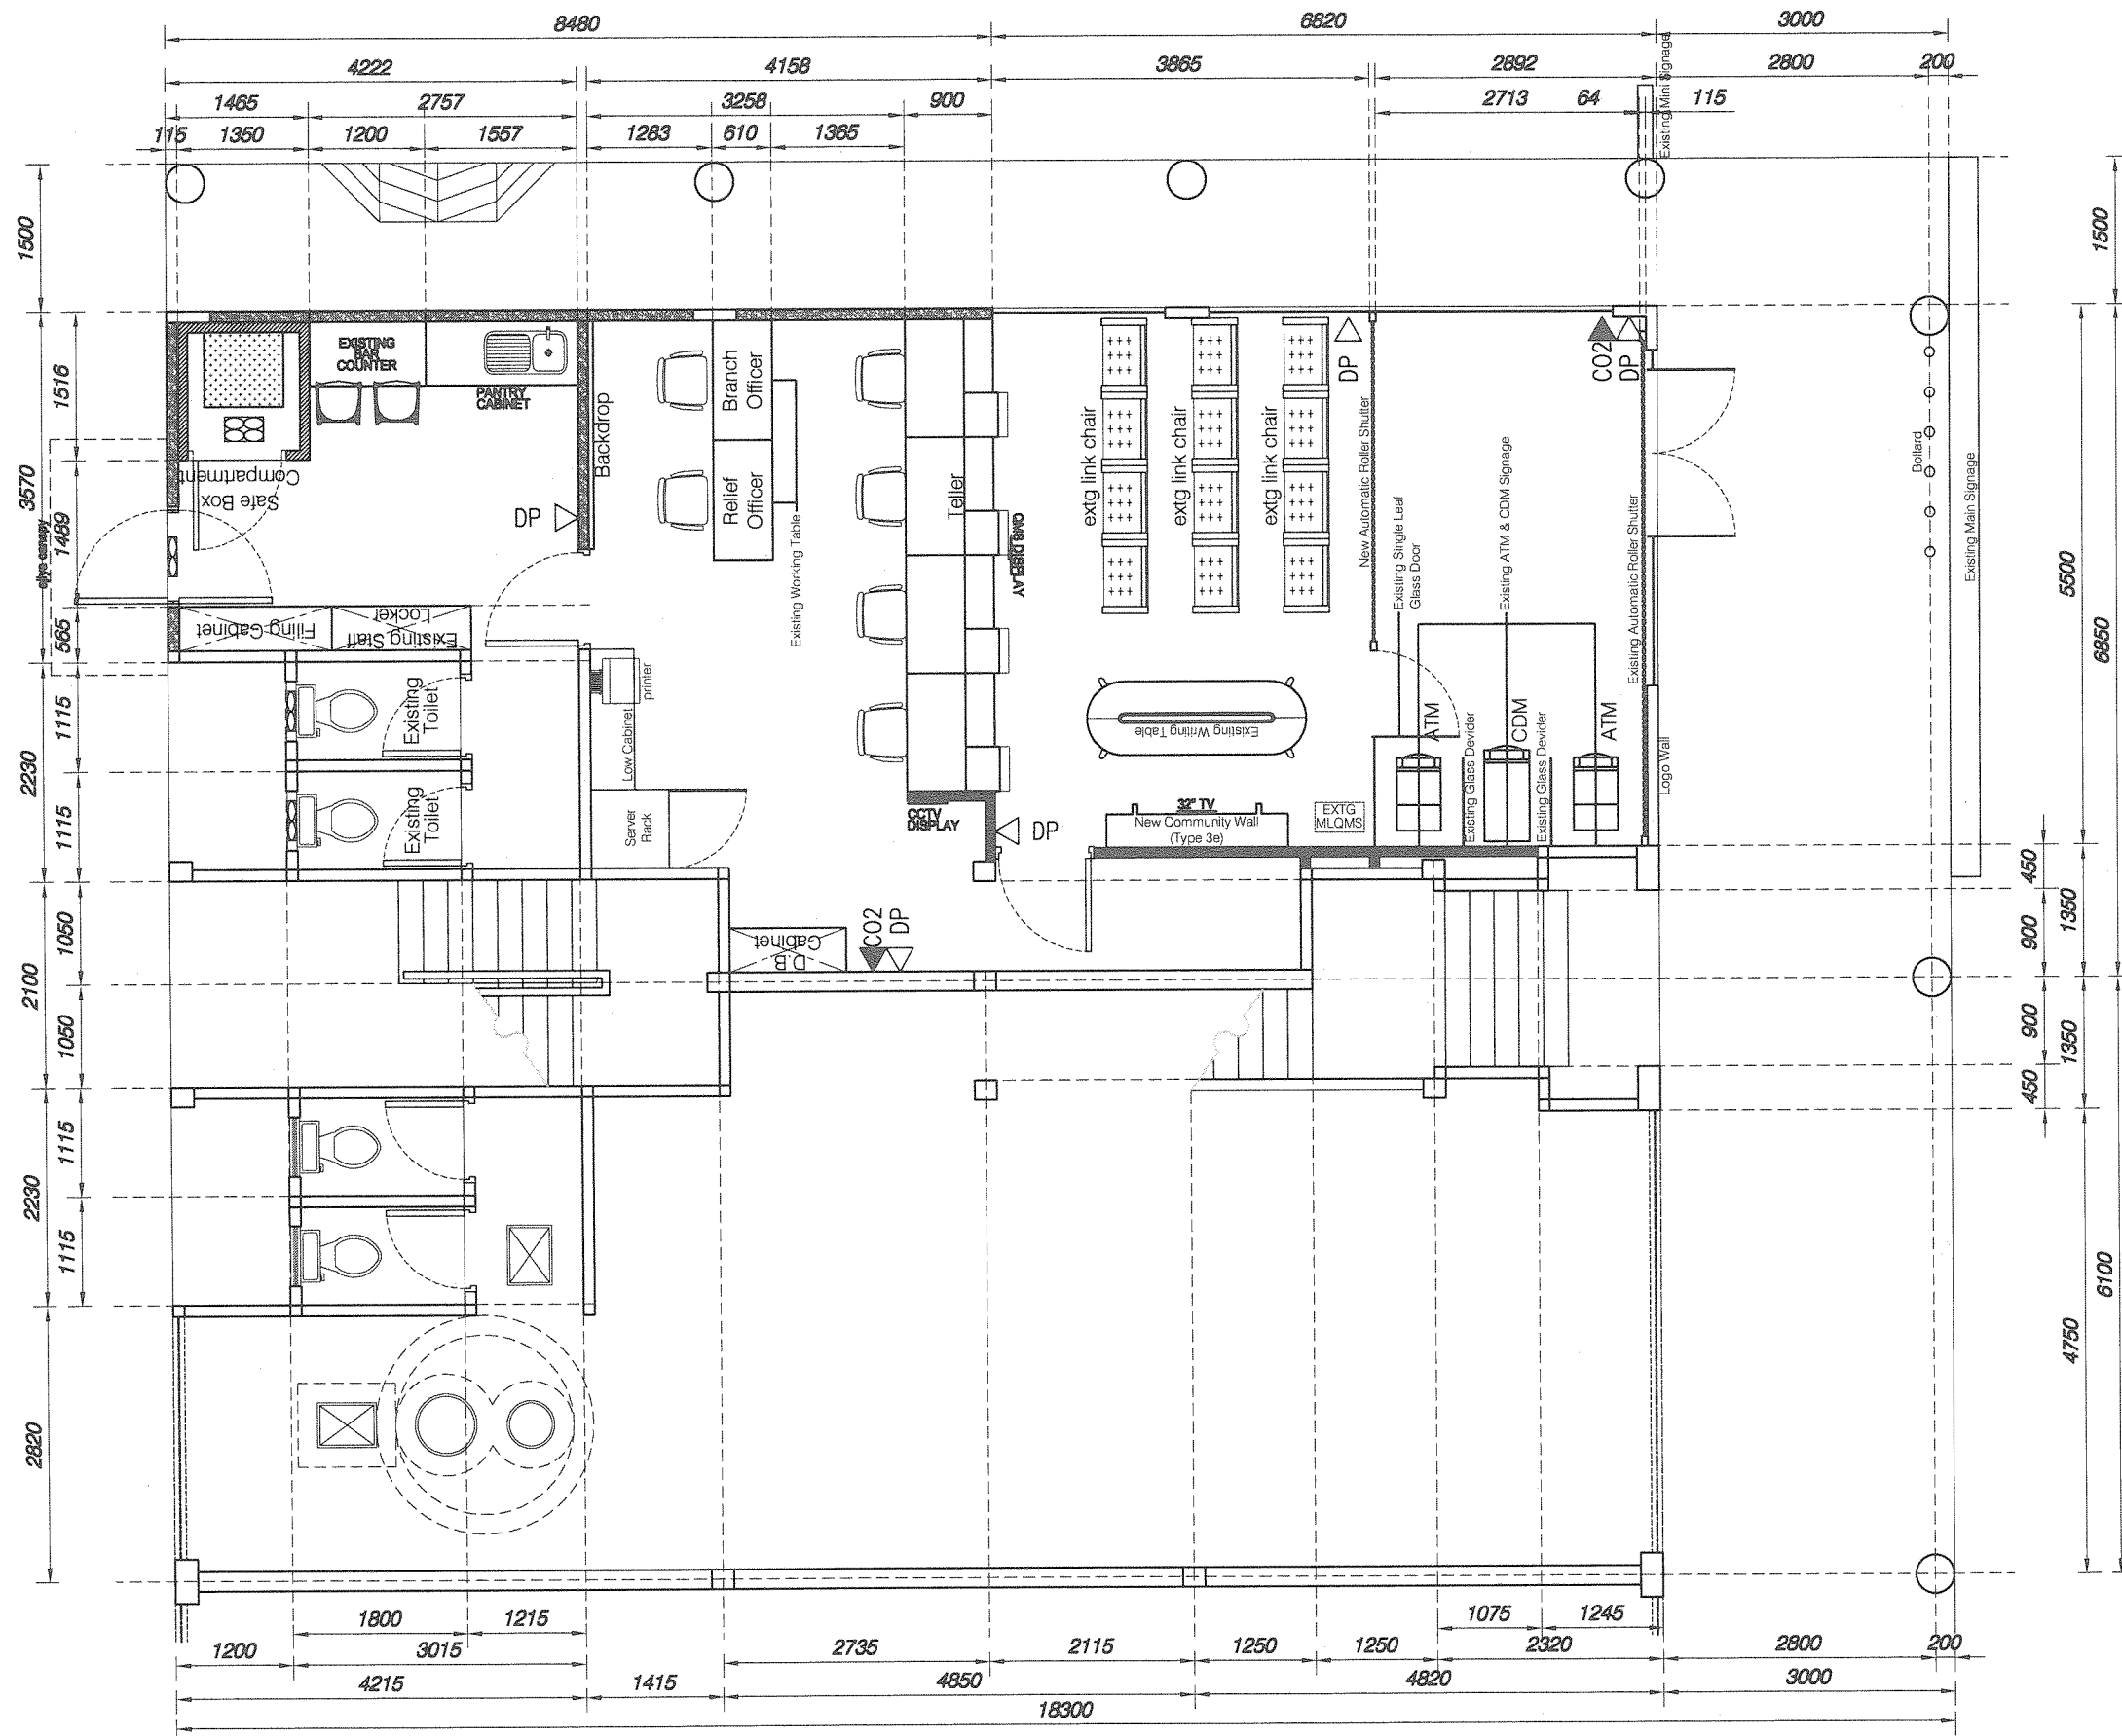

LEGENDS

- △DP Dry Powder (ABC)
- ▲CO2 Carbon Dioxide(5kg)

PROJECT TITLE:

PROPOSED INTERIOR FIT-OUT WORKS FOR
BANK SIMPANAN NASIONAL AT GROUND FLOOR & FIRST FLOOR,
LOT 625, KAPIT BAZAAR, JALAN SELIRIK, 96800 KAPIT, SARAWAK

FILE NO:
BSN/IP/JPAK/FD/2020-03


DATE: 170321
21/01
DRAWN BY: AYIE
SCALE: 1 : 75

ISSUE:
2

DWG TITLE:
GROUND FLOOR
FIRE FIGHTING LAYOUT PLAN
BRANCH NAME:
KAPIT, SARAWAK
DWG NO:
MECHANICAL SERVICES - 03


**PROPOSED INTERIOR FIT-OUT WORKS FOR BANK SIMPANAN
NASIONAL**

- TYPICAL DETAIL DRAWING

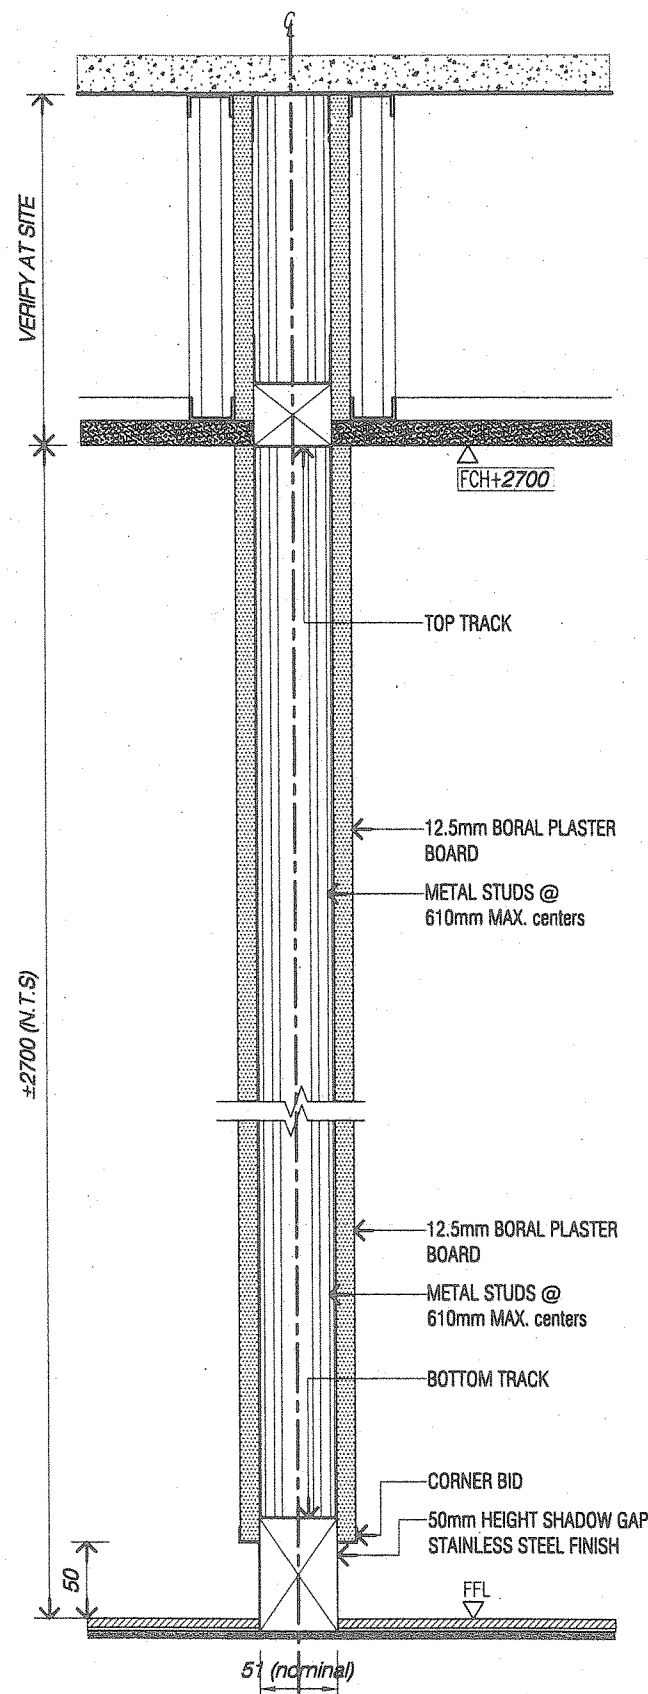

1 - NORMAL PARTITION
SCALE 1/5

New full height 76mm thick 'Normal Partition' with 12.5mm thick 'BORAL PLASTER BOARD' both sided finished to underside of ceiling with 51mm metal stud laid 610mm max. centers vertically c/w top and bottom track of partition.

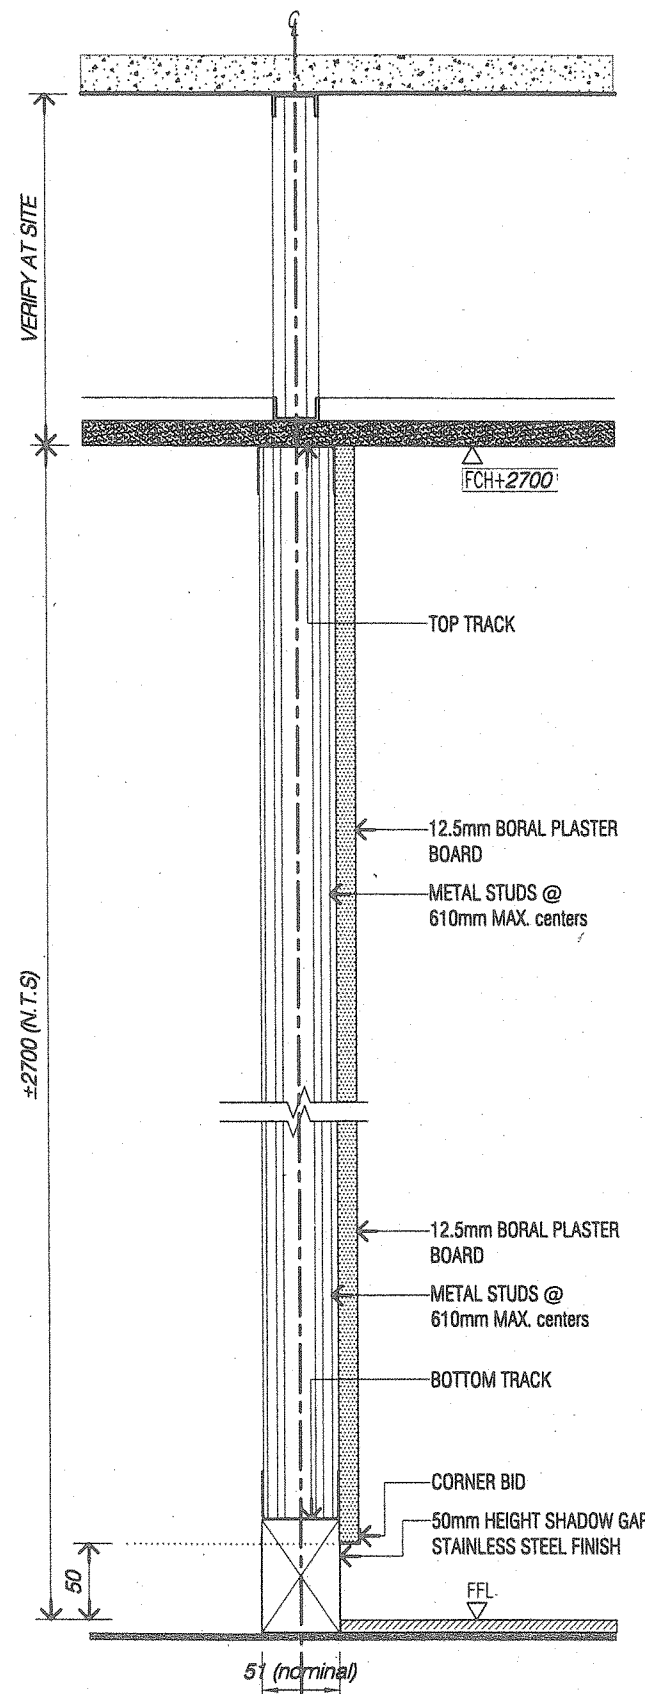

1A - SINGLE SIDED PARTITION
SCALE 1/5

New full height 76mm thick 'Normal Partition' with 12.5mm thick 'BORAL PLASTER BOARD' single sided finished to underside of ceiling with 51mm metal stud laid 600mm centers vertically c/w top and bottom track of partition.

PROJECT TITLE:

**PROPOSED INTERIOR FIT-OUT WORKS FOR
BANK SIMPANAN NASIONAL**

DWG NO:

S02-G-003

DATE:

150525

JOB NO:

15-1615

DRAWN BY:

AZH

CHECK BY:

AZH

SCALE:

AS SHOWN

ISSUE:

ISSUE FOR CONSTRUCTION


DATE

DESCRIPTION

DWG TITLE:


**PARTITION & WALL TYPE DETAILS
TYPE 1 & 1A**

SL + A Sdn. Bhd. retain copyright of all designs and data shown in this drawing. Written permission is required for any use and/or reproduction. All prints, specifications and copyrights are the property of SL + A Sdn. Bhd. and shall be returned on completion of works. Contractor to check dimensions on site and notify SL + A Sdn. Bhd. of discrepancies on site. Do not scale off drawings.

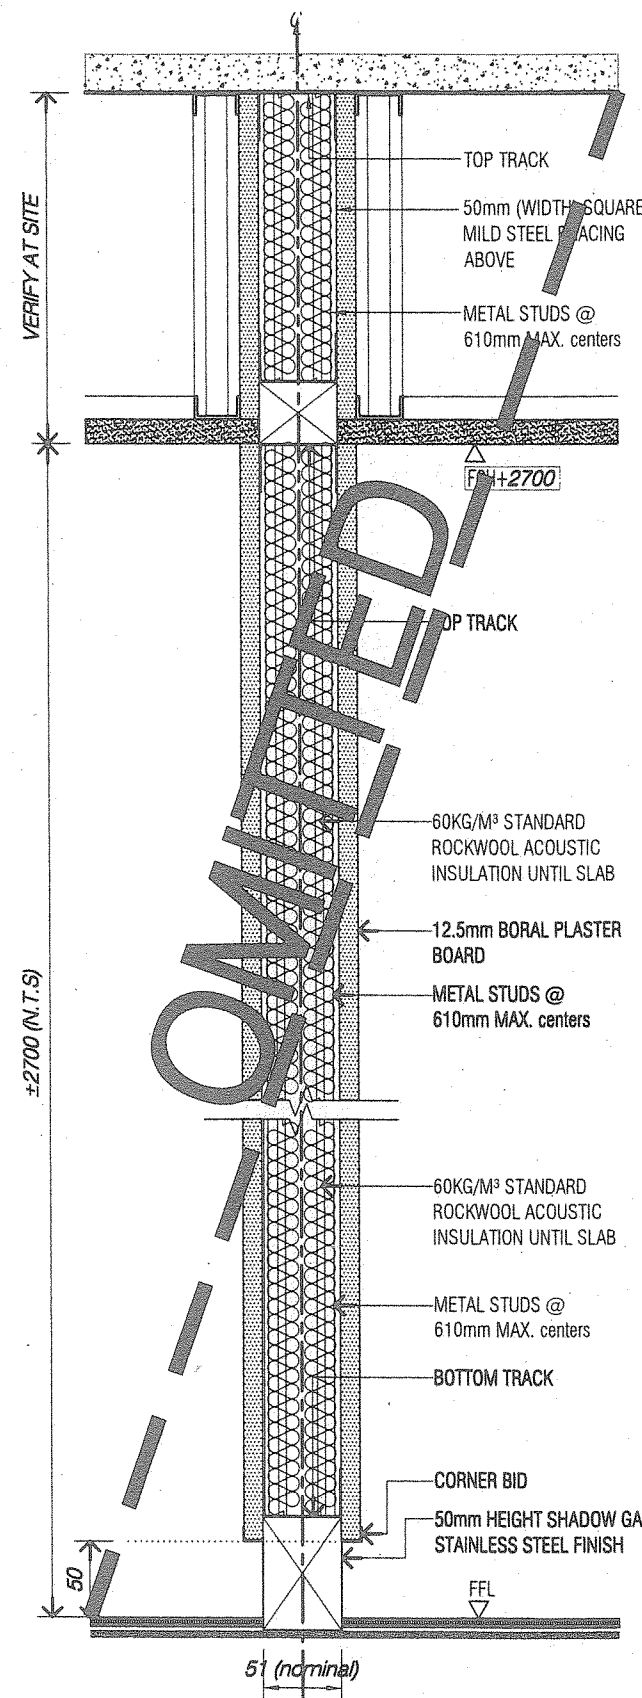


1B - SOUND RATED PARTITION
SCALE 1/5

New full height 76mm thick 'Soundrated Partition' with 12.5mm thick 'BORAL PLASTER BOARD' both sided finished from floor to ceiling and 76mm thick partition above ceiling with 12.5mm thick 'BORAL PLASTER BOARD' both sided finished from ceiling to slab with 51mm metal stud c/w top and bottom track of partition and 60kg/m³ rockwool acoustic insulation.

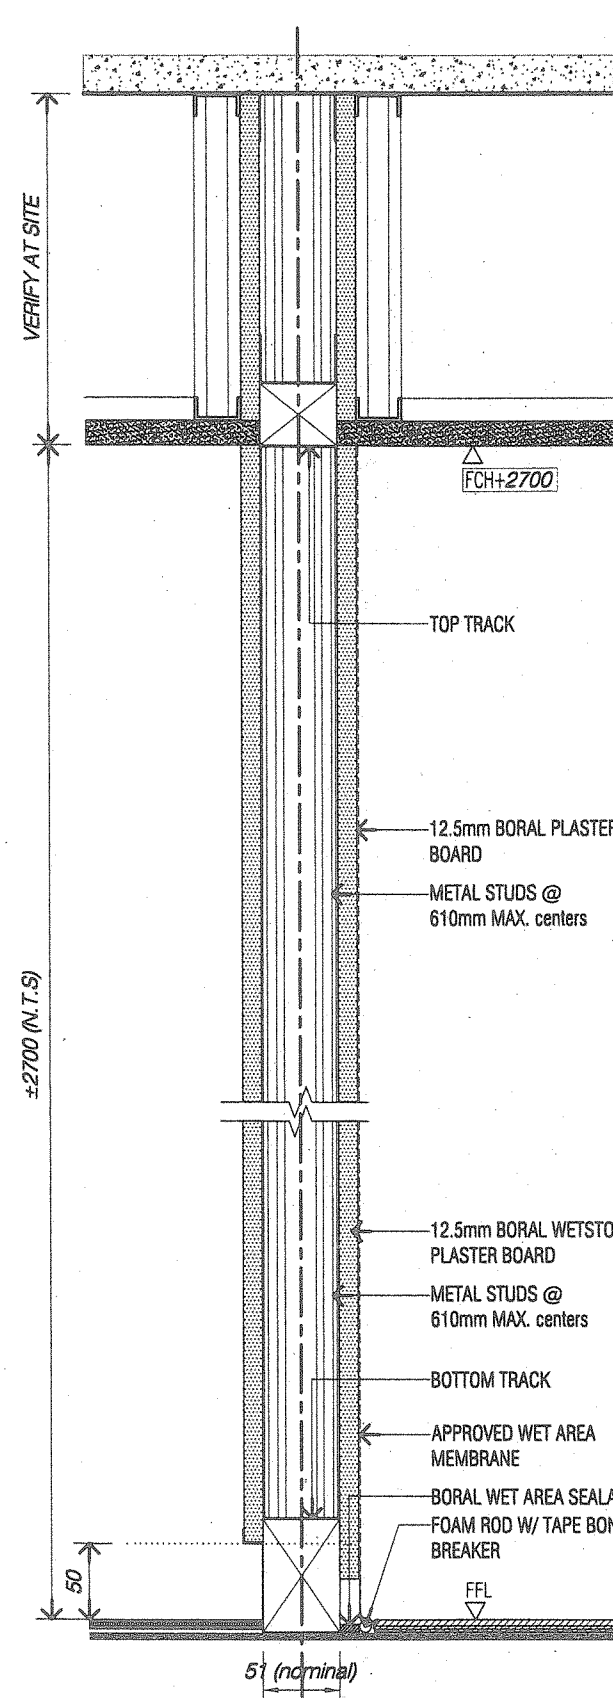

1C - WET RESISTANT PARTITION
SCALE 1/5

New full height 76mm thick 'Wetstop Partition' with 12.5mm thick 'BORAL WETSTOP PLASTER BOARD' single side finished and 12.5mm thick 'BORAL PLASTER BOARD' to underside of ceiling with 51mm metal stud laid 600mm centers vertically c/w top and bottom track of partition c/w approved wet area membrane and boral wet area sealant w/ foam rod and tape bond breaker.

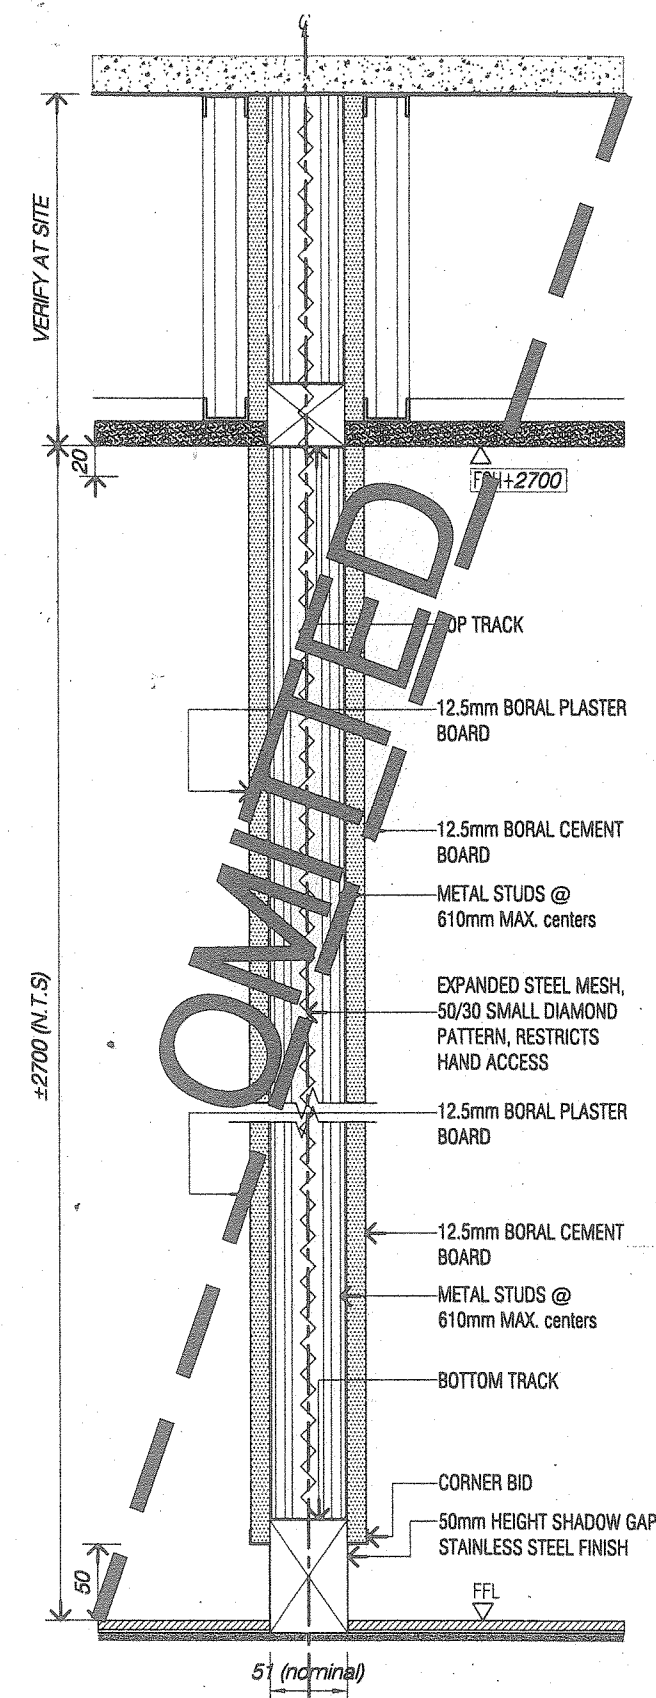

1D - CEMBOARD WITH EXPANDED STEEL MESH
SCALE 1/5

New full height 76mm thick 'Normal Partition' with 12.5mm thick 'BORAL PLASTER BOARD' at one side and 12.5mm thick CEMENT BOARD at ATM SIDE with both sided finished to underside of ceiling with 51mm metal stud laid 610mm max. centers vertically c/w top and bottom track of partition. to be sandwiched in between Expanded steel mesh, 50/30 small diamond pattern, restricts hand access to be install from floor to slab.

PROJECT TITLE:

**PROPOSED INTERIOR FIT-OUT WORKS FOR
BANK SIMPANAN NASIONAL**

DWG NO:

S02-G-003a

DATE:

150525

JOB NO:

15-1615

DRAWN BY:

AZH

CHECK BY:

AZH

SCALE:

AS SHOWN


ISSUE:

DWG TITLE:

PARTITION & WALL TYPE DETAILS


TYPE 1B, 1C & 1D

SL + A Sdn. Bhd. retain copyright of all designs and data shown in this drawing. Written permission is required for any use and/or reproduction. All prints, specifications and copyrights are the property of SL + A Sdn. Bhd. and shall be returned on completion of works. Contractor to check dimensions on site and notify SL + A Sdn. Bhd. of discrepancies on site. Do not scale off drawings.

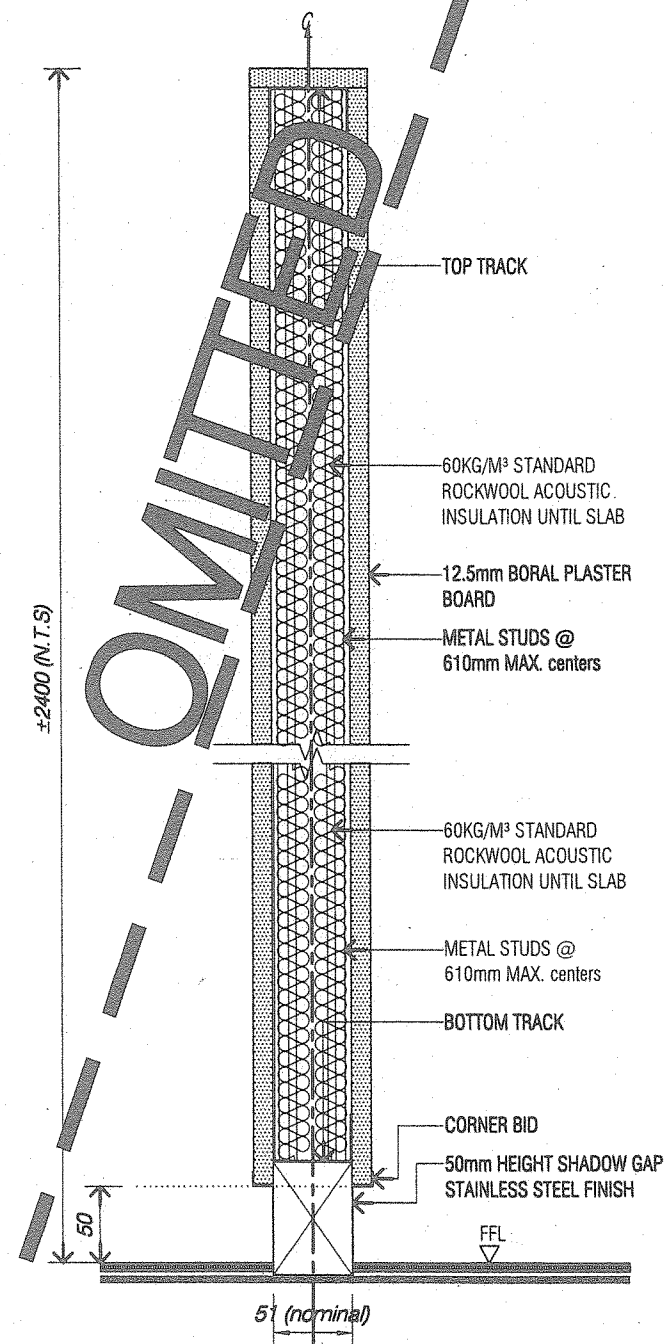

1E - NORMAL PARTITION
SCALE 1/5

New full height 76mm thick 'Normal Partition' with 12.5mm thick 'BORAL PLASTER BOARD' both sided finished from floor to 2400mm height with 51mm metal stud c/w top and bottom track of partition.

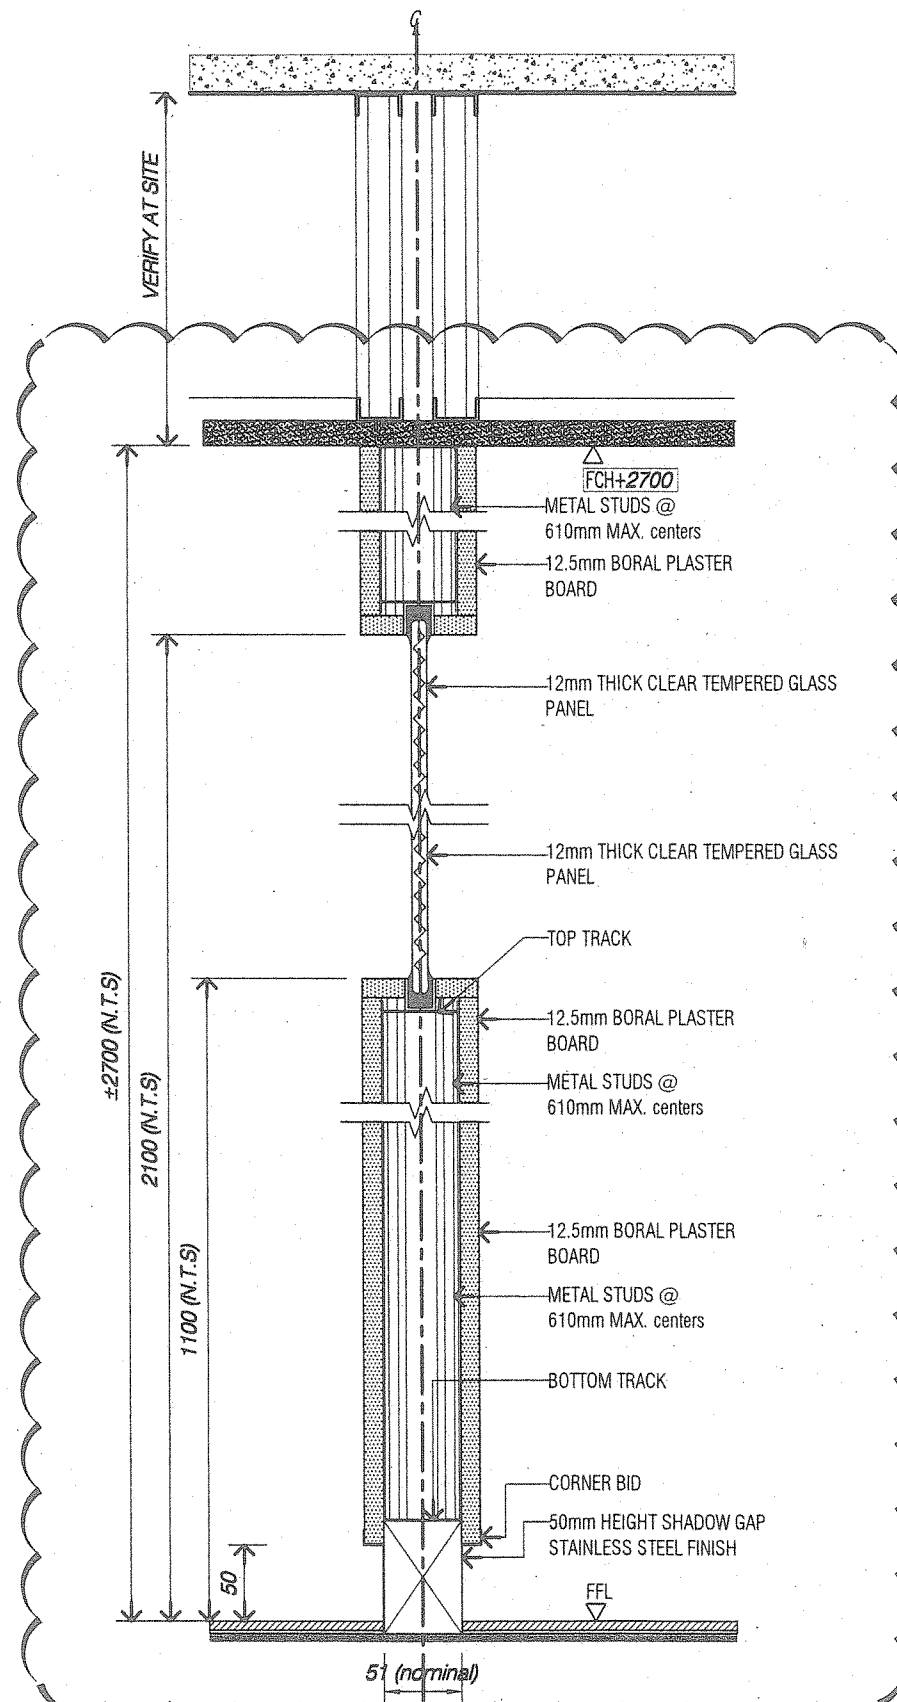

1F - NORMAL PARTITION + GLASS PARTITION
SCALE 1/5

New full height 76mm thick 'Normal Partition' with 12.5mm thick 'BORAL PLASTER BOARD' both sided finished to underside of 1100mm height with 51mm metal stud laid 610mm max. centers vertically c/w top and bottom track of partition with 12mm thick frameless glass panel up to ceiling 2400mm height.

PROJECT TITLE:

**PROPOSED INTERIOR FIT-OUT WORKS FOR
BANK SIMPANAN NASIONAL**

DATE	ISSUE	DESCRIPTION
	A	ISSUE FOR CONSTRUCTION

DWG NO:

S02-G-003b

DATE:

150525

JOB NO:

15-1615

DRAWN BY:

AZH

CHECK BY:

AZH

SCALE:


AS SHOWN

ISSUE:

DWG TITLE:


**PARTITION & WALL TYPE DETAILS
TYPE 1E & 1F**

SL + A Sdn. Bhd. retain copyright of all designs and data shown in this drawing. Written permission is required for any use and/or reproduction. All prints, specifications and copyrights are the property of SL + A Sdn. Bhd. and shall be returned on completion of works. Contractor to check dimensions on site and notify SL + A Sdn. Bhd. of discrepancies on site. Do not scale off drawings.

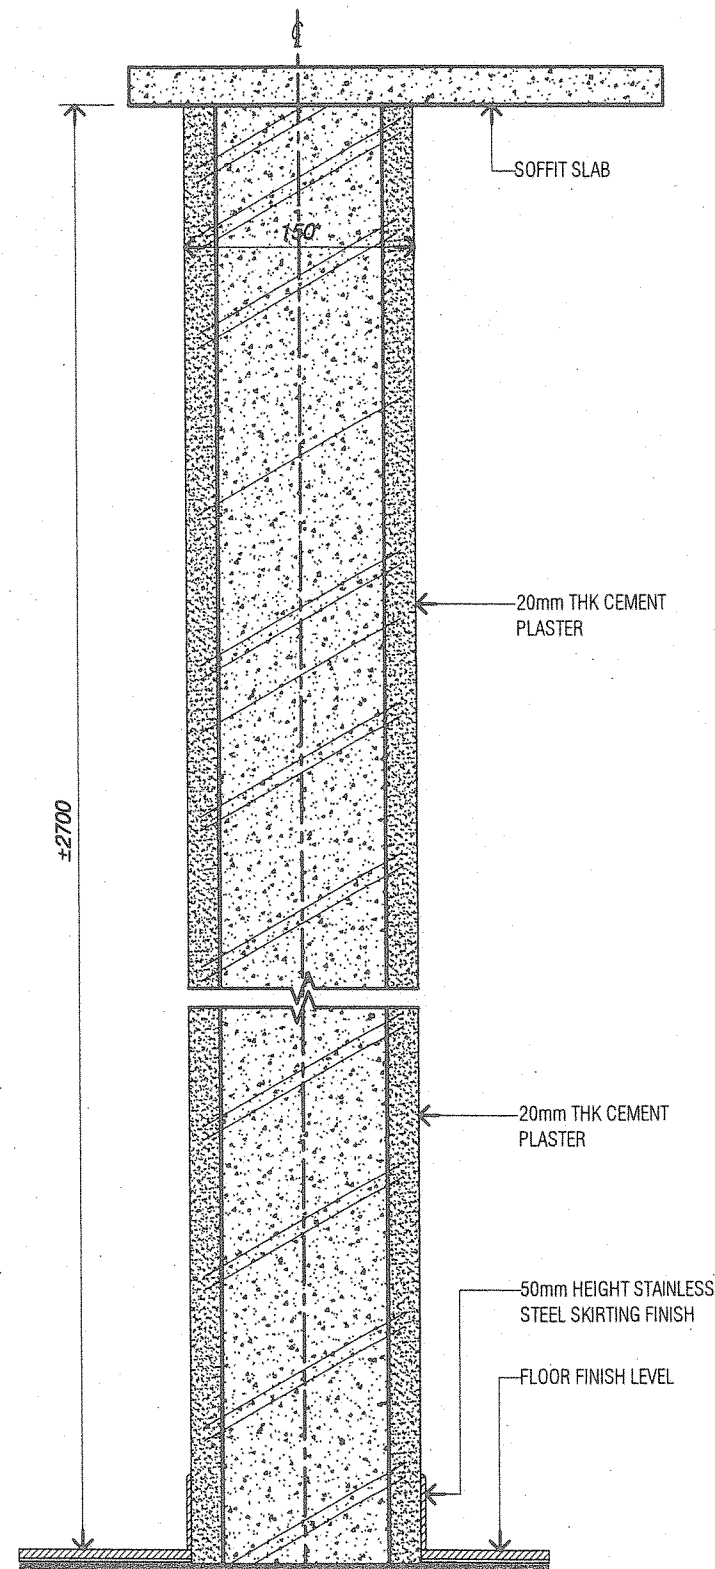

3- BRICK WALL
SCALE 1/5

New full height 150mm thick clay brick wall from floor until slab level with 600mm height waterproofing from floor

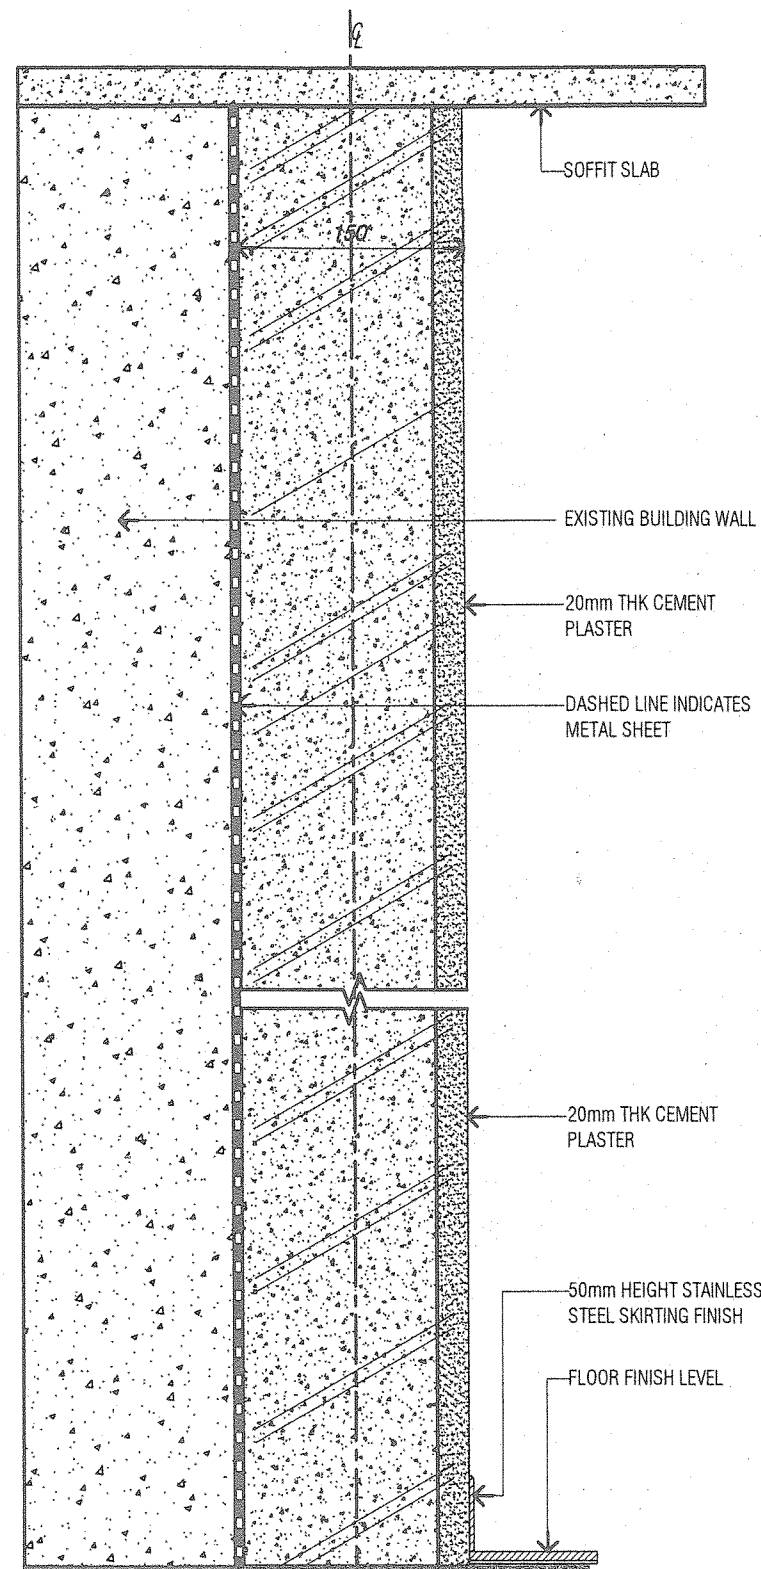

3A- BRICK WALL W/ METAL SHEET CLAD
SCALE 1/5

New full height 150mm thick clay brick wall from floor until slab level with 600mm height waterproofing from floor complete with 3mm THK metal sheet cladding before screeding & plastering work

PROJECT TITLE :

**PROPOSED INTERIOR FIT-OUT WORKS FOR
BANK SIMPANAN NASIONAL**

DATE	ISSUE	DESCRIPTION
	A	ISSUE FOR CONSTRUCTION

DWG NO :

S02-G-003d

SCALE :

AS SHOWN

DATE :

DRAWN BY :

150525

AZH

JOB NO :

15-1015


CHECK BY :

AZH

DWG TITLE :

**PARTITION & WALL TYPE DETAILS
TYPE 3 & 3A**

SL + A Sdn. Bhd. retain copyright of all designs and data shown in this drawing. Written permission is required for any use and/or reproduction. All prints, specifications and copyrights are the property of SL + A Sdn. Bhd. and shall be returned on completion of works. Contractor to check dimensions on site and notify SL + A Sdn. Bhd. of discrepancies on site. Do not scale off drawings.

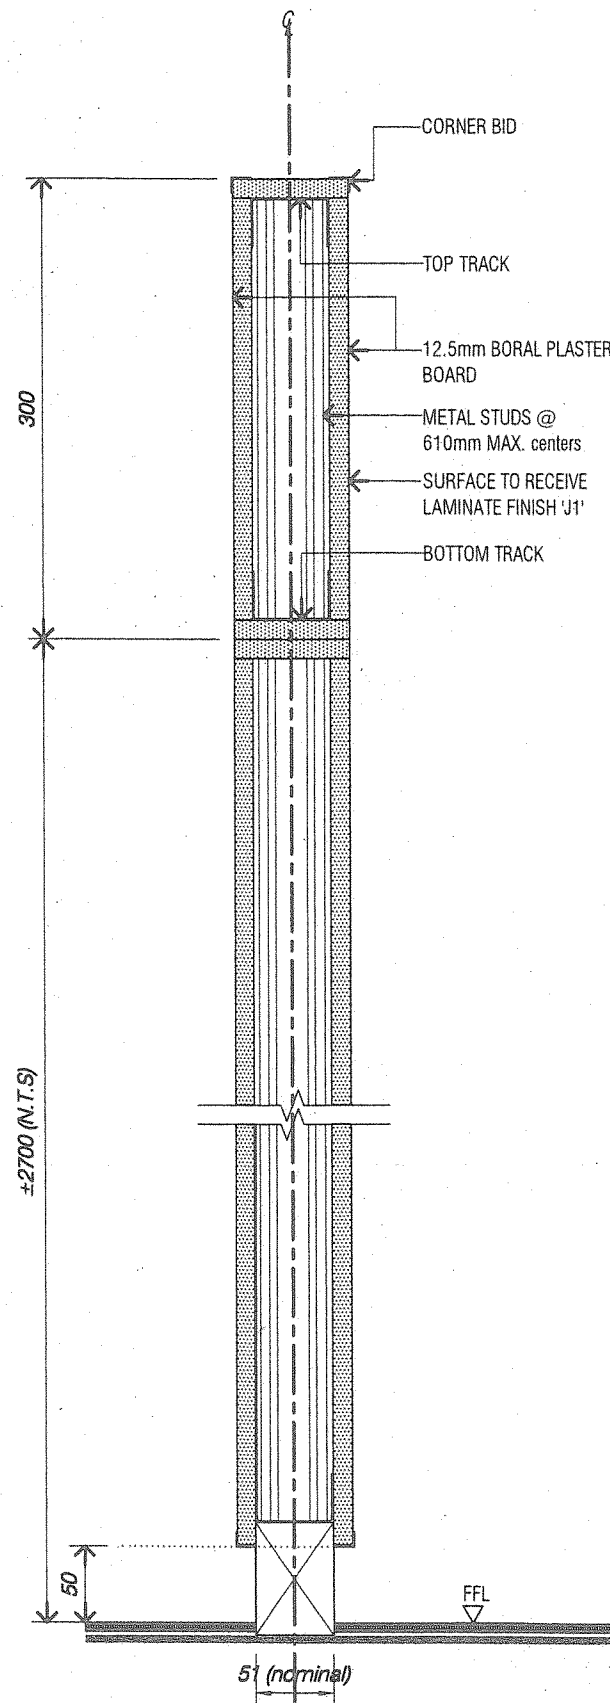

4 - LAMINATED PARTITION

SCALE 1/5

New full height 76mm thick 'Normal Partition' with 12.5mm thick 'BORAL PLASTER BOARD' both sided finished 300mm height above 2700mm height with 51mm metal stud c/w top and bottom track of partition in laminate finish "J1"

PROJECT TITLE:

PROPOSED INTERIOR FIT-OUT WORKS FOR
BANK SIMPANAN NASIONAL

DATE	ISSUE	DESCRIPTION
	A	ISSUE FOR CONSTRUCTION

DWG NO:

S02-G-0030

SCALE:

AS SHOWN

DATE:

150525

DRAWN BY:

AZH

JOB NO:

15-1615

CHECK BY:

AZH


DWG TITLE:

PARTITION & WALL TYPE DETAILS
TYPE 4

SL + A Sdn. Bhd. retain copyright of all designs and data shown in this drawing. Written permission is required for any use and/or reproduction. All prints, specifications and copyrights are the property of SL + A Sdn. Bhd. and shall be returned on completion of works. Contractor to check dimensions on site and notify SL + A Sdn. Bhd. of discrepancies on site. Do not scale off drawings.

DOOR TYPE A


ELEVATION SCALE 1/20

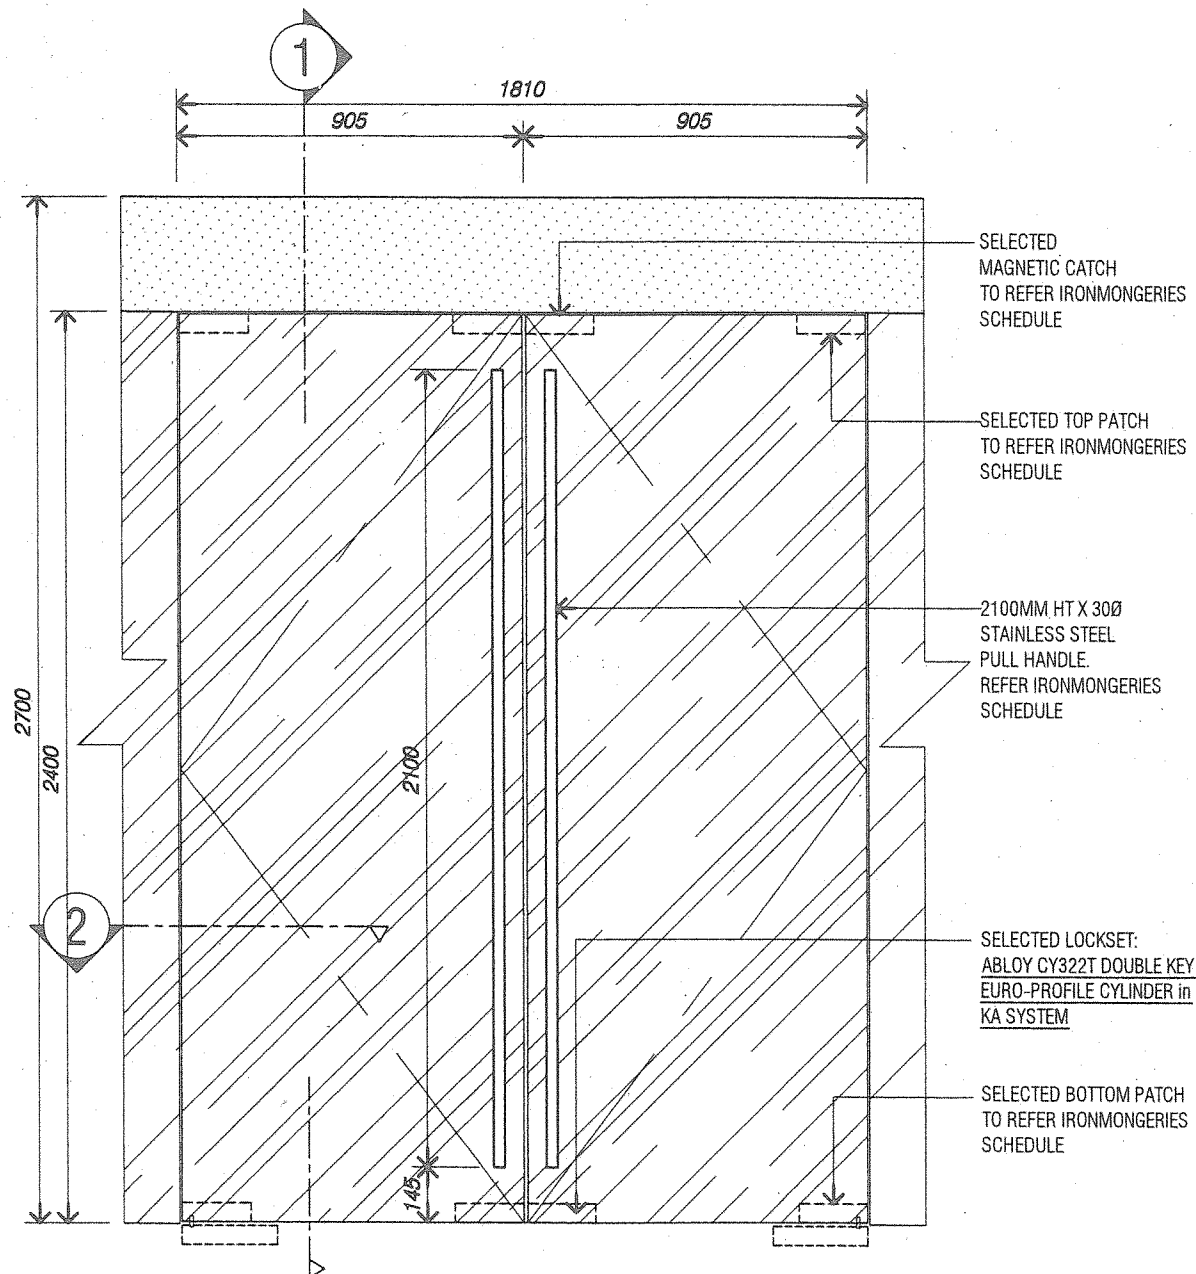

DOOR SIZE	1810mm (w) x 2400mm (ht)
DESCRIPTION	DOUBLE LEAF TEMPERED FRAMELESS GLASS DOOR
HARDWARE	SELECTED IRONMONGERY TO ID'S APPROVAL AND (refer ironmongery schedule specification)
FINISHES	FILM STICKER.
ACCESSORIES	WITH ABLOY LOCKSET SYSTEM

DOOR TYPE B

ELEVATION SCALE 1/20

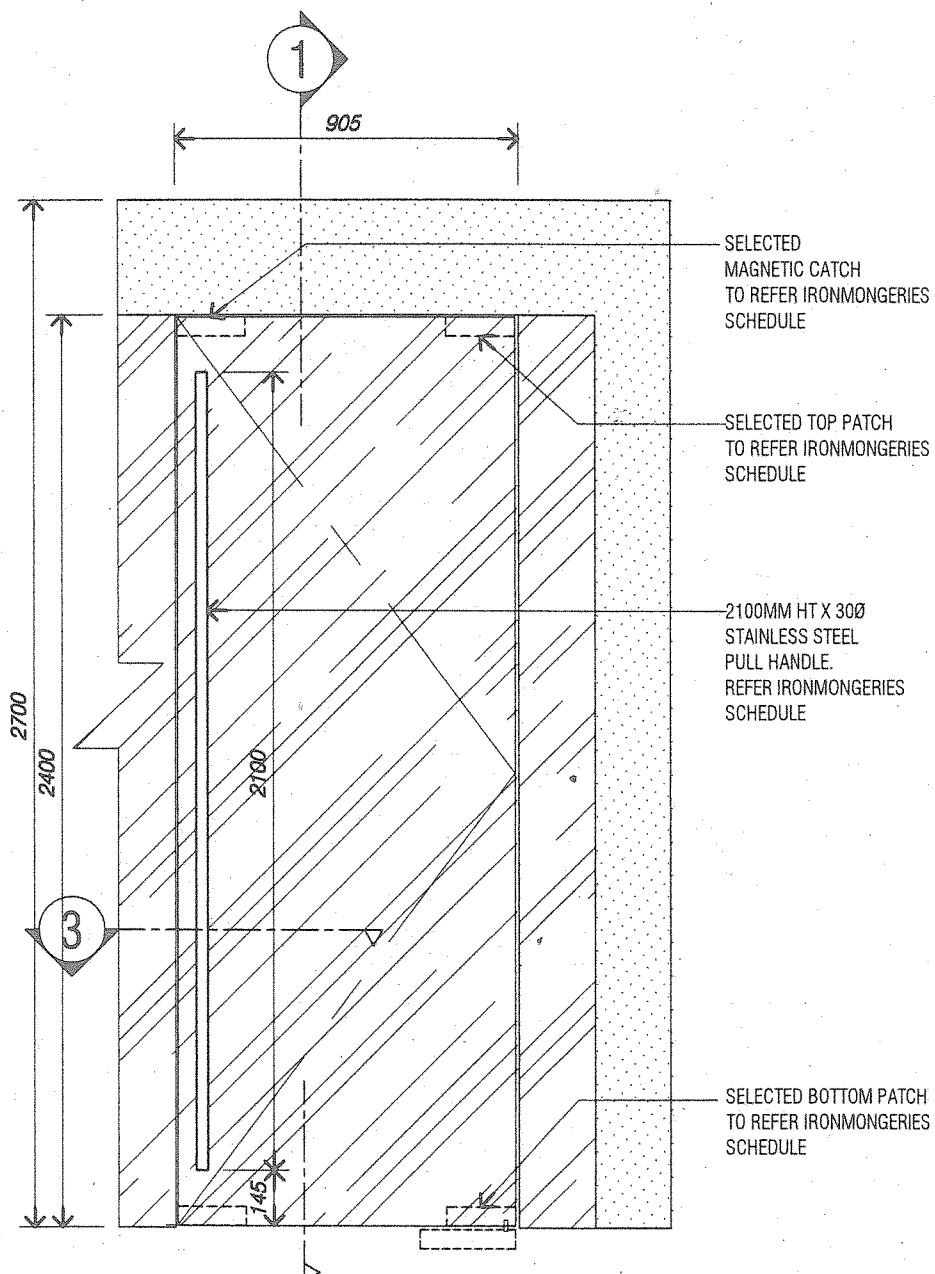


DOOR SIZE	900mm (w) x 2400 (ht)
DESCRIPTION	SINGLE LEAF TEMPERED FRAMELESS GLASS DOOR
HARDWARE	SELECTED IRONMONGERY TO ID'S APPROVAL AND (refer ironmongery schedule specification)
FINISH	FILM STICKER.
ACCESSORIES	-


PROJECT TITLE :
PROPOSED INTERIOR FIT-OUT WORKS FOR
BANK SIMPANAN NASIONAL

DWG NO : S02-G-005		SCALE : AS SHOWN		DWG TITLE : DOOR DETAIL - ELEVATIONS DOOR TYPE A & B	
DATE : 150525	DRAWN BY : AZH	ISSUE : A	DATE : 15-10-15	CHECK BY : AZH	DATE : 15-10-15
SL + A Sdn. Bhd. retain copyright of all designs and data shown in this drawing. Written permission is required for any use and/or reproduction. All prints, specifications and copyrights are the property of SL + A Sdn. Bhd. and shall be returned on completion of works. Contractor to check dimensions on site and notify SL + A Sdn. Bhd. of discrepancies on site. Do not scale off drawings.					

ELEVATION SCALE 1/20

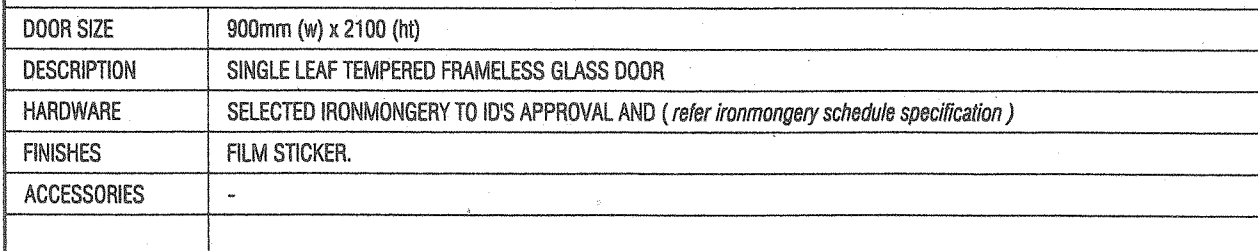

ELEVATION SCALE 1/20

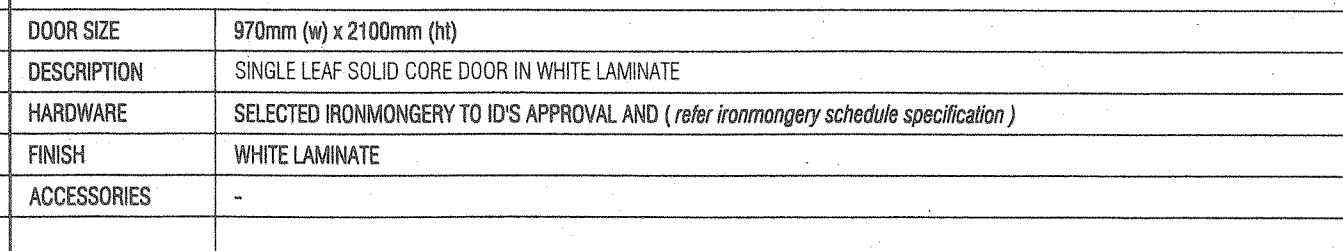

	A	ISSUE FOR CONSTRUCTION
DATE	ISSUE	DESCRIPTION

PROPOSED INTERIOR FIT-OUT WORKS FOR BANK SIMPANAN NASIONAL

H

SL + A Sdn. Bhd. retain copyright of all designs and data shown in this drawing. Written permission is required for any use and/or reproduction. All prints, specifications and copyrights are the property of SL + A Sdn. Bhd. and shall be returned on completion of works. Contractor to check dimensions on site and notify SL + A Sdn. Bhd. of any discrepancies on site. Do not scale off drawings.

DOOR SIZE	900mm (w) x 2100mm (ht)
DESCRIPTION	SINGLE LEAF HOLLOW CORE DOOR IN WHITE LAMINATE FINISH
HARDWARE	SELECTED IRONMONGERY TO ID'S APPROVAL AND (<i>refer ironmongery schedule specification</i>)
FINISH	WHITE LAMINATE
ACCESSORIES	VIEWING PANEL FOR DOOR TYPE Ea

DOOR SIZE	970mm (w) x 2100mm (ht)
DESCRIPTION	SINGLE LEAF HOLLOW CORE SLIDING DOOR IN WHITE LAMINATE
HARDWARE	SELECTED IRONMONGERY TO ID'S APPROVAL AND (<i>refer ironmongery schedule specification</i>)
FINISH	WHITE LAMINATE
ACCESSORIES	


	A	ISSUE FOR CONSTRUCTION
DATE	ISSUE	DESCRIPTION

PROPOSED INTERIOR FIT-OUT WORKS FOR BANK SIMPANAN NASIONAL


11

SL + A Sdn. Bhd. retain copyright of all designs and data shown in this drawing. Written permission is required for any use and/or reproduction. All prints, specifications and copyrights are the property of SL + A Sdn. Bhd. and shall be returned on completion of works. Contractor to check dimensions on site and notify SL + A Sdn. Bhd. of any discrepancies on site. Do not scale off drawings.

SCALE 1/20

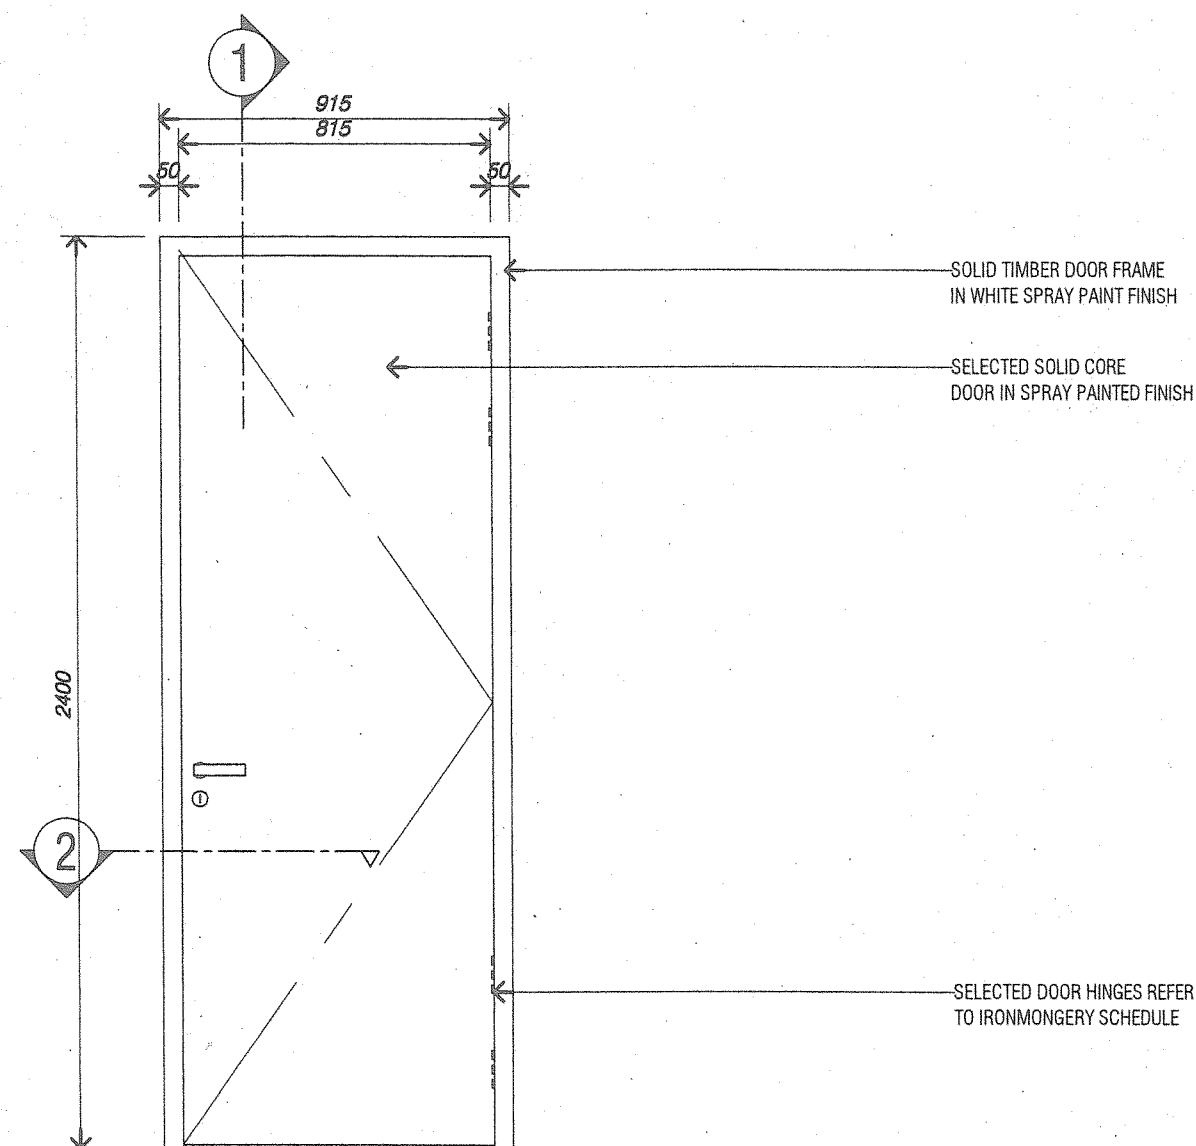

SCALE 1/20

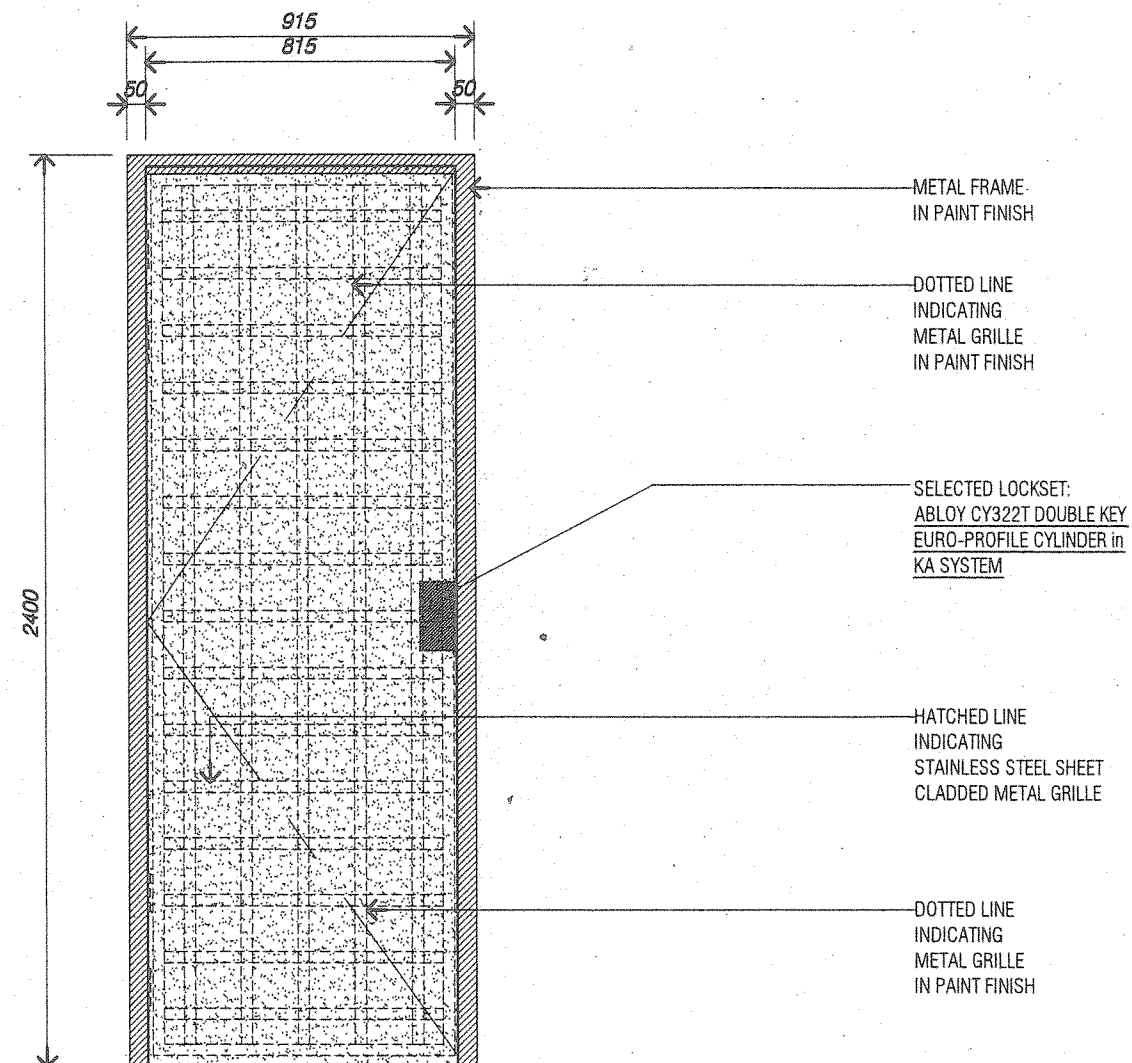

DOOR SIZE	915mm (w) x 2400 (ht)
DESCRIPTION	SINGLE LEAF SOLID CORE DOOR IN WHITE SPRAY PAINT FINISH FOR INSIDE AND METAL GRILLE WITH STAINLESS STEEL SHEET CLADDING FOR EXTERNAL.
HARDWARE	SELECTED IRONMONGERY TO ID'S APPROVAL AND (<i>refer ironmongery schedule specification</i>)
FINISH	WHITE SPRAY PAINT
ACCESSORIES	WITH ABLOY LOCKSET SYSTEM

	A	ISSUE FOR CONSTRUCTION
DATE	ISSUE DESCRIPTION	

PROJECT TITLE:

PROPOSED INTERIOR FIT-OUT WORKS FOR BANK SIMPANAN NASIONAL

DWG NO.:

S02-G-005C

DATE:

DRAWN BY:

150505

 Springer

150525

A2F

SCALE:

AS SHOWN

ISSUE:

1

III


DRUG TITLE :

DOOR DETAIL - ELEVATIONS
DOOR TYPE F

Si + A Sch

shown in this drawing. Written permission is required for any use and/or reproduction. All prints, specifications and copyrights are the property of SL + A Sdn. Bhd. and shall be returned on completion of works. Contractor to check dimensions on site and notify SL + A Sdn. Bhd. of discrepancies on site. Do not scale off drawings.

SCALE 1/20

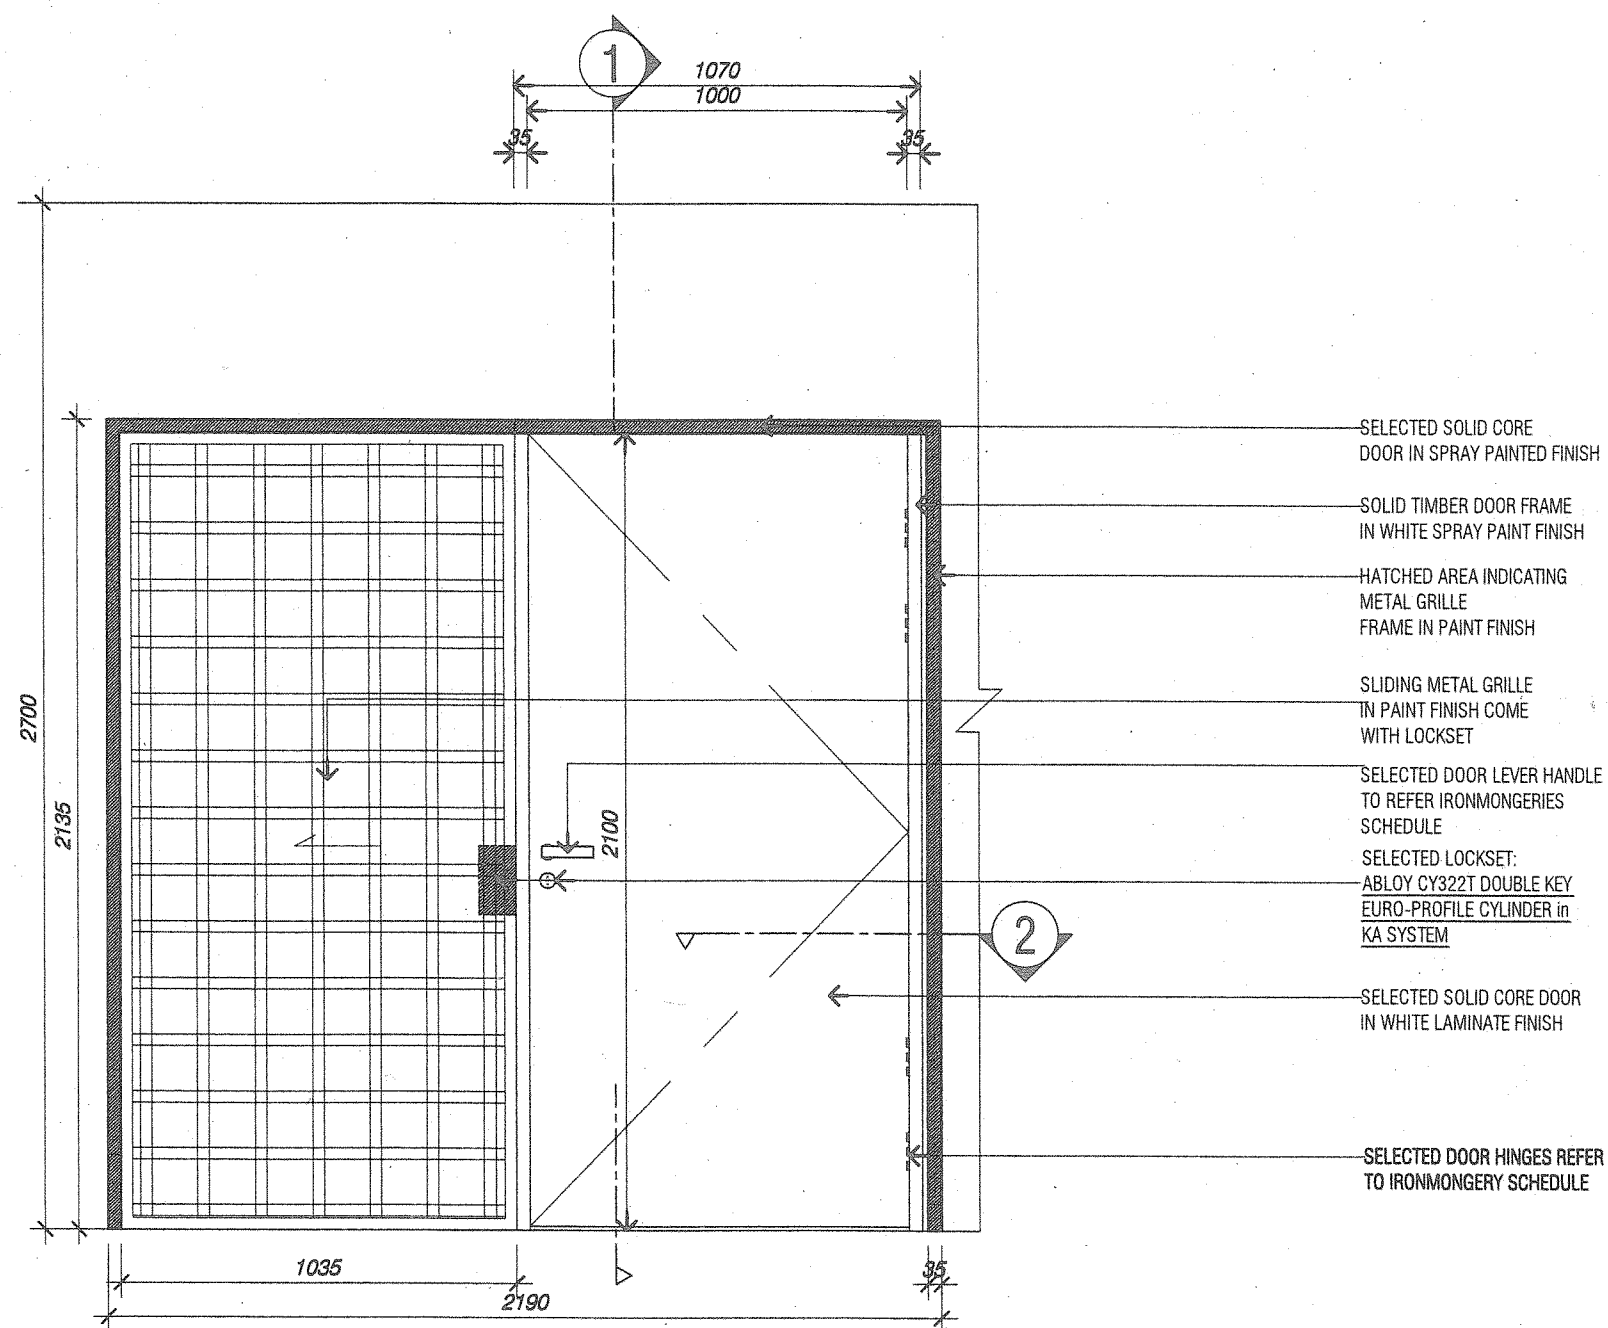

DOOR SIZE	SOLID CORE DOOR: 1000 (w) x 2100mm (ht), SLIDING METAL GRILLE: 1035 (w) x 2135 (ht)
DESCRIPTION	SINGLE LEAF SOLID CORE DOOR IN WHITE LAMINATE FINISH AND SLIDING METAL GRILLE IN PAINT FINISH
HARDWARE	SELECTED IRONMONGERY TO ID'S APPROVAL AND (<i>refer ironmongery schedule specification</i>)
FINISH	WHITE LAMINATE
ACCESSORIES	WITH ABLOY LOCKSET SYSTEM

	A	ISSUE FOR CONSTRUCTION
DATE	ISSUE	DESCRIPTION

PROJECT TITLE:

PROPOSED INTERIOR FIT-OUT WORKS FOR BANK SIMPANAN NASIONAL

DWG NO :

S02-G-005D

DATE:
150525

JOB NO:
15-16

SCALE:

AS SHOWN

ISSUE:

1

100


DWG TITLE:

DOOR DETAIL - ELEVATIONS
DOOR TYPE G.

SL + A Sdn. Bhd. retain copyright of all designs and data shown in this drawing. Written permission is required for any use and/or reproduction. All prints, specifications and copyrights are the property of SL + A Sdn. Bhd. and shall be returned on completion of works. Contractor to check dimensions on site and notify SL + A Sdn. Bhd. of discrepancies on site. Do not scale off drawings.

DOOR TYPE H


ELEVATION SCALE 1/20

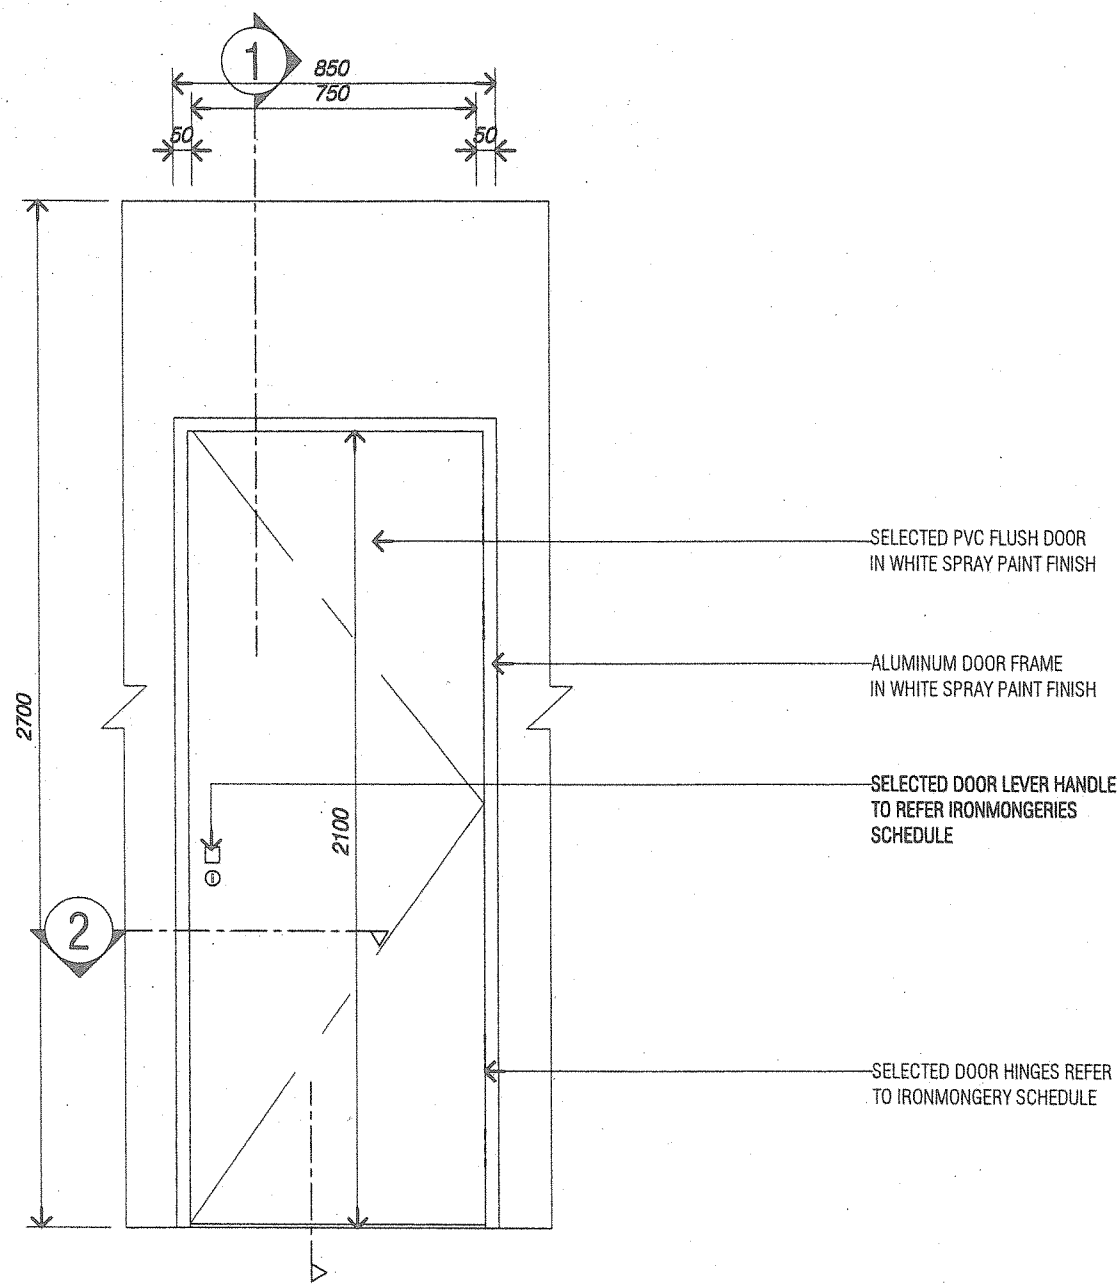

DOOR SIZE	850mm (w) x 2100mm (ht)
DESCRIPTION	SINGLE LEAF PVC FLUSH DOOR IN WHITE SPRAY PAINT FINISH
HARDWARE	SELECTED IRONMONGERY TO ID'S APPROVAL AND (<i>refer ironmongery schedule specification</i>)
FINISH	SPRAY PAINT FINISH TO MATCH
ACCESSORIES	

DOOR TYPE K

ELEVATION SCALE 1/20

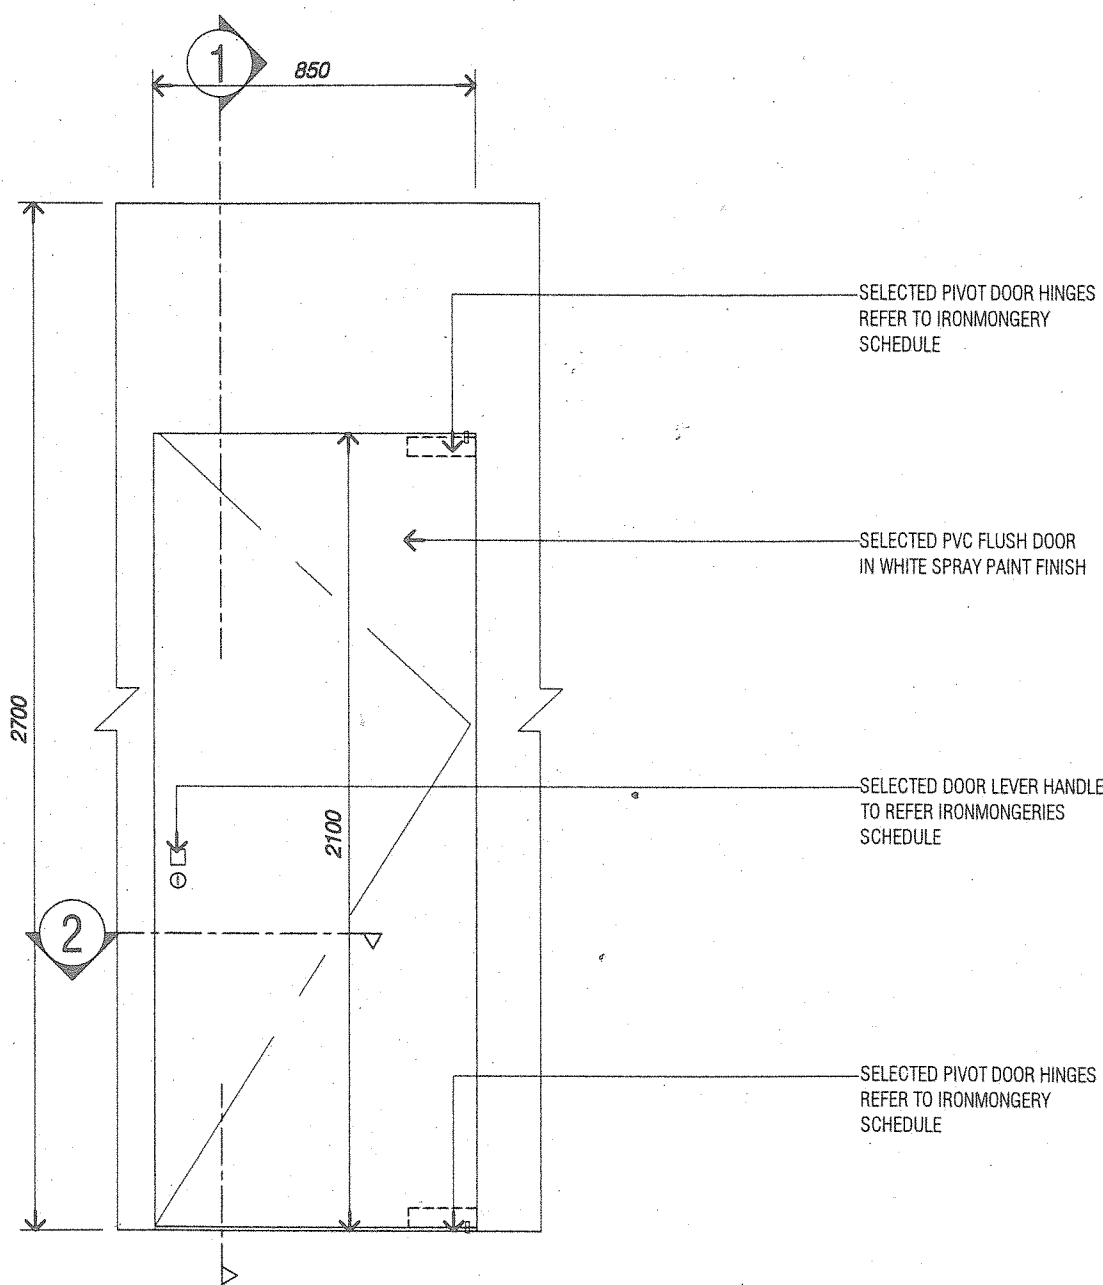

DOOR SIZE	850mm (w) x 2100mm (ht)
DESCRIPTION	SINGLE LEAF HOLLOW CORE DOOR IN WHITE SPRAY PAINT FINISH
HARDWARE	SELECTED IRONMONGERY TO ID'S APPROVAL AND (<i>refer ironmongery schedule specification</i>)
FINISH	SPRAY PAINT FINISH
ACCESSORIES	


PROJECT TITLE:
PROPOSED INTERIOR FIT-OUT WORKS FOR
BANK SIMPANAN NASIONAL

DWG NO:
S02-G-005E
DATE: 150525
JOB NO: 15-1015

DRAWN BY: AZH
CHECK BY: AZH

SCALE:
AS SHOWN

DWG TITLE:
**DOOR DETAIL - ELEVATIONS
DOOR TYPE H & K**
SL + A Sdn. Bhd. retain copyright of all designs and data shown in this drawing. Written permission is required for any use and/or reproduction. All prints, specifications and copyrights are the property of SL + A Sdn. Bhd. and shall be returned on completion of works. Contractor to check dimensions on site and notify SL + A Sdn. Bhd. of discrepancies on site. Do not scale off drawings.

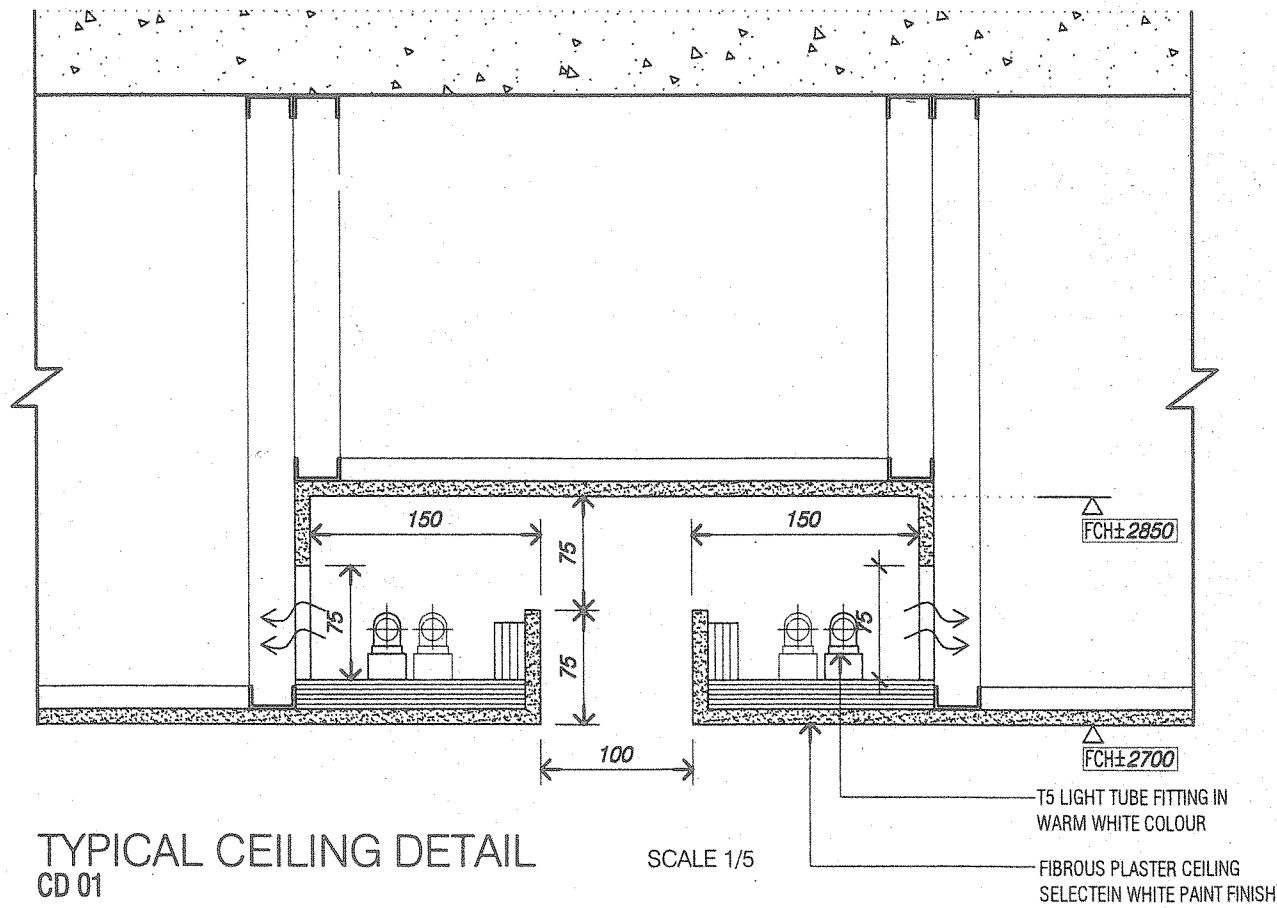

PROJECT TITLE :

PROPOSED INTERIOR FIT-OUT WORKS FOR BANK SIMPANAN NASIONAL

DWG NO :

SD3-E-003

DATE :

150525

JOB NO :

15-1015

DRAWN BY :

AZH

CHECK BY :

AZH

SCALE :

AS SHOWN

ISSUE :


B

DWG TITLE :

TYPICAL CEILING DETAIL

SL + A Sdn. Bhd. retain copyright of all designs and data shown in this drawing. Written permission is required for any use and/or reproduction. All prints, specifications and copyrights are the property of SL + A Sdn. Bhd. and shall be returned on completion of works. Contractor to check dimensions on site and notify SL + A Sdn. Bhd. of discrepancies on site. Do not scale off drawings.


DATE	ISSUE/DESCRIPTION
150604	B (ISSUE FOR CONSTRUCTION (REVISION 01))
150525	A (ISSUE FOR CONSTRUCTION)

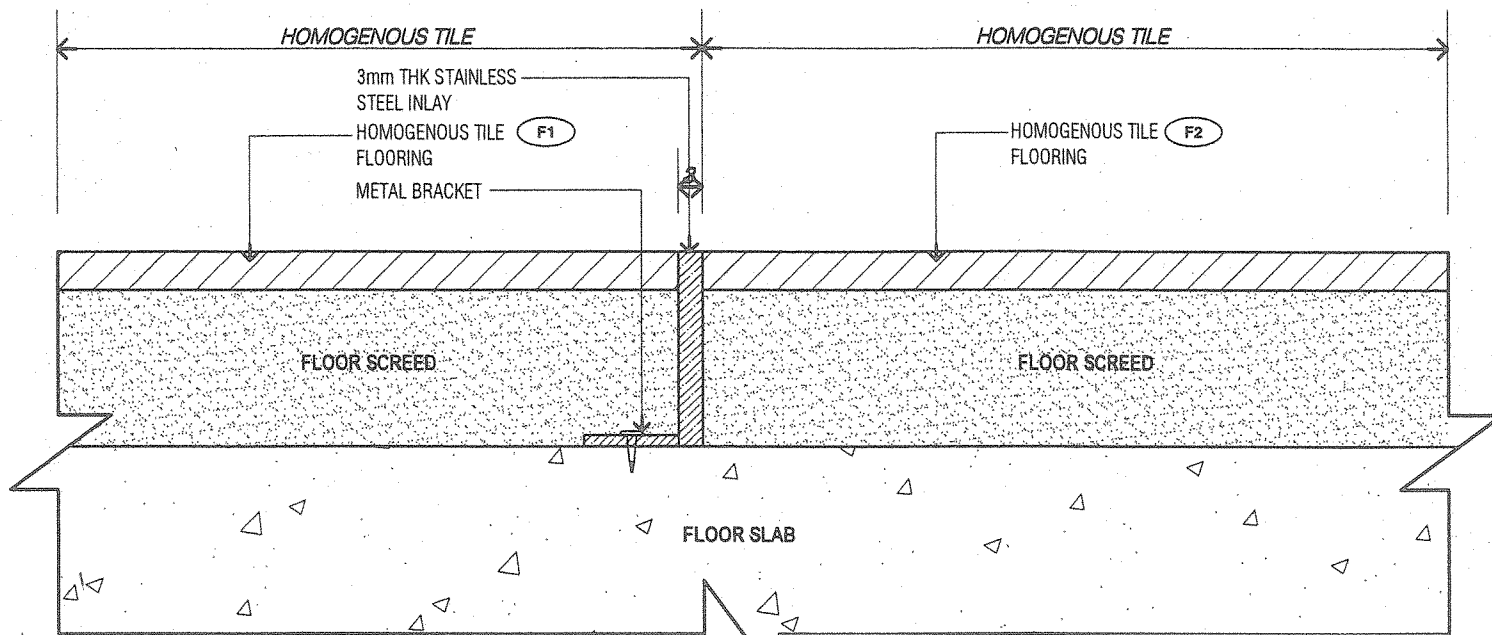

TYPICAL FLOOR DETAIL
FD 02

SCALE 1/5


HOMOGENOUS TILE TO HOMOGENOUS TILE
FLOOR DETAIL

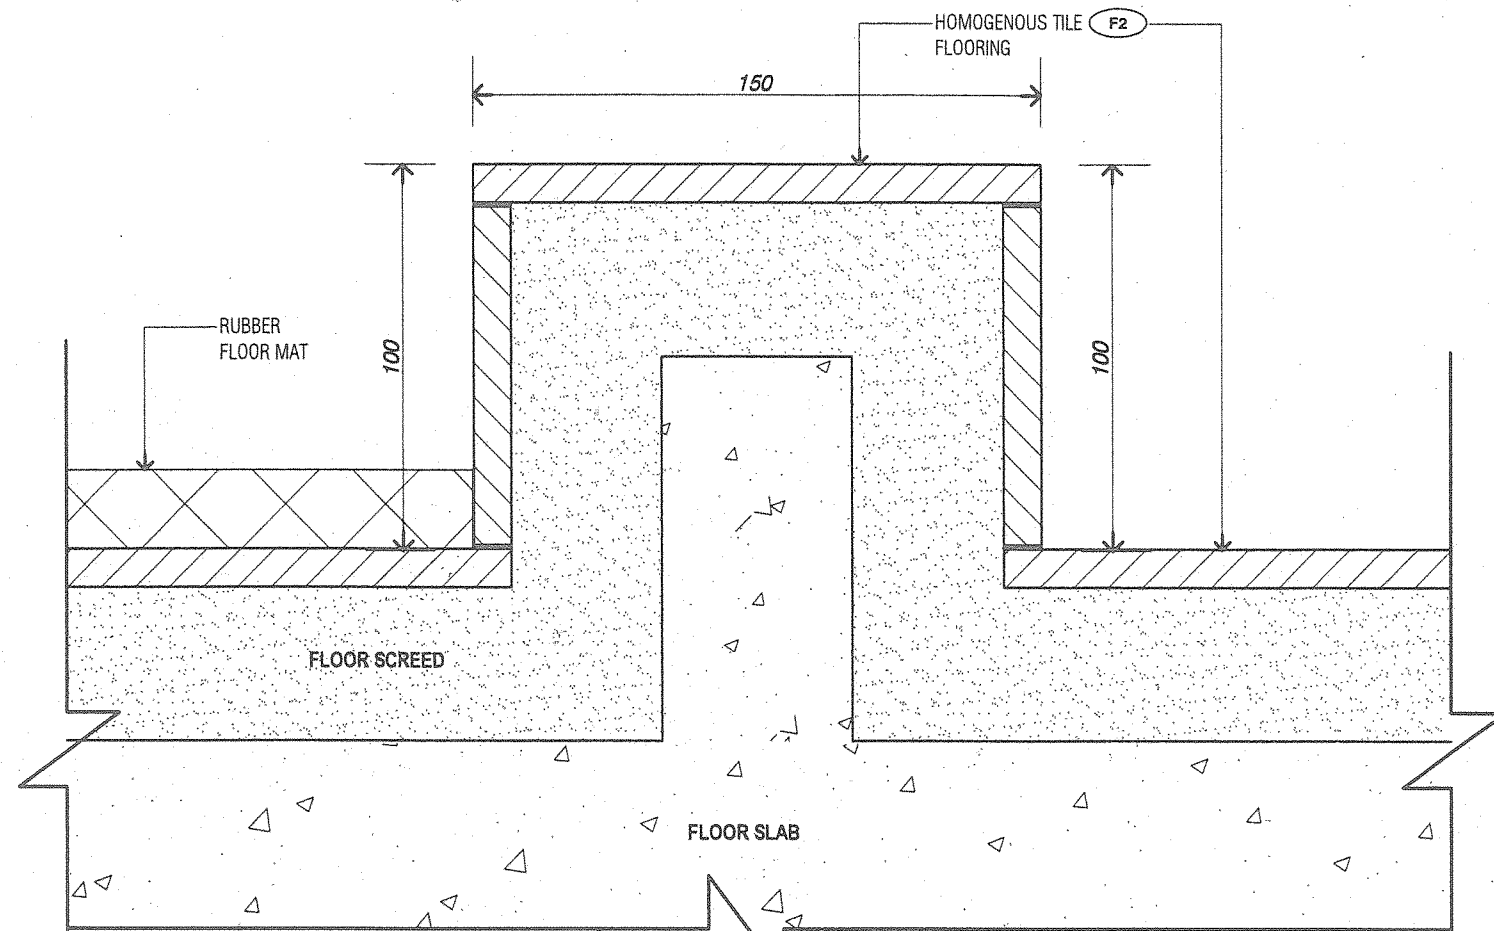

TYPICAL FLOOR DETAIL
FD 04

SCALE 1/5


HOMOGENOUS TILE TO HOMOGENOUS TILE
FLOOR DETAIL (SURAU @ ABLUTION AREA)

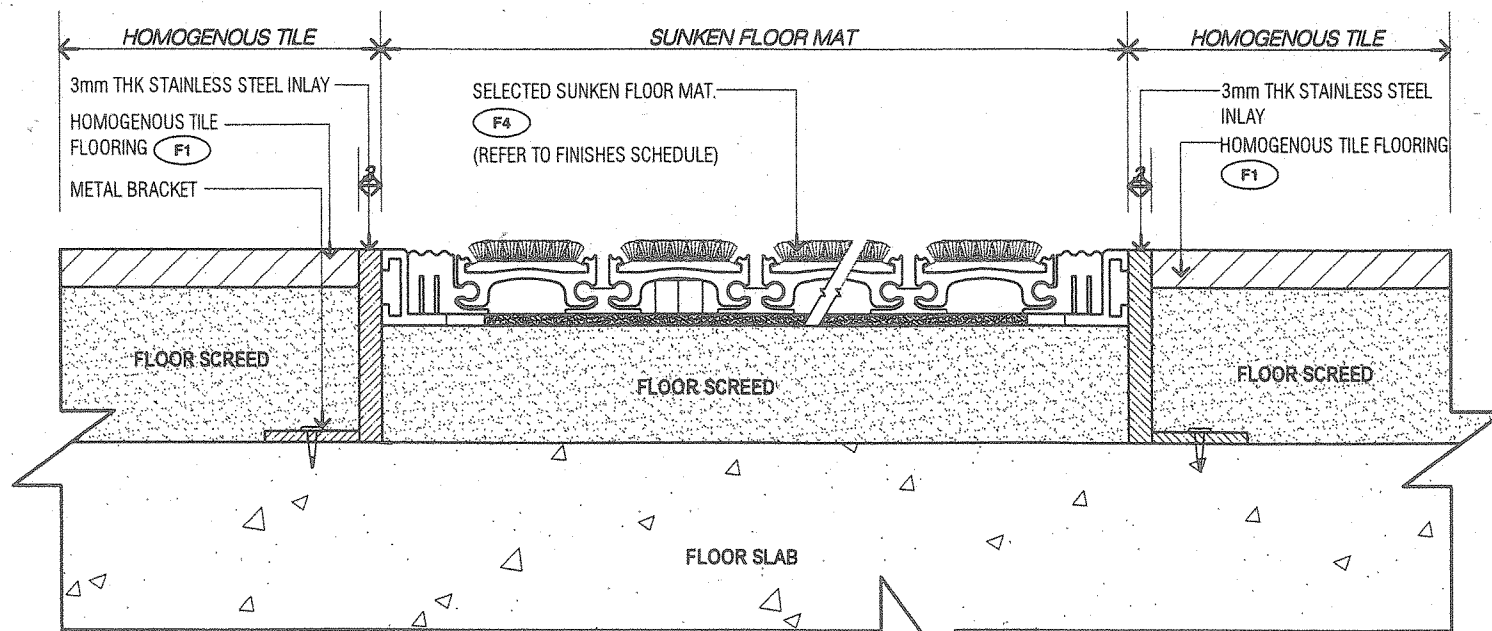

TYPICAL FLOOR DETAIL
FD 01

SCALE 1/5

SUNKEN FLOOR MAT TO HOMOGENOUS TILE
FLOOR DETAIL

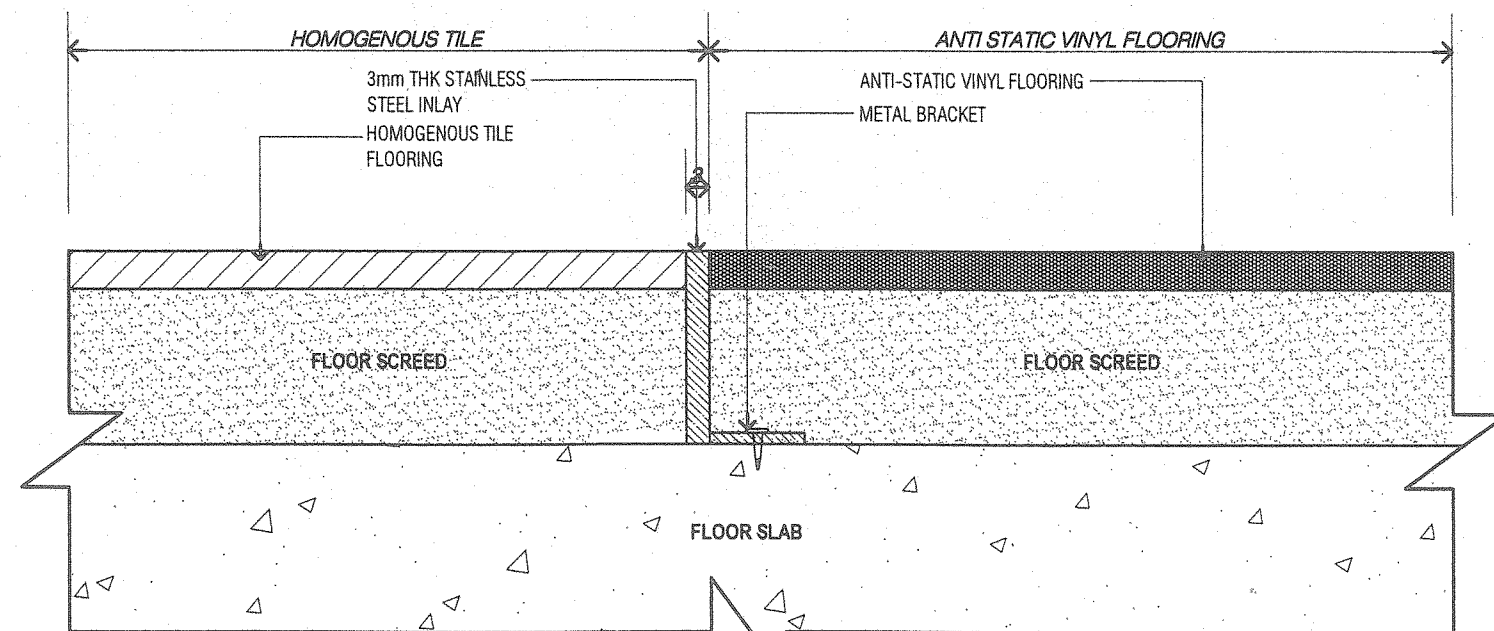

TYPICAL FLOOR DETAIL
FD 03

SCALE 1/5

HOMOGENOUS TILE TO ANTI STATIC VINYL FLOORING

PROJECT TITLE:

PROPOSED INTERIOR FIT-OUT WORKS FOR
BANK SIMPANAN NASIONAL

NO.	REVISION	DATE	DESCRIPTION
150524	B		ISSUE FOR CONSTRUCTION (REVISION 01)
150525	A		ISSUE FOR CONSTRUCTION
DATE	ISSUE DESCRIPTION		

DWG NO:
S04-G-002

DATE: 150525 DRAWN BY: AZH

JOB NO: 15-1615 CHECK BY: AZH


SCALE:
AS SHOWN

ISSUE:

B

DWG TITLE:
TYPICAL FLOOR DETAILS

SL + A Sdn. Bhd. retain copyright of all designs and data shown in this drawing. Written permission is required for any use and/or reproduction. All prints, specifications and copyrights are the property of SL + A Sdn. Bhd. and shall be returned on completion of works. Contractor to check dimensions on site and notify SL + A Sdn. Bhd. of discrepancies on site. Do not scale off drawings.

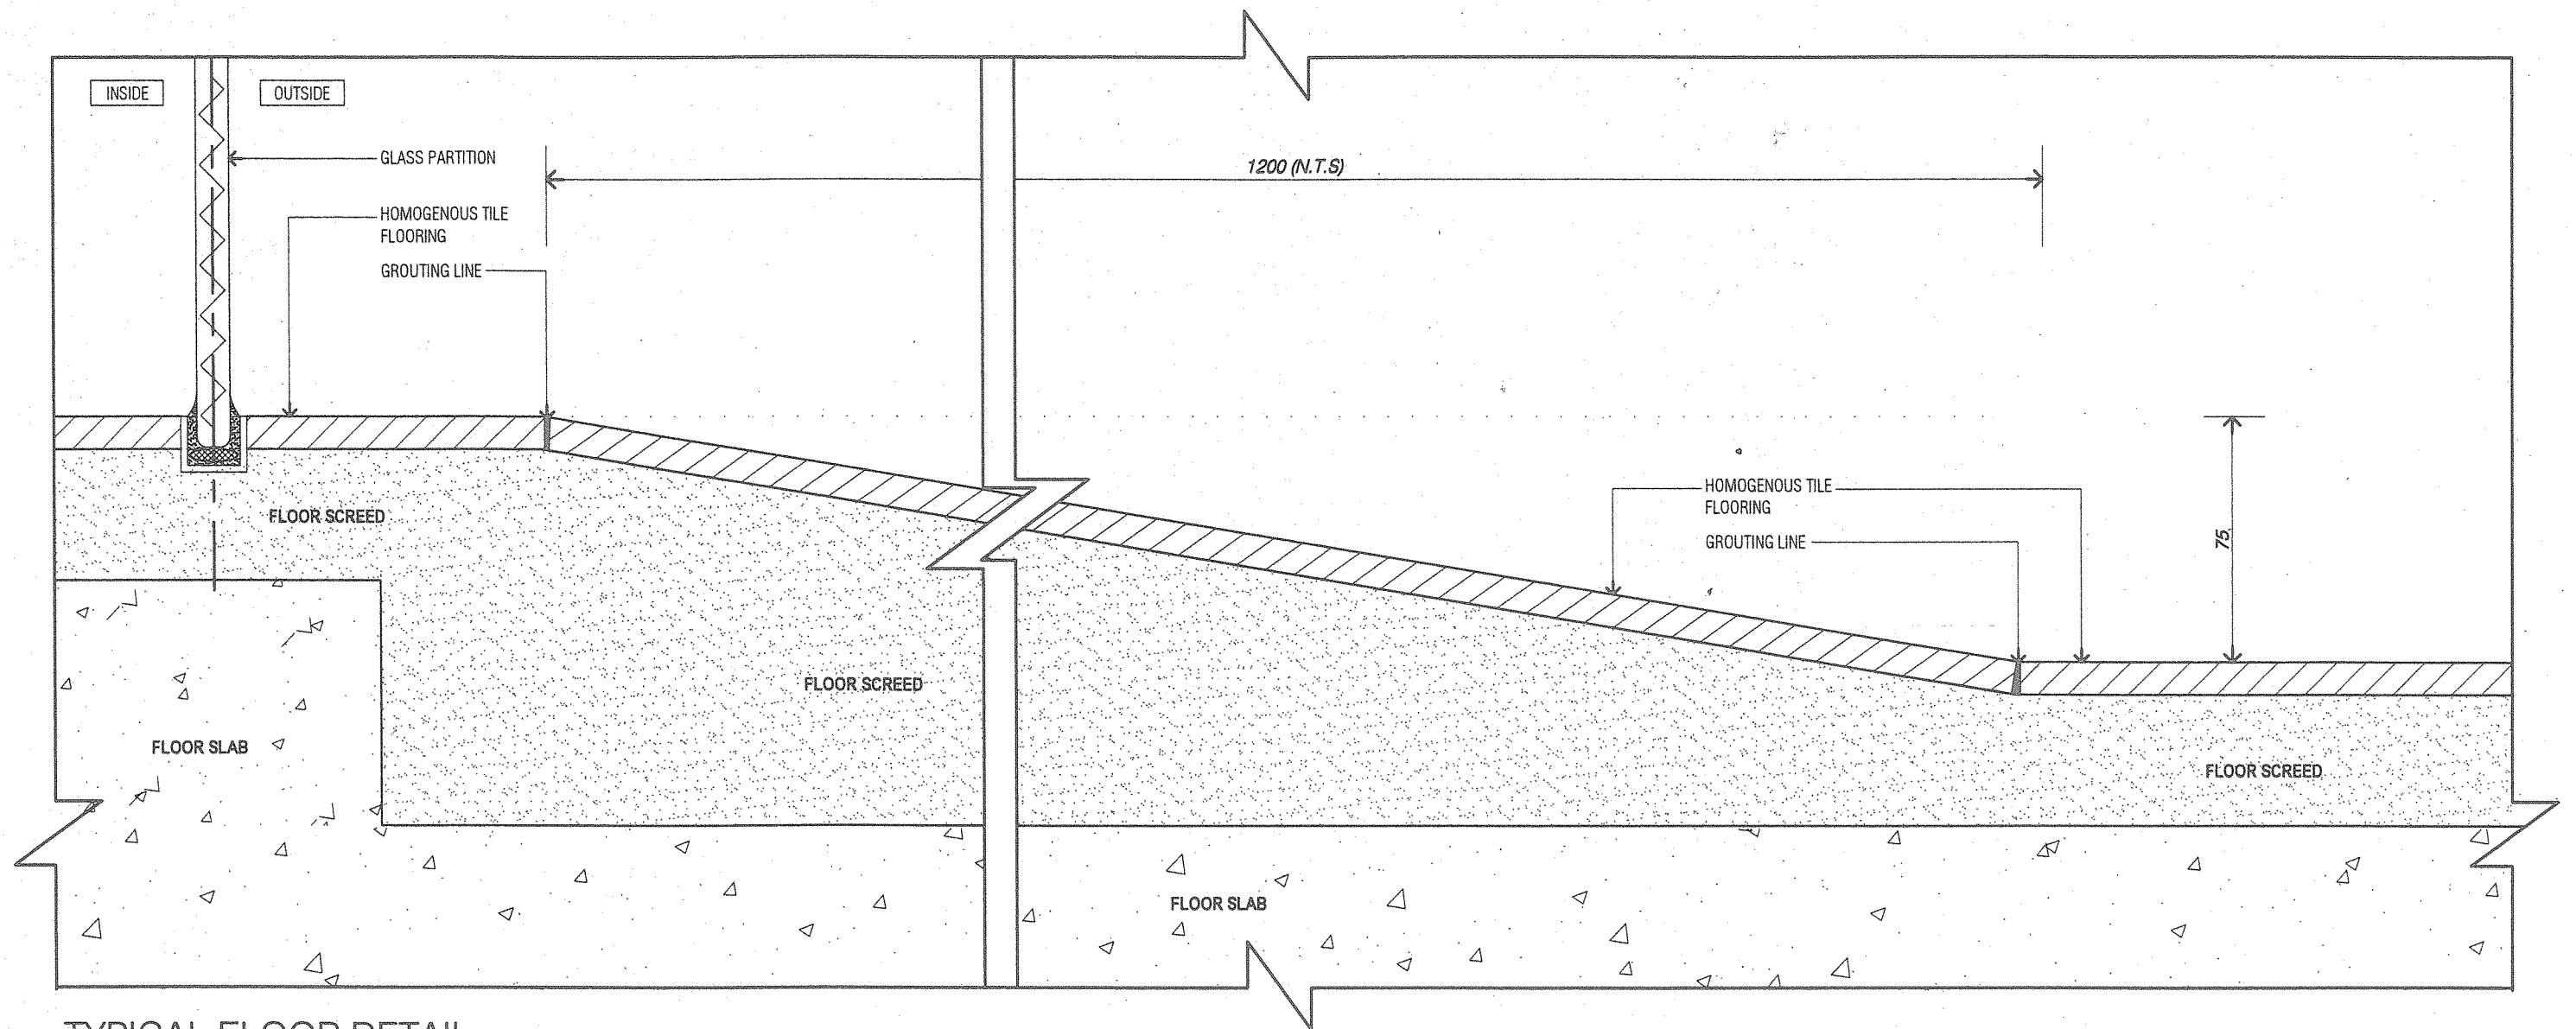

TYPICAL FLOOR DETAIL
FD 05

SCALE 1/5

RAMP @ ENTRANCE DOOR
- SLOPE 1:16 IN HOMOGENOUS TILE FLOORING

PROJECT TITLE:

PROPOSED INTERIOR FIT-OUT WORKS FOR
BANK SIMPANAN NASIONAL

DWG NO:

304-G-002a

DATE:

150525

JOB NO:

15-1615

DRAWN BY:

AZH

CHECK BY:

AZH

SCALE:

AS SHOWN

ISSUE:


B

DATE	ISSUE	DESCRIPTION
150525	B	ISSUE FOR CONSTRUCTION (REVISION 01)
150525	A	ISSUE FOR CONSTRUCTION


DWG TITLE:
TYPICAL FLOOR DETAILS

SL + A Sdn. Bhd. retain copyright of all designs and data shown in this drawing. Written permission is required for any use and/or reproduction. All prints, specifications and copyrights are the property of SL + A Sdn. Bhd. and shall be returned on completion of works. Contractor to check dimensions on site and notify SL + A Sdn. Bhd. of discrepancies on site. Do not scale off drawing.


1. ALL JOINERY GENERALLY CONSTRUCTED FROM 20mm THICK MOISTURE RESISTANT MDF BOARD. Eg. CUPBOARD/DRAWER FRONTS, VERTICAL SUPPORT PANELS & OVERHEAD STORAGE UNITS UNLESS NOTED OTHERWISE.
2. BENCH TOPS GENERALLY 20-40mm THICK SOLID MOISTURE RESISTANT MDF BOARD WITH EDGE PROFILES AS DETAILED. (ie. ALSO ON CURVE BENCH TOP). REFER TO TYPICAL EDGE FOR VENEER OR LAMINATE FINISH AS *DETAIL 1 OR DETAIL 2*
3. UPSTAND ON BENCH TOPS GENERALLY 30-40mm THICK WITH FINISH TO MATCH FRONT DOOR.
4. CARCASSES GENERALLY CONSTRUCTED FROM 30-40mm FULL BOARD MOISTURE RESISTANT MDF BOARD WITH WHITE POLYCEM FINISH TO ALL INTERNAL SURFACES, UNLESS OTHERWISE NOTED.
5. ALL OVERHEAD/ WALL UNITS TO BE SECURELY FIXED TO BRICKWALL/ PARTITIONS WITH H.W FRAME BRACING INFILL & BUTTERFLY SCREW WHERE APPLICABLE.
6. WHERE APPLICABLE, JOINERY UNITS LOCATED BETWEEN WALLS/PARTITIONS, SCRIBED TO FIT SITE CONDITIONS NEATLY ON SITE WITH 10mm SIDE RECESSED SHADOW LINE TO BOTH END.
7. WHERE ANY TIMBER SHADOW LINE IS REQUIRED - MAXIMUM SHADOW LINE WIDTH TO BE 10mm & PACKER TO PAINT IN BLACK OR MATCH LAMINATE OR TIMBER FINISH.
8. MOISTURE RESISTANT CURVING PLYWOOD CAN BE USED FOR CURVED SURFACES, FIX SECURELY AS REQUIRED-FINISH AS SPECIFIED.
9. ALL FIXED OR ADJUSTABLE SHELVING WILL BE 20mm THICK IN MDF BOARD WITH WHITE POLYCEM FINISH UNLESS OTHERWISE NOTED.
10. THE NOTE 'C.O.S' ON DRAWINGS DENOTES DIMENSIONS *CHECK ON SITE*.
11. FABRIC PINBOARDS OR FABRIC BOARDS : GENERALLY CONSTRUCTED FROM 12mm CANEITE PANELS LAMINATED ON 6mm PLY BACKING. 9-10mm SOLID MR-MDF EDGE TRIMS WITH PENCIL ROUND EDGES. FABRIC PULLED TAUGHT OVER BOARD & FIXED AT REAR. PINBOARDS ARE GENERALLY SHOWN AS 1200mm WIDE MAX. HOWEVER, IF FABRIC IS WIDER, CONSTRUCT PINBOARDS TO MAKE ECONOMICAL USE OF FABRICS.
12. ALL DOORS GAP TO HAVE 'HAIRLINE GAPS' AT OPENINGS (MAX 2-3mm) & NO TIMBER STRIPS AT BACK OF CUPBOARD DOORS AS *DETAIL 3*
13. ALL STAINLESS STEEL WELD TO BE CONTINUOUS FILLET WELD. CONTRACTOR TO GRIND, POLISH AND FINISH TO MATCH REQUIRED STAINLESS STEEL FINISH. ALL STAINLESS STEEL WITH 90 DEGREE ANGLE PROFILE TO HAVE APPLY 'V' CUT BEFORE BENDING IT AS *DETAIL 4*.
14. ALL GLASS CLADDING WITH AVERY FILM BACKING TO BE MOUNTED ON A MINIMUM OF 10mm THICK MDF BACKING AND FIXED WITH MAX BOND GLUE OR EQUIVALENT. PROVIDE SHOP DRAWINGS TO DESIGNER FOR APPROVAL.

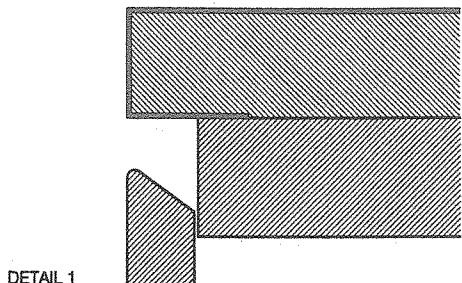


DETAIL 1
TYPICAL WORKTOP DETAIL FOR JOINERY IN STAINLESS STEEL OR LAMINATE EDGING OR VENEER FINISH

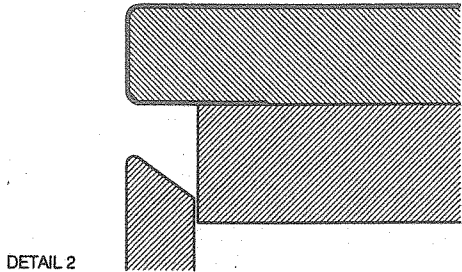

DETAIL 2
TYPICAL BENCHTOP DETAIL FOR JOINERY IN POSTFORMED LAMINATE FINISH

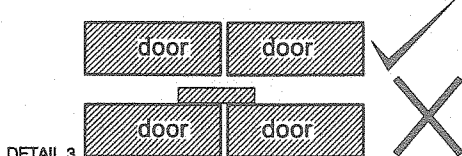

DETAIL 3
TYPICAL CABINET DOOR DETAIL

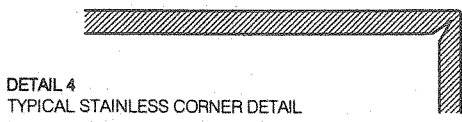

DETAIL 4
TYPICAL STAINLESS CORNER DETAIL

1. ADJUSTABLE SHELVING GENERALLY TO HAVE SHELF SUPPORT PINS AT 50mm CENTRES WITH MATCHING SLEEVES IN HOLES HAFELE- 282.01.505 & 282.50.508 (STAINLESS STEEL) OR ALUMINIUM MULTI TRACK.
2. ALL ADJUSTABLE TEMPERED GLASS SHELF C/W GLASS SHELF SUPPORT 'HAFELE' -281.41.906
3. CABLE ENTRY CAPS : WHITE PLASTIC CAPS & SLEEVES AS PER WORKSTATIONS. ALLOW FOR 'HAFELE' TO DESIGNER'S APPROVAL.

4. ALL CABINET DOORS TO HAVE HEAVY-DUTY FULLY CONCEALED SELF CLOSING HINGES WITH MINIMUM 110 DEGREE OPENING. 'HAFELE' METALLA-A-HINGES' DOUBLE HINGES NEEDED ON TOP FOR CABINET DOOR MORE THAN 1500MM HIGH.
5. ALL FULL HT./ LOW CABINET DOORS AND DRAWERS TO HAVE 'HAFELE' LOCKSET SYMO 3000 LEVER LOCK CYLINDER CORE WITH LOCKING TRAVEL 90 CONVERTABLE & AUTOMATIC DOOR CATCH WITH HOOK AND WEDGE ELEMENT - Cat. No: 245.58.754 NICKEL PLATE
6. ALL CABINET INTERNAL SCREW FIXING TO PROVIDE PLASTIC COVER CAPS 'HAFELE'-045.23.700/ 045.23.010
7. ALL FILE STORAGE DRAWERS TO BE FITTED WITH METAL FILE RUNNERS IN-SIDE PANELS & MID DIVIDERS WHERE APPLICABLE.
8. EXTENDING KEYBOARD PLATFORMS GENERALLY TO BE HAFELE STANDARD-MANUAL OPERATION, STAINLESS STEEL, INSTALLED AS PER-MANUFACTURERS INSTRUCTIONS. CATALOGUE No. 29.80.558.
9. DRAWER RUNNERS GENERALLY TO BE SIDE MOUNTED HEAVY DUTY QUALITY AND ALL DRAWERS TO BE FULLY EXTENTABLE. KITCHEN/ PANTRY/ STORAGE DRAWERS TO HAVE NYLON ROLLERS. ALL STORAGE DRAWERS TO HAVE BALL BEARING ACTION WITH ADEQUATE LOAD BEARING CAPACITY. HETTICH 602.


1. ALL JOINTS BETWEEN TIMBER VENEER FINISHES TO BE INVISIBLE- CONTINUOUS GRAIN APPEARANCE WHERE APPLICABLE. GRAIN OF ADJOINING PIECES TO BE BOOKMATCHED. SELECTED VENEER STRIPS TO BE AT LEAST 200MM WIDE.
2. ALL JOINTS BETWEEN LAMINATE OR VENEER/ STAINLESS STEEL FINISHES WHEREVER APPLICABLE TO BE INVISIBLE.
3. ALL VISIBLE EDGE STRIPS, SHELVES, SIDES & REAR PANELS IN OPEN SHELVING UNITS TO MATCH CUPBOARD/ DRAWER FRONTS.
4. ALL BACK & SIDE PANELS & VERTICAL SUPPORT PANELS TO HAVE SAME FINISH AS CUPBOARDS/ DRAWER FRONTS.
5. ALL KICKBOARDS IN TOE SPACES GENERALLY 50 -150mm HIGH & SET BACK 50-100mm FROM FACE OF CUPBOARD/ DRAWER FRONTS. VENEER/ LAMINATE FINISH TO BE SPECIFIED.
6. SOLID TIMBER EDGES, IF NECESSARY, TO MATCH VENEER WITH CLEAR COAT AS PER VENEER JOINER TO PROVIDE SAMPLES TO DESIGNER FOR APPROVAL.
7. STAINLESS STEEL IN SATIN/ HAIRLINE FINISH WITH HIGH QUALITY APPEARANCE REQUIRED.-SEE NOTES ON DRAWINGS.
8. JOINER TO SUBMIT ALL SAMPLES TO DESIGNER FOR APPROVAL.

DWG NO:
S05-G-001
DATE: 150523
JOB NO: 13-1527


DRAWN BY: AZH
CHECK BY: AZH

SCALE:
N.T.S.
ISSUE:
A


DWG TITLE:
JOINERY COVER NOTES
SL + A Sdn. Bhd. retain copyright of all designs and shown in this drawing. Written permission is required any use and/or reproduction. All prints, specifications copyrights are the property of SL + A Sdn. Bhd. and be returned on completion of works. Contractor to check dimensions on site and notify SL + A Sdn. Bhd. discrepancies on site. Do not scale off drawings.

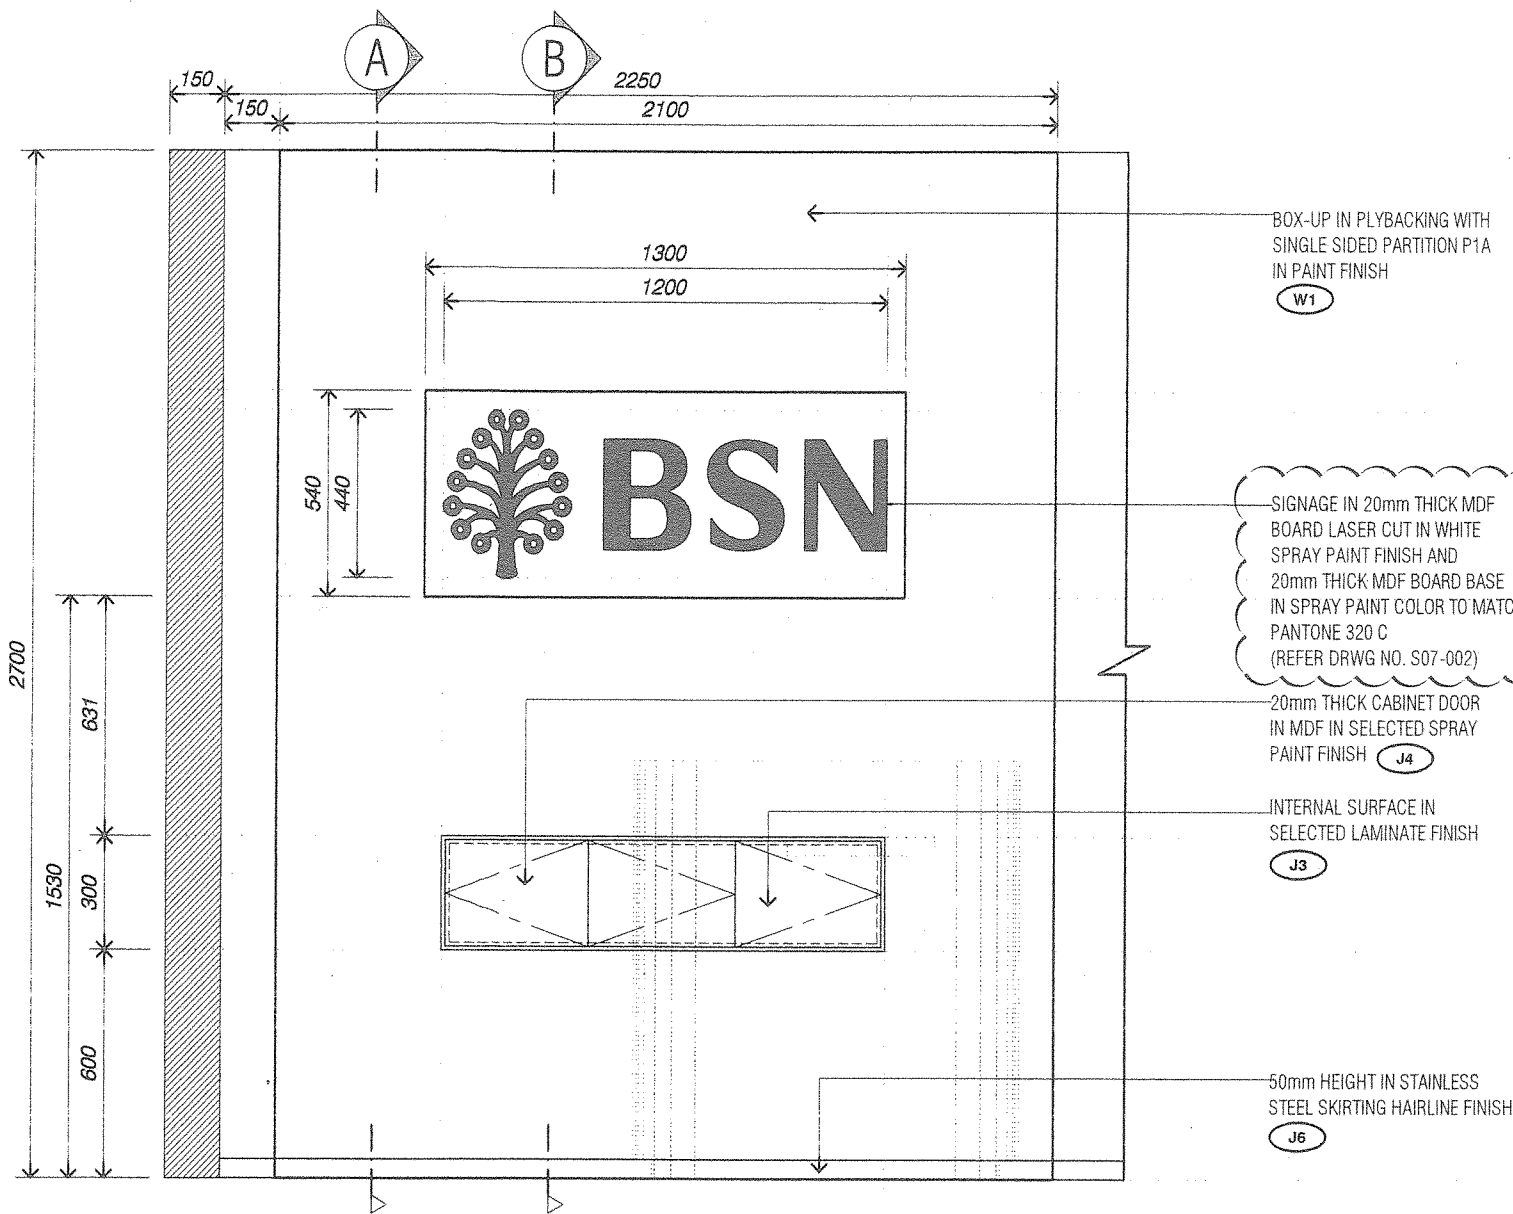


BF3 ELEVATION 1
SCALE 1/20

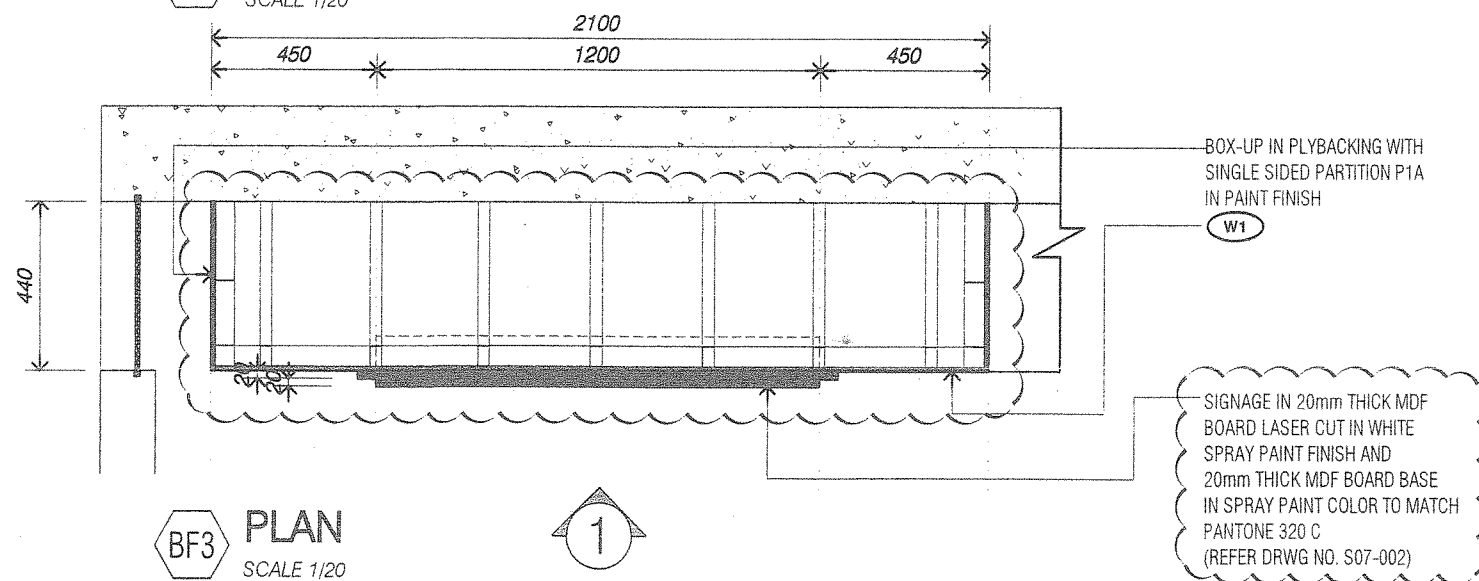

BF3 PLAN
SCALE 1/20

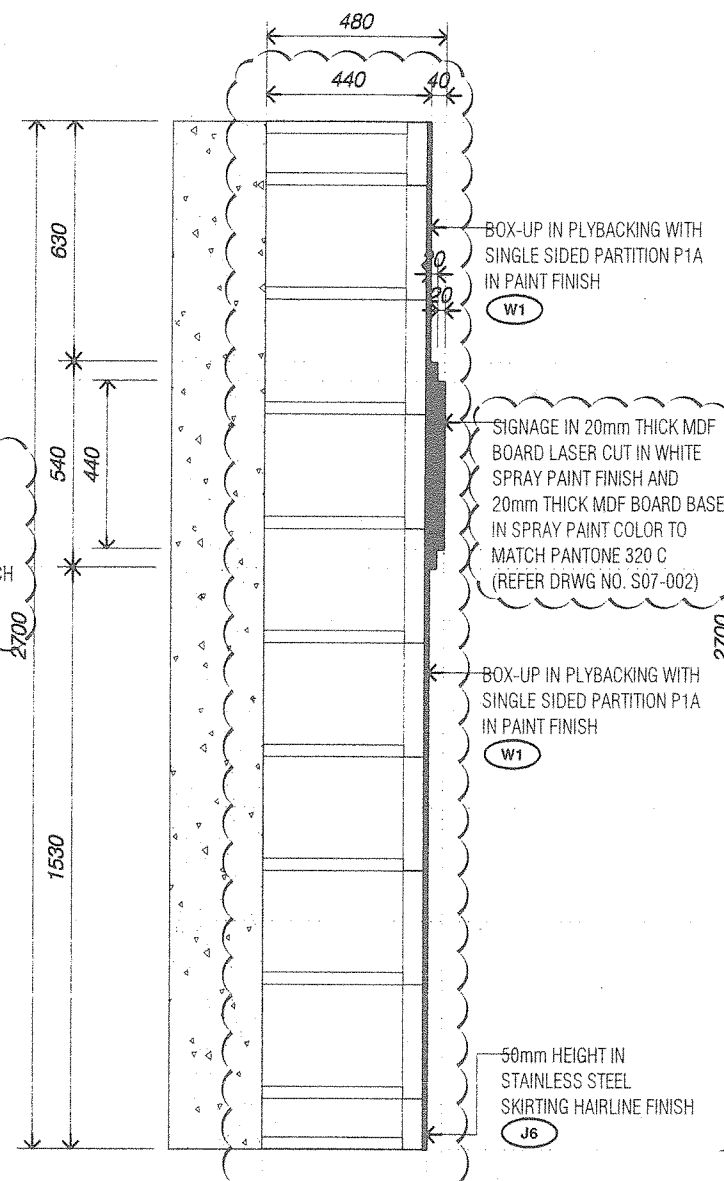

BF3 SECTION A
SCALE 1/20

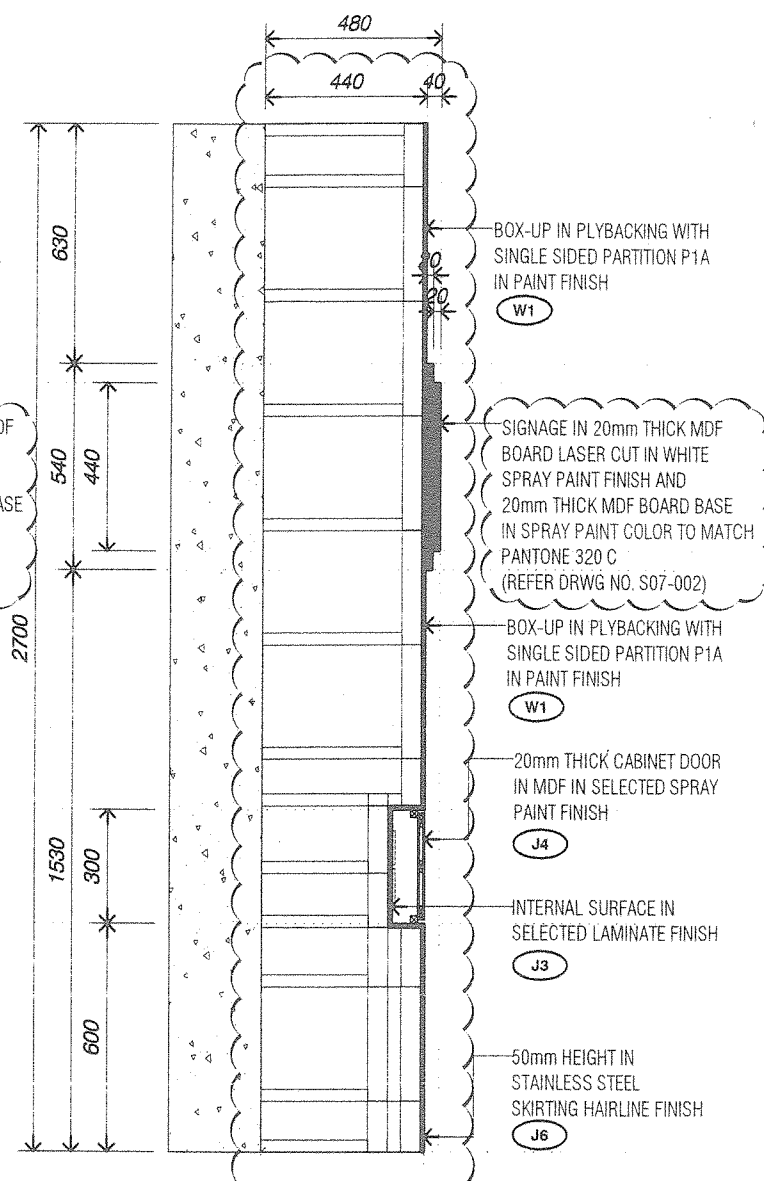

BF3 SECTION B
SCALE 1/20

PROJECT TITLE:

PROPOSED INTERIOR FIT-OUT WORKS FOR
BANK SIMPANAN NASIONAL

DWG NO:
S05-G-007

DATE: 150525
DRAWN BY: MZ

JOB NO: 15-1615
CHECK BY: AZH

SCALE:
AS SHOWN

ISSUE:

DWG TITLE:
BF3
Logo Wall

SL + A Sdn. Bhd. retain copyright of all designs and data shown in this drawing. Written permission is required for any use and/or reproduction. All prints, specifications and copyrights are the property of SL + A Sdn. Bhd. and shall be returned on completion of works. Contractor to check dimensions on site and notify SL + A Sdn. Bhd. discrepancies on site. Do not scale off drawings.